

1 PLUMBING PLAN
SCALE: 1/8" = 1'-0"



2 ENLARGED PARTIAL PLUMBING PLAN
SCALE: 1/4" = 1'-0"

FIXTURE SCHEDULE

- H/C LAVATORY, AMERICAN STANDARD MODEL NO. 0356.028 MOUNTED WITH TOP AT 34" AFF. PROVIDE WITH 200100 SELF CLOSING FAUCET, GRID STRAINER AND ANGLE STOP. PROVIDE TRAP INSULATION WRAP, BROGAR PRODUCTS, INC. OR EQ.
- H/C WATER CLOSET, KOHLER MODEL K-4286 (BOXL) & K4634 (TANK), 1.6 GAL. FLUSH. PROVIDE WITH BREVIA K-4664 SEAT LESS COVER.
- TOILET ROOM WATER HEATER, INSTANTANEOUS POINT OF USE EEMAX # SP2412, 120V, 2.4KW
- DRINKING FOUNTAIN, BARRIER-FREE SPLIT-LEVEL WATER COOLER AS MANUF. BY OASIS, MODEL NO. P8AMSL 1150 / 10
- STORAGE ROOM WATER HEATER, INSTANTANEOUS POINT OF USE EEMAX # EX1608TC, 208V, 16.8KW
- STAINLESS STEEL MOP SINK, AERO MODEL NO. SMP-2424-6 (24"x24"x10") PROVIDE WITH AERO MODEL NO. 9-T0 POLISHED CHROME FINISH EXPOSED-YOKE WALL-MOUNTED UTILITY FAUCET W/ WATTS SERIES 8 HOSE CONNECTION VACUUM BREAKER.
- POST HYDRANT - ZURN MODEL # Z-1545 - 3/4"
- HOSE BIBB - ZURN MODEL # Z-1930 - 3/4"
- ROOF DRAIN, ZURN MODEL NO. Z-121 12" DIAMETER ROOF DRAIN, DURA-COATED CAST IRON BODY W/ COMBO MEMBRANE FLASHING CLAMP / GRAVEL GUARD & LOW SILHOUETTE CAST IRON DOME.
- CONDENSATE PUMP, WFG # CUB5UL 115 VOLT, ALSO AVAILABLE IN HIGH TEMP. TEMP. TANK RATED 180°F BY SPECIAL ORDER.

PER FFC 2007 W/ 2004 SUPPLIMENTS (TABLE 403.1)	WATER CLOSET 1 PER 500	LAVATORY 1 PER 750	DRINKING FOUNTAIN 1 PER 1000
8,215 SF GFA @ 30 SF = 274 PEOPLE	MEN		(1) H/C ACCESSIBLE
1,626 SF GFA @ 300 SF = 6 PEOPLE	WOMEN		
TOTAL =			

- KEY NOTES**
- 1/2" VALVED COLD WATER DOWN TO HUMIDIFIER
 - CONDENSATE LINE WITH CLEAN OUT AT MECHANICAL UNIT SEE PLAN FOR SIZE
 - OVERFLOW LINE SEE PLAN FOR SIZE
 - DRYWELL, REFER TO DETAIL ON SHEET P-2
 - 1/2" TRAP PRIMER
 - 1/2" VALVED COLD WATER DOWN TO ICE CUBER
 - 3/4" COLD WATER DOWN TO 3-COMPARTMENT SINK. SINK IS TO BE USED FOR SANITATION OF ICE SCOOP
 - PROVIDE AND INSTALL SOAP DISP/ PAPER TOWEL DISP. ON WALL THIS LOCATION - SEE SPECIFICATIONS ON SHEET P-2
 - EMERGENCY SHUT-OFF VALVE
 - 4" RAIN WATER LEADER UP TO ROOF DRAIN ABOVE
 - 8" RAIN WATER LEADER DOWN TO BELOW GRADE
- LEGEND**
- | | |
|--|---------------------------|
| — COLD WATER LINE | — HB HOSE BIBB |
| — HOT WATER LINE | — FD FLOOR DRAIN |
| — SANITARY SEWER LINE | — CO FLOOR CLEAN-OUT |
| — VENT | — WCO WALL CLEAN-OUT |
| — RAIN WATER LEADER | — FS FLOOR SINK |
| — GATE VALVE | — FD FLOOR / FUNNEL DRAIN |
| — PDI WATER HAMMER ARRESTER SIOUX CHIEF OR EQUAL | — 2-WAY CLEAN OUT |

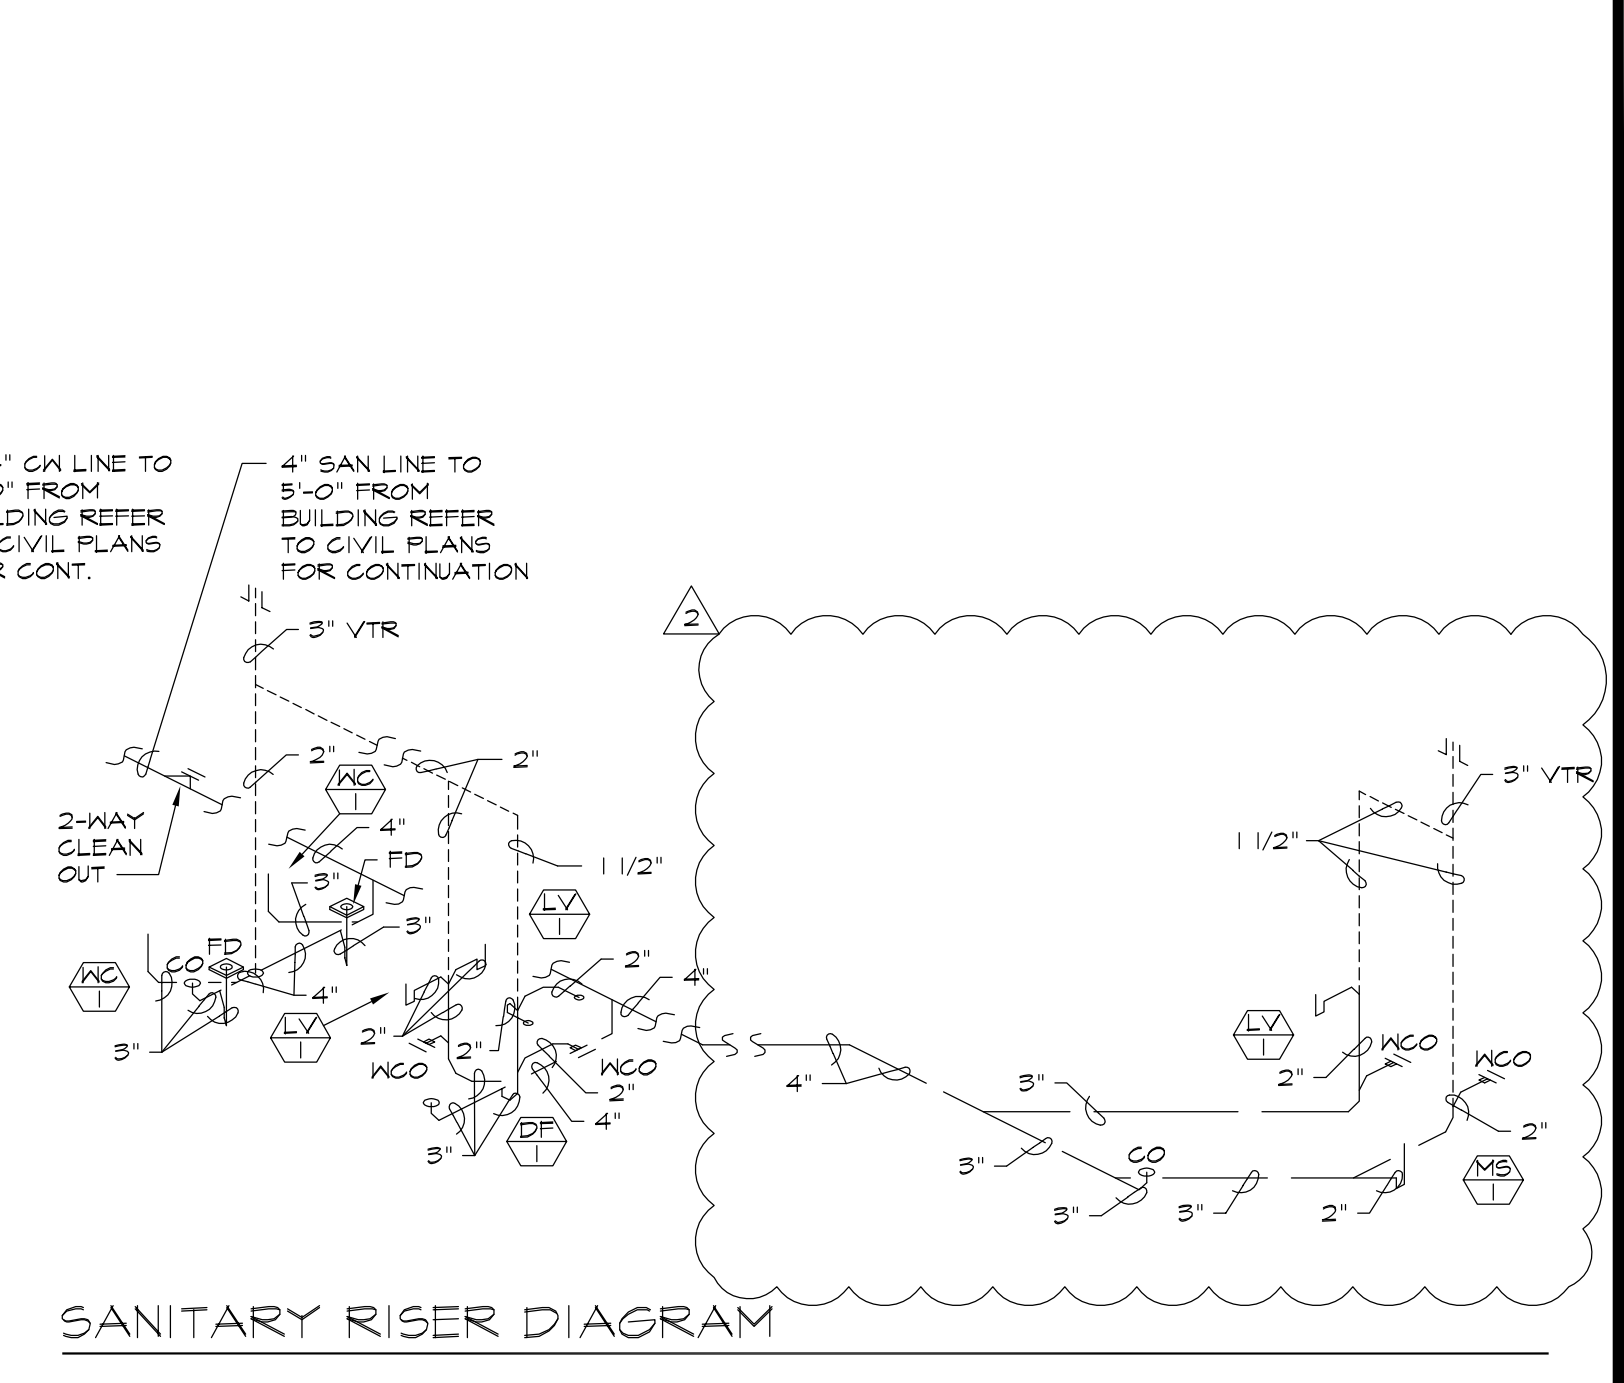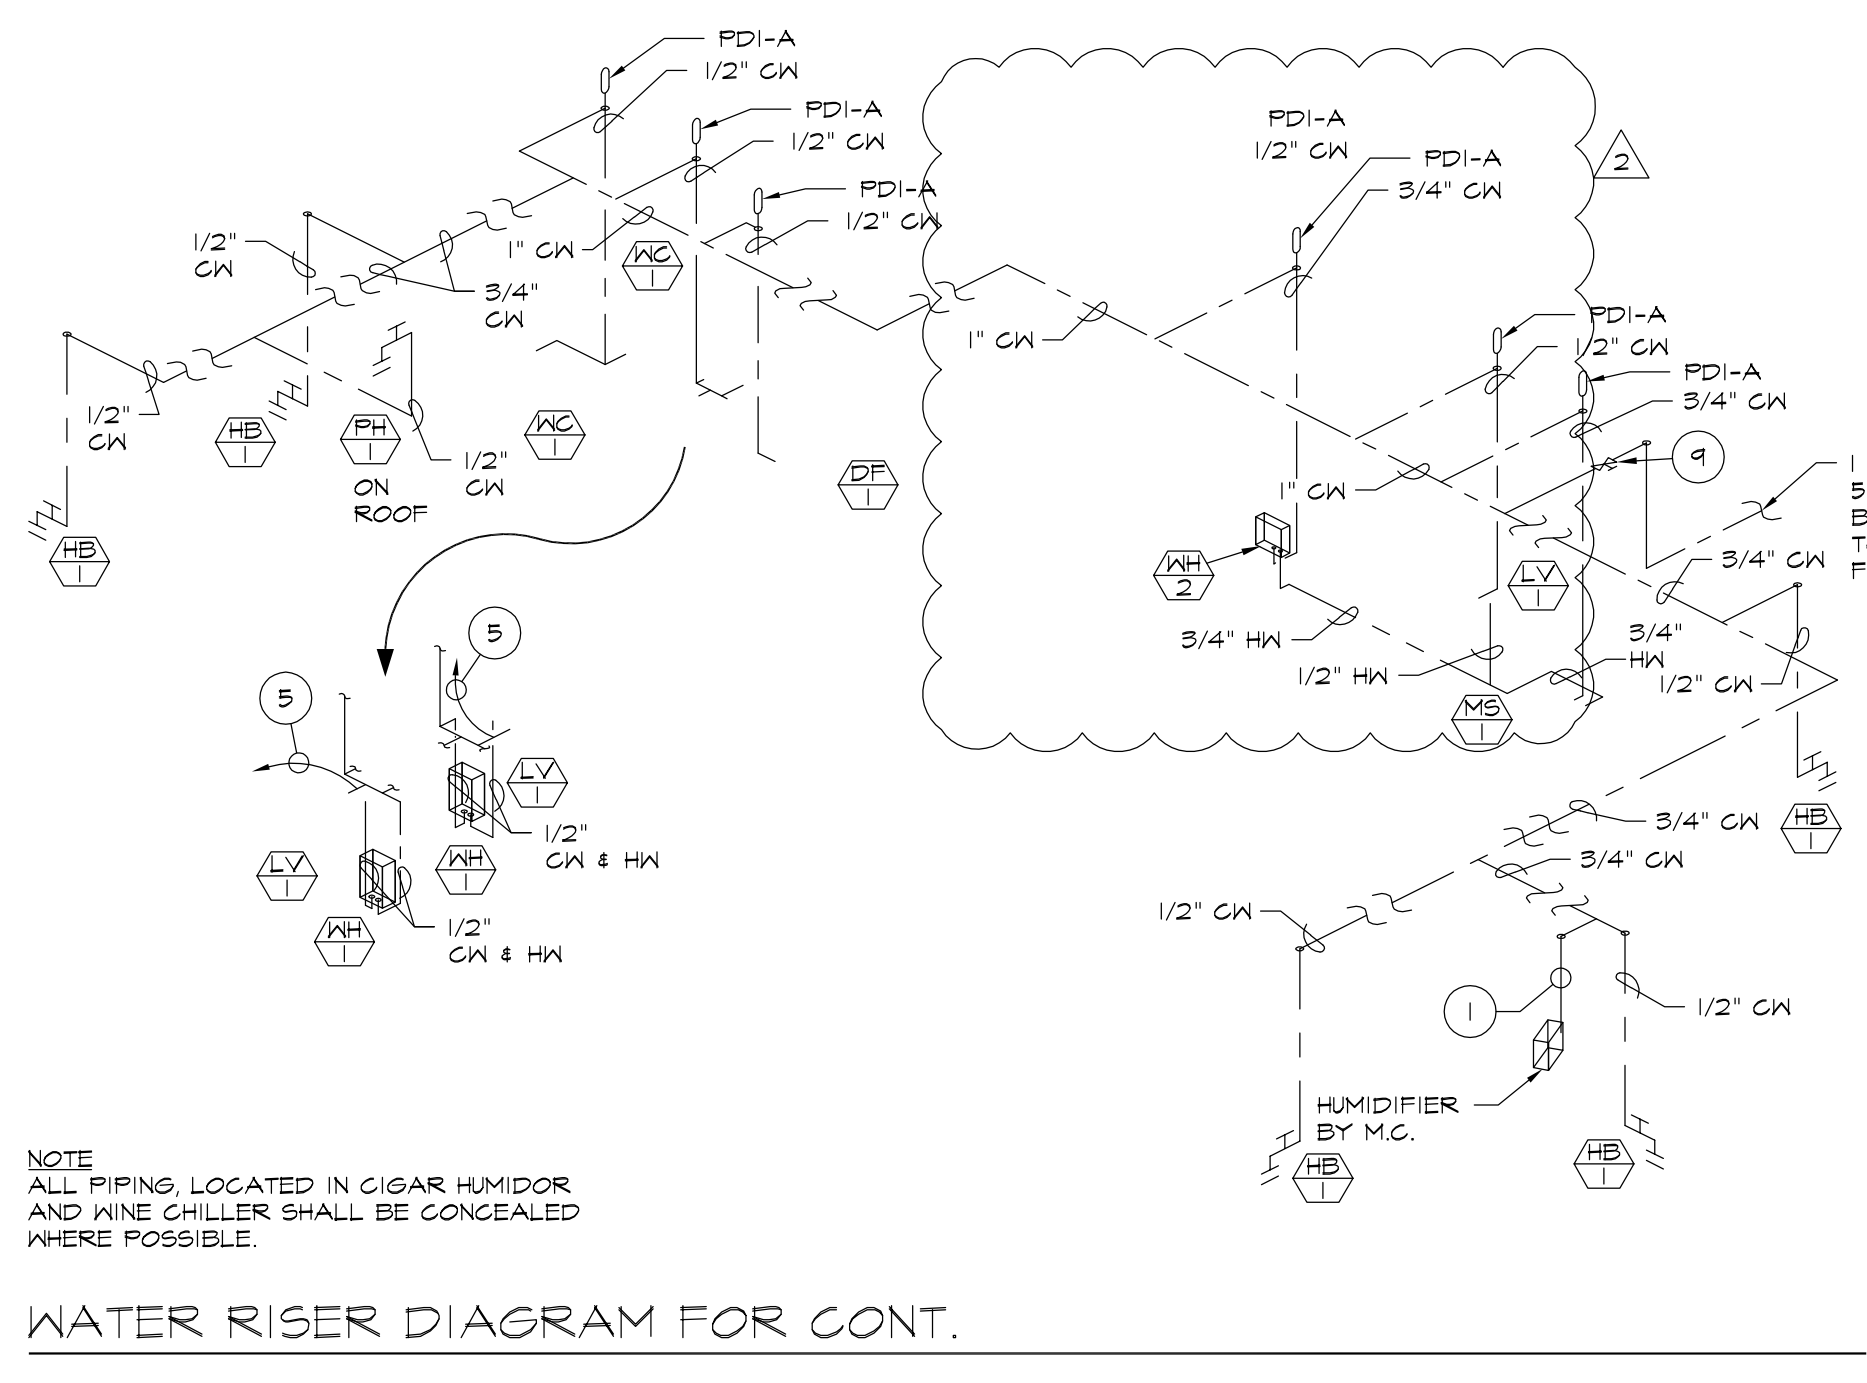

REVISIONS BY

REVISION	DATE	BY
BUILDING DEPT	9-9-09	MCM
OWNER REVISION	7/28/10	S.R.R.

ARTERBURY ARCHITECTS, INC.
AA 26000718
1009 MAITLAND CENTER COMMONS BLVD
(SUITE 216) MAITLAND, FL 32751
TEL: (407) 774-2233
FAX: (407) 774-7377

ABC LIQUORS, INC.
8989 S. ORANGE AVE. - ORLANDO, FLA. 32809
ABC STORE NO. 197
PALM COAST, FL

PLUMBING PLAN

DRAWN:	M. MAISCO
CHECKED:	S. RIVERA
DATE:	5-15-09
SCALE:	AS NOTED
JOB NO.:	197
SHEET	