

1 PHOTOMETRICS PLAN
SCALE: 1" = 20'-0"

LITHONIA LIGHTING Arm-Mounted Drop or Flat Lens Cutoff
 Dimensions shown in inches (centimeters) unless otherwise noted.
 KAD08/R3/27
 EPA: 1.28(11m²) 1.49(13m²)
 Square: 17-1/2(443) 17-1/2(443)
 Height: 2-1/8(51.0) 11-1/8(28.3)
 Max weight: 42(94.5) lb 41(91.3) lb

KAD

SPALDING LIGHTING SOFFITIER
 Flush mounted under soffit.

ST MS17 SY F


SOF

LUMINAIRE SCHEDULE

| SYMBOL | LABEL | QTY | CATALOG NUMBER | DESCRIPTION | LAMP | LUMENS | LLF | NOTES |
|--------|-------|-----|----------------|---|---|--------|------|---|
| □ | KAD | 5 | KAD 400M R3 | LITHONIA - DIE CAST ALUMINUM HOUSING FLAT GLASS LENS | ONE 400-WATT CLEAR BT-37 METAL HALIDE, HORIZONTAL POSITION. | 32000 | 0.89 | LIGHT AND POLE TO HAVE A BRONZE FINISH. PROVIDE W/ HOUSE SIDE SHIELD. PHOTOMETRICS FILE: 92040902.IES |
| □ | SOF | 17 | ST MS17 SY F | SOFFITIER SQUARE RECESSED LIGHT FLAT DIFFUSE GLASS LENS | 175W CLEAR ED17 METAL HALIDE, VERTICAL POSITION | 8600 | 0.67 | PHOTOMETRICS FILE: SOFFITIER.IES |

PHOTOMETRICS STATISTICS

| Description | Symbol | Avg | Max | Min | Max/Min | Avg/Min |
|----------------------------|--------|--------|---------|--------|---------|---------|
| SITE PHOTOMETRICS | + | 2.4 fc | 17.6 fc | 0.0 fc | 1.3:1 | 1.2:1 |
| PARKING AREA PHOTOMETRICS | x | 3.7 fc | 12.7 fc | 0.1 fc | 68:0:1 | 13:0:1 |
| PROPERTY LINE PHOTOMETRICS | ◇ | 0.1 fc | 0.2 fc | 0.0 fc | N / A | N / A |

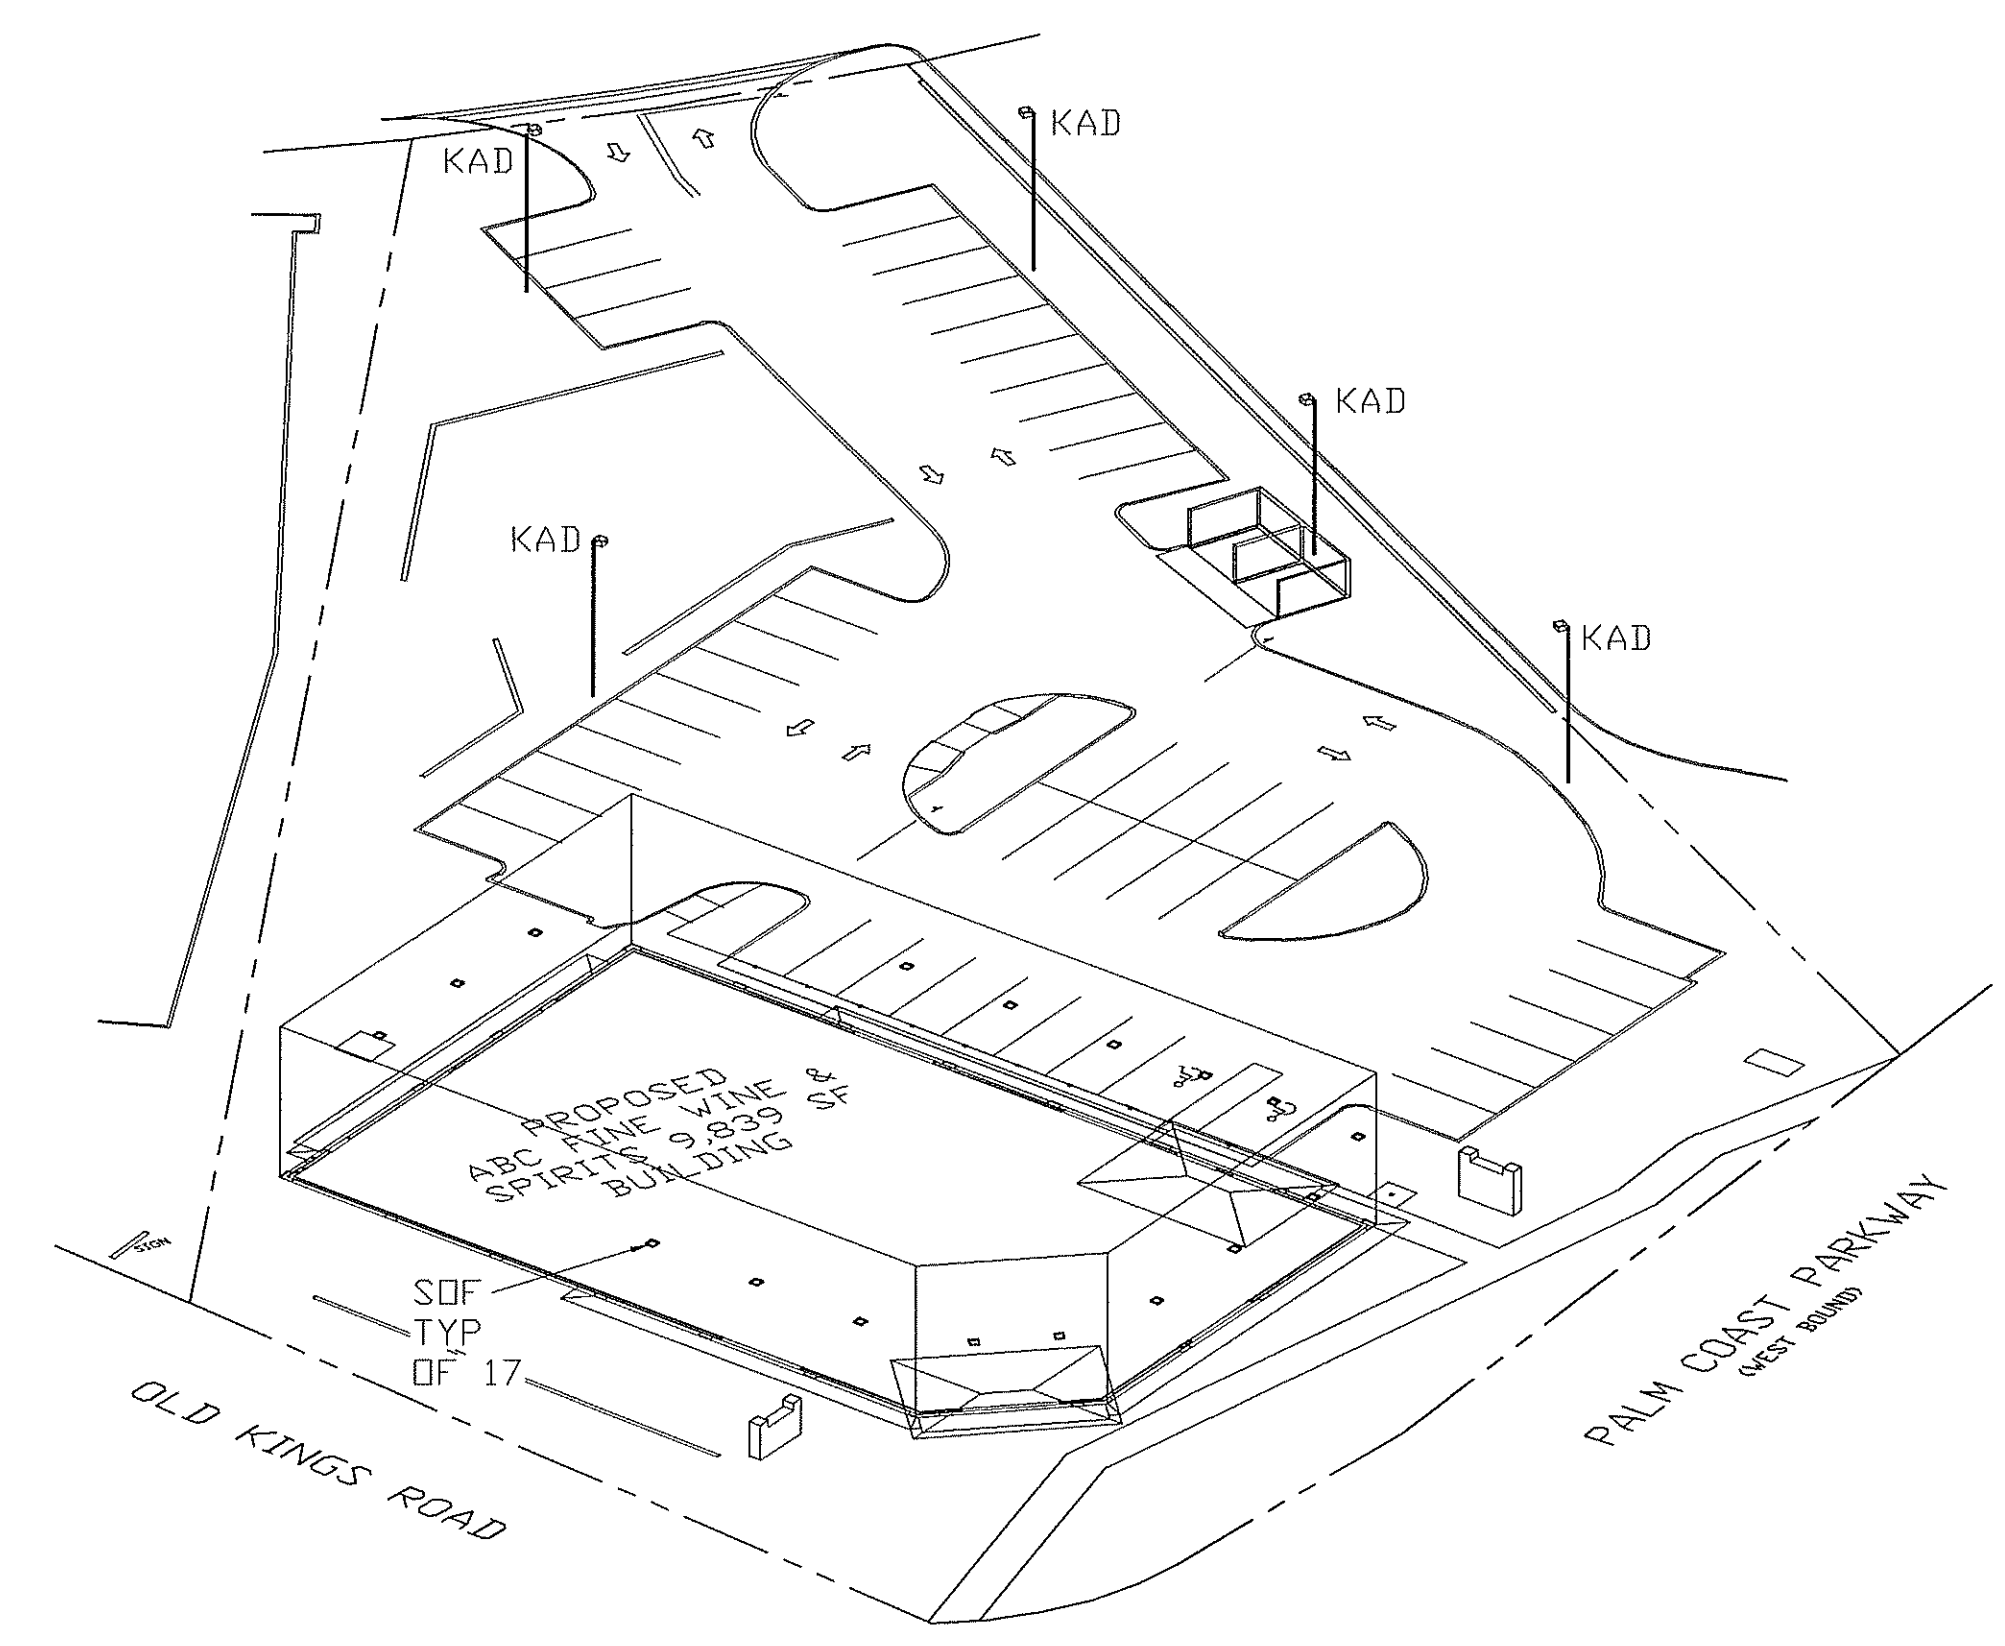

2 ISOMETRIC VIEW
SCALE: NTS

| REVISIONS | BY |
|-----------|----|
| | |
| | |
| | |
| | |

ARTERBURY ARCHITECTS, INC.
 A.A.26000718

1009 MAITLAND CENTER COMMONS BLVD
 (SUITE 216) MAITLAND, FL 32751

TEL: (407) 774-2233
 FAX: (407) 774-7377

Handwritten signature
 9-28-09

ABC LIQUORS, INC.
 8889 S. ORANGE AVE. - ORLANDO, FLA. 32809

ABC STORE NO. 197
 PALM COAST, FL

PHOTOMETRICS PLAN

| | |
|----------|-----------|
| DRAWN: | M. MAISCO |
| CHECKED: | S. RIVERA |
| DATE: | 5-1-08 |
| SCALE: | AS NOTED |
| JOB No: | 197 |
| SHEET | |

SL-2