


1 REFLECTED CEILING PLAN  
SCALE: 1/8" = 1'-0"


NOTE:  
REFER TO ELEC./ LIGHTING PLAN FOR  
EXIT, EMERGENCY, AND NIGHT LIGHTING  
LOCATIONS.

REFLECTED CEILING LEGEND:


- ROUND SUPPLY DIFFUSER. SEE MECHANICAL DRAWINGS FOR SPECIFICATIONS.
- SQUARE SUPPLY DIFFUSER. SEE MECHANICAL DRAWINGS FOR SPECIFICATIONS.
- FILTERED RETURN REGISTER. SEE MECHANICAL DRAWINGS FOR SPECIFICATIONS.
- ⊗ EXHAUST GRILLE. SEE MECHANICAL AND ELECTRICAL DRAWINGS FOR SPECIFICATIONS.
- 4' OR 8' LAMP STRIP LIGHT. SEE ELECTRICAL DRAWINGS FOR SPECIFICATIONS.
- HALL WASH STRIP WITH REFLECTOR. SEE ELECTRICAL DRAWINGS FOR SPECIFICATIONS.
- FLUORESCENT HIGH BAY. SEE ELECTRICAL DRAWINGS FOR SPECIFICATIONS. MOUNT LIGHTS TO UNISTRUT CHANNEL SUSPENDED FROM STRUCTURE.
- ADJUSTABLE BIA-X WALL WASH. SEE ELECTRICAL DRAWINGS FOR SPECIFICATIONS.
- 8" HORIZONTAL REGRESSED LENSED DOWNLIGHT. SEE ELECTRICAL DRAWINGS FOR SPECIFICATIONS.
- 8" SQUARE KATI PENDANT. SEE ELECTRICAL DRAWINGS FOR SPECIFICATIONS. (BOTTOM OF PENDANT TO BE 1'-0" A.F.F.)
- 16" Ø BRUSHED STAINLESS DOME PENDANT. SEE ELECTRICAL DRAWINGS FOR SPECIFICATIONS. (BOTTOM OF PENDANT TO BE 8'-0" A.F.F.)
- SURFACE MOUNTED COOLER LIGHT. SEE ELECTRICAL DRAWINGS FOR SPECIFICATIONS.
- ◁ EMERGENCY LIGHTING. SEE ELECTRICAL DRAWINGS FOR SPECIFICATIONS.
- TRACK LIGHTING. SEE ELECTRICAL DRAWINGS FOR SPECIFICATIONS.
- ⬇ HALO L5056 STASIS CERAMIC METAL HALIDE LAMP ON GRID. SEE ELECTRICAL DRAWINGS FOR SPECIFICATIONS. MOUNT TO GRID OR CEILING AS NOTED PER PLANS.
- ◻ RECESSED AT MANSARD SOFFIT LIGHTING. SEE ELECTRICAL DRAWINGS FOR SPECIFICATIONS.
- ⚡ EMERGENCY LIGHT. SEE ELECTRICAL DRAWINGS FOR SPECIFICATIONS.
- ⚡ EXIT / EMERGENCY LIGHT COMBO. SEE ELECTRICAL DRAWINGS FOR SPECIFICATIONS.
- Ⓢ AUDIO SPEAKER. SEE ELECTRICAL DRAWINGS FOR SPECIFICATIONS.
- ▨ 6" T&G RS CEDAR CEILING

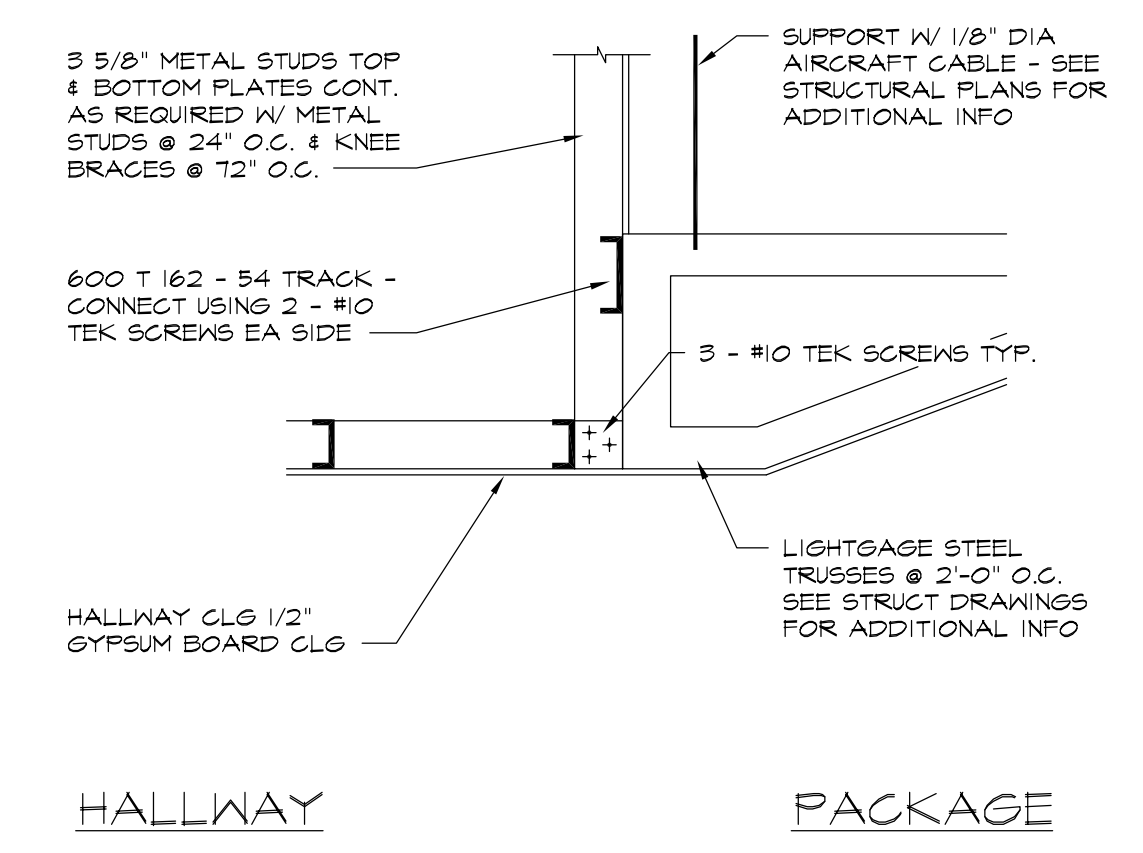


3 SECTION @ HALLWAY ENTRANCE  
SCALE: 3/4" = 1'-0"

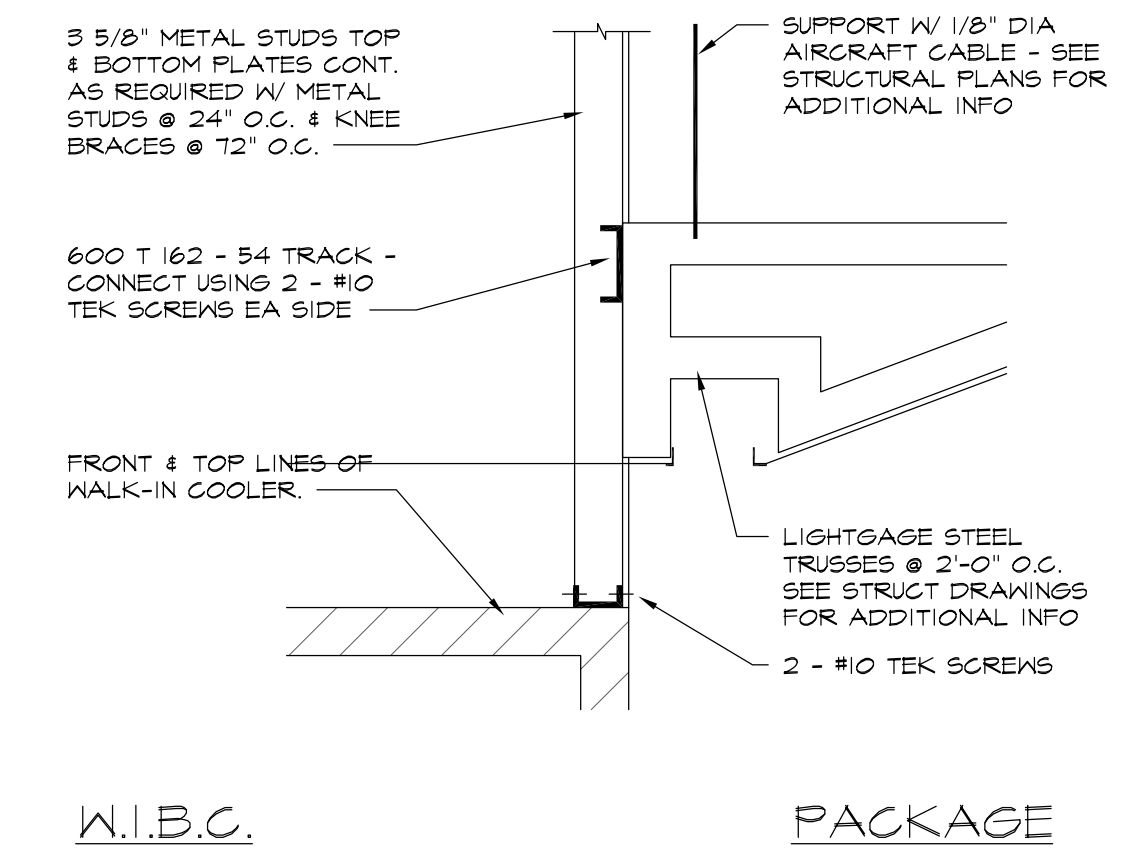

4 WALL ABOVE W.I.B.C. AT PACKAGE  
SCALE: 3/4" = 1'-0"

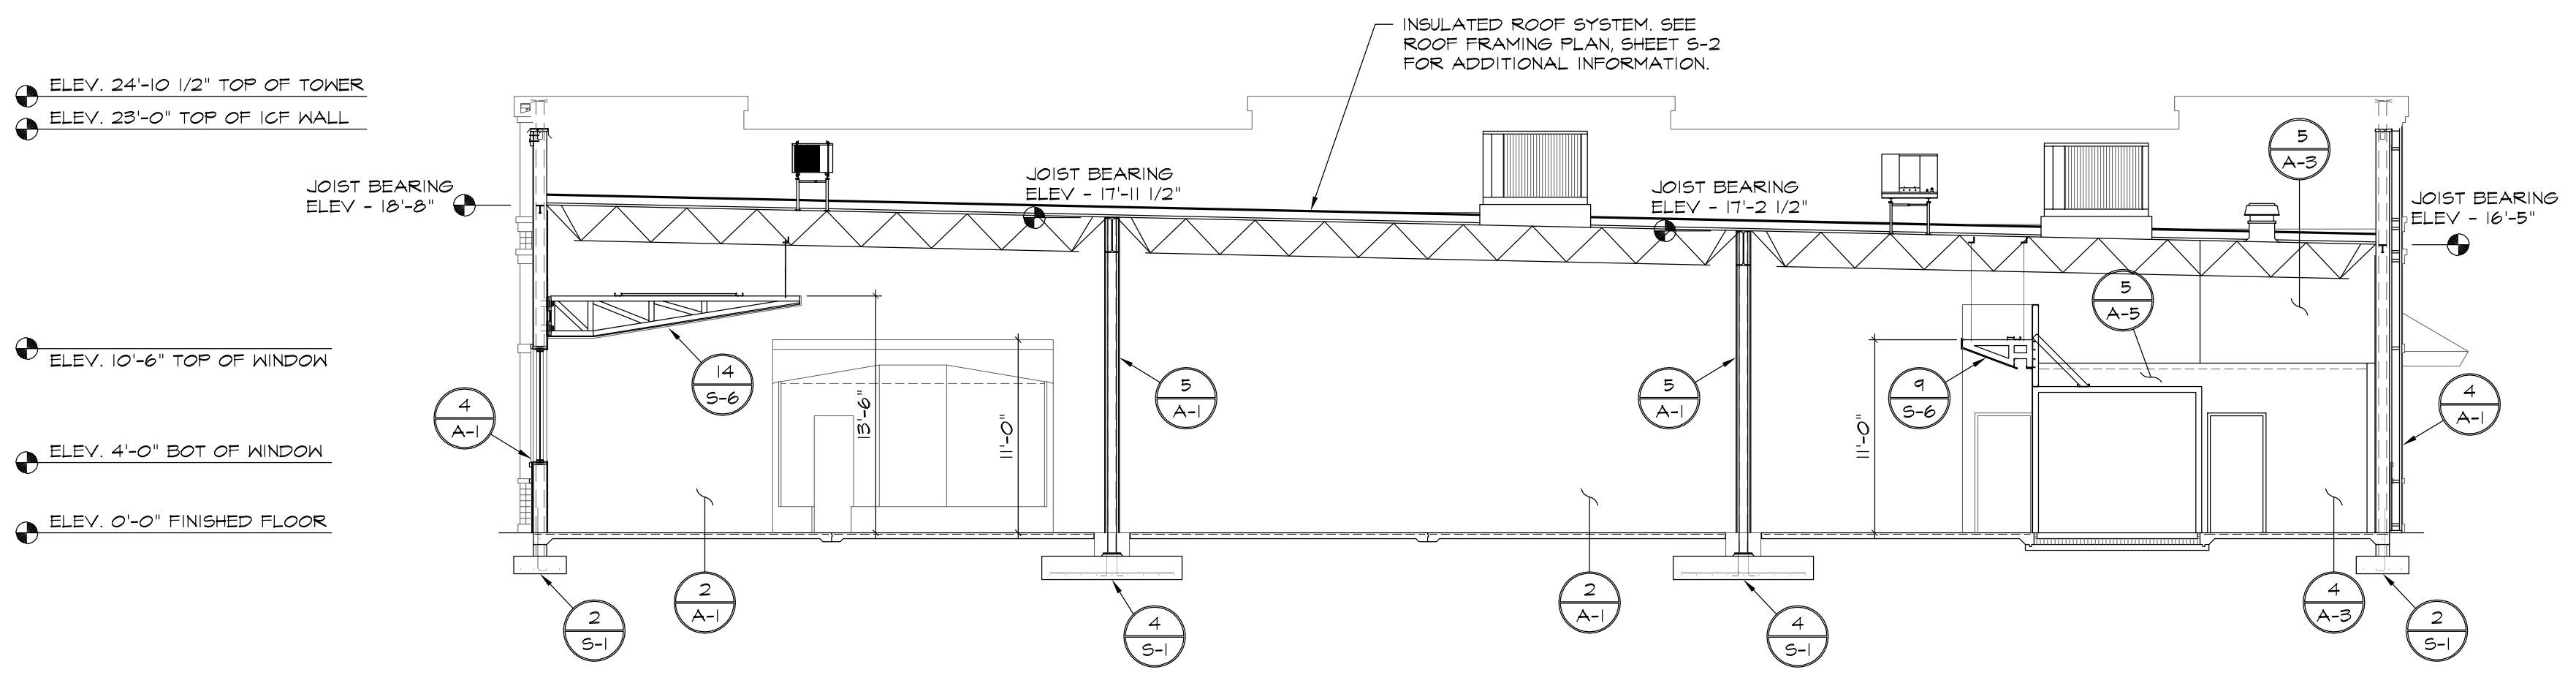

2 BUILDING SECTION  
SCALE: 1/8" = 1'-0"

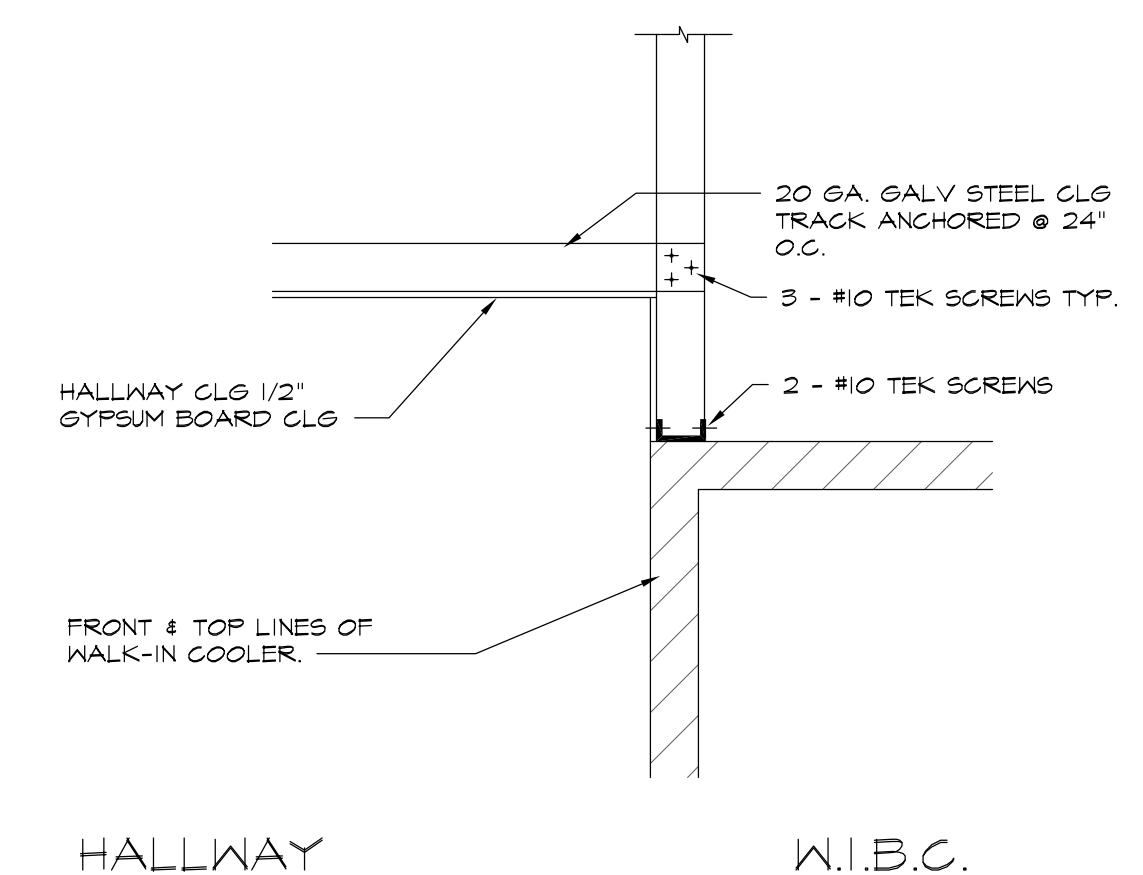

5 WALL ABOVE W.I.B.C. AT HALLWAY  
SCALE: 3/4" = 1'-0"

REVISIONS		BY
OWNER REVISION	1-30-10	MCM

**ARTERBURY ARCHITECTS, INC.**  
AA 26000718  
1009 MAITLAND CENTER COMMONS BLVD  
(SUITE 216) MAITLAND, FL. 32751  
TEL: (407) 774-2233  
FAX: (407) 774-7377

**ABC LIQUORS, INC.**  
8989 S. ORANGE AVE. - ORLANDO, FLA. 32809  
**ABC STORE NO. 43**  
VERO BEACH CENTURY TOWN CENTER

REFLECTED CEILING PLAN  
DRAWN: M. MAISCO  
CHECKED: S. RIVERA  
DATE: 5-15-04  
SCALE: AS NOTED  
JOB No: 43  
SHEET  
**A-5**