

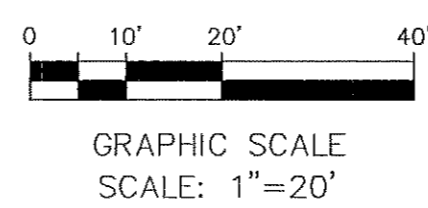


1 SITE PHOTOMETRICS PLAN  
SCALE: 1" = 20'-0"

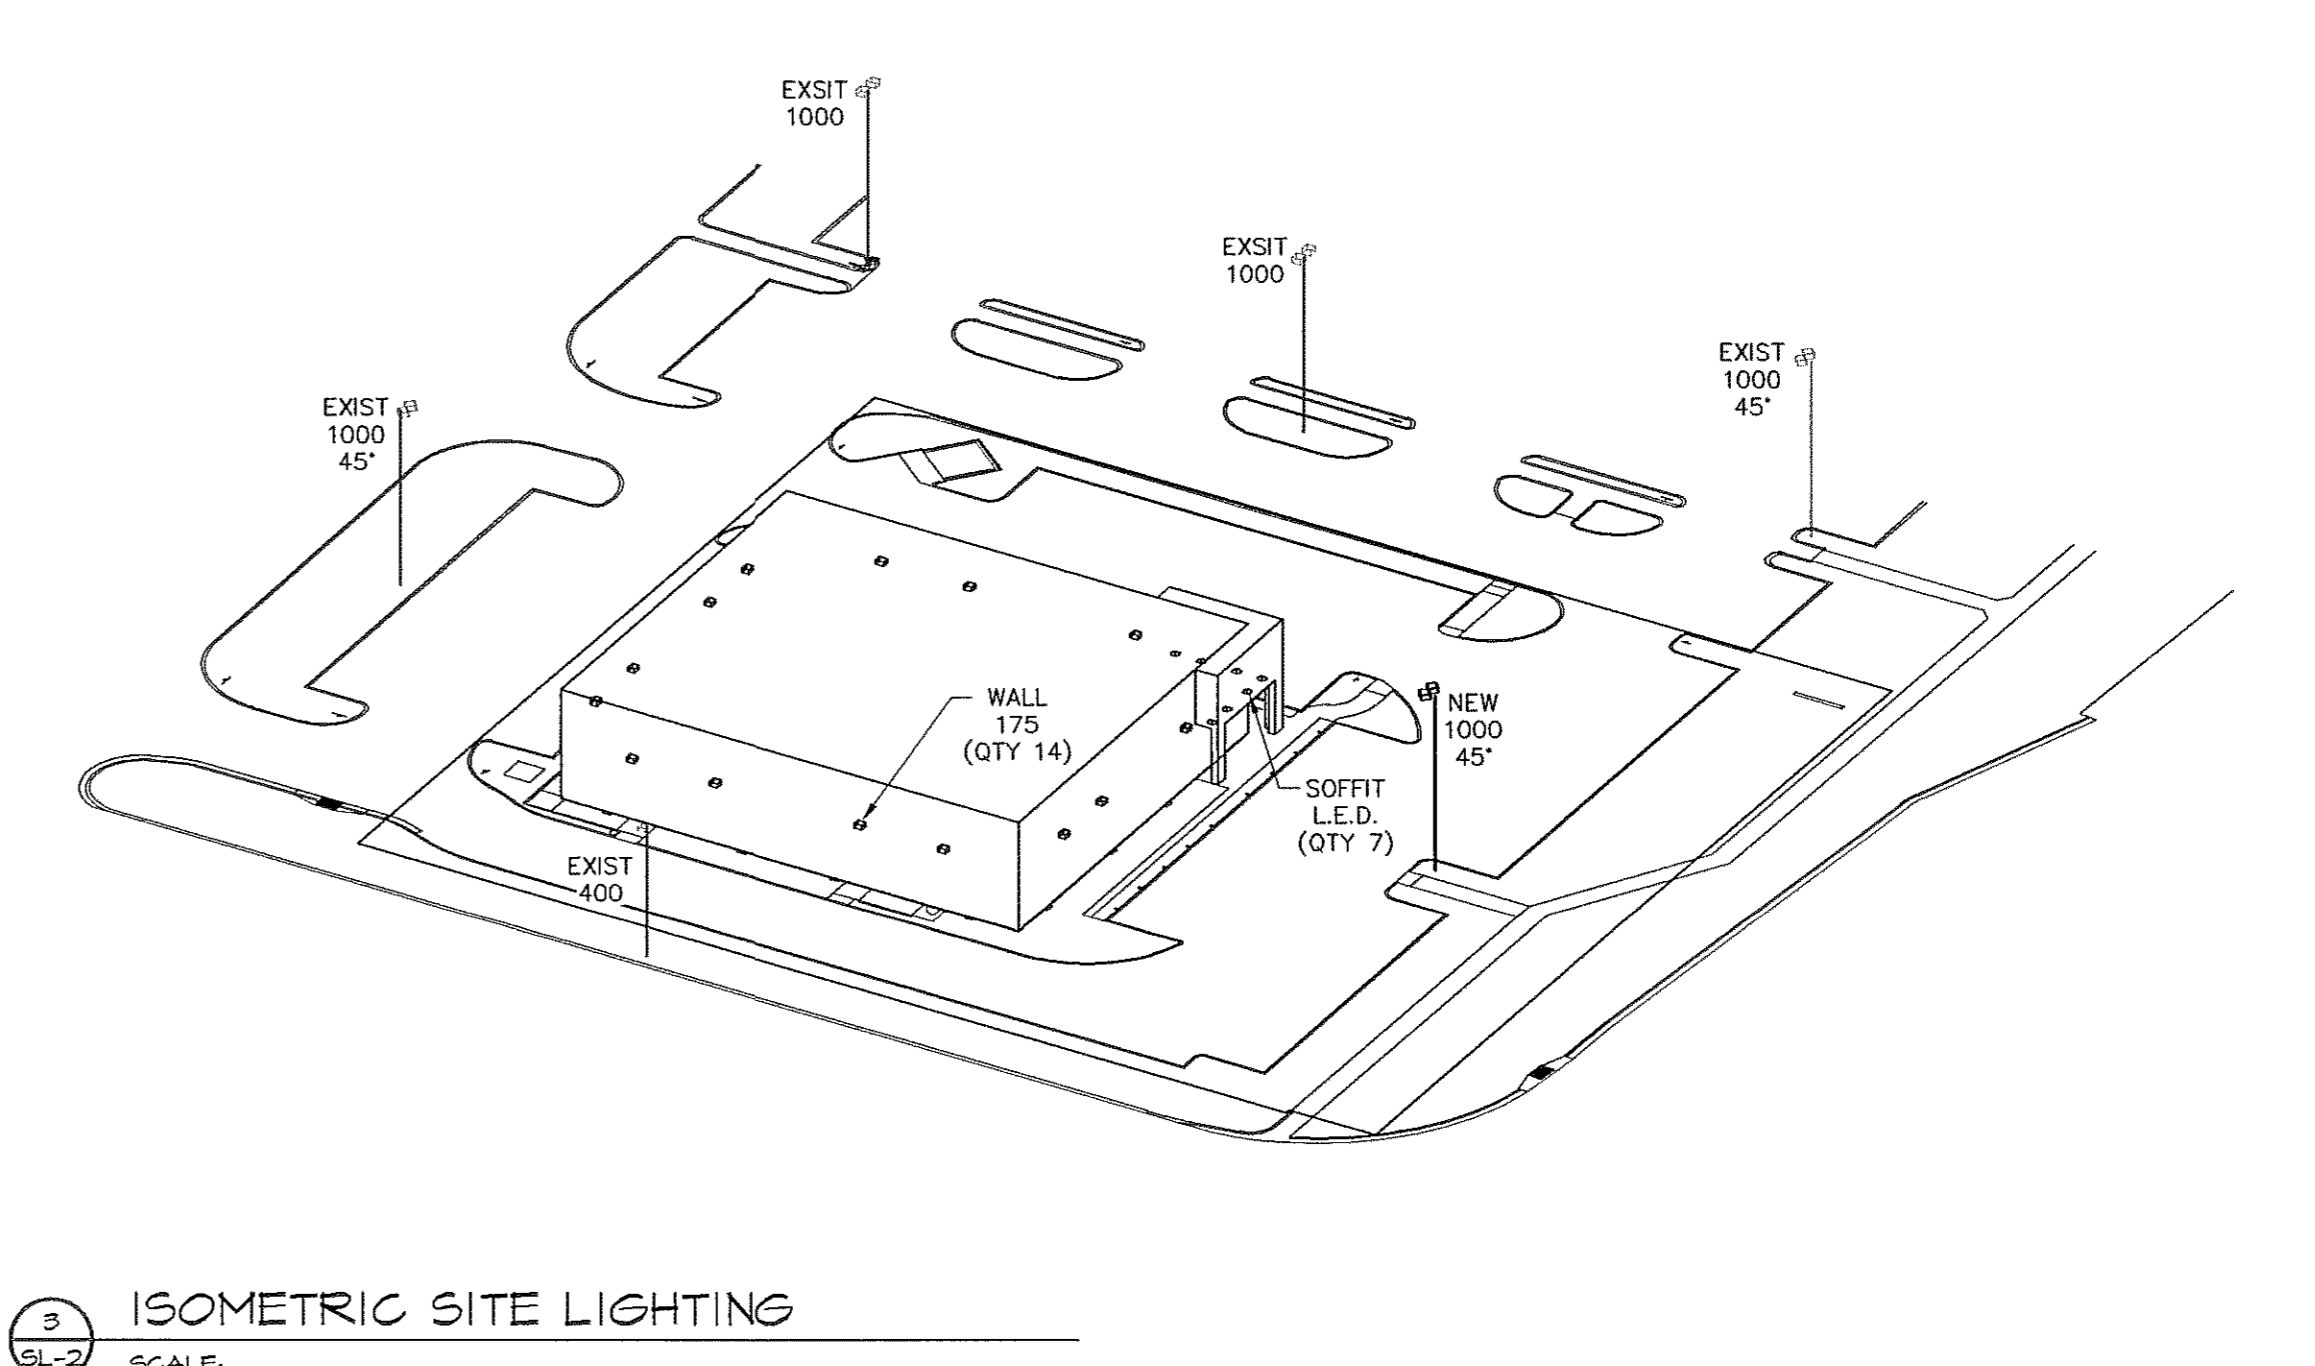

LUMINAIRE SCHEDULE								
SYMBOL	LABEL	QTY	CATALOG NUMBER	DESCRIPTION	LAMP	LUMENS	LLF	NOTES
□	EXIST 400	EXIST	KVS3 400M R3	ARM MNT SQUARE CUTOFF W/ANODIZED ALUMINUM REFL. CLEAR CONVEX GLASS.	ONE 400-WATT CLEAR BT-37 PULSE START METAL HALIDE, HORIZONTAL POSITION.	38000	0.81	EXISTING ALUMINUM LIGHT POLE LIGHT MOUNTED @ 30'-0" AFG
□	EXIST 1000	EXIST	AME-4-T3-1000MH-VLFG	AMERICAN SIZE 4-T3-1000MH-FLAT GLASS-SPECULAR REFLECTOR LUMINAIRE SIZE 23" X 23" X 15"	1000MH VERTICAL BASE UP	110000	0.81	EXISTING 48'-0" PAINTED CONCRETE LIGHT POLE LIGHT MOUNTED @ 40'-0" AFG
◇	EXIST 1000 45'	EXIST	AME-4-T3-1000MH-VLFG	AMERICAN SIZE 4-T3-1000MH-FLAT GLASS-SPECULAR REFLECTOR LUMINAIRE SIZE 23" X 23" X 15"	1000MH VERTICAL BASE UP	110000	0.81	EXISTING 48'-0" PAINTED CONCRETE LIGHT POLE LIGHT MOUNTED @ 40'-0" AFG
◇	NEW 1000 45'	1	AME-4-T3-1000MH-VLFG	AMERICAN SIZE 4-T3-1000MH-FLAT GLASS-SPECULAR REFLECTOR LUMINAIRE SIZE 23" X 23" X 15"	1000MH VERTICAL BASE UP	110000	0.81	NEW 48'-0" CONCRETE LIGHT POLE PAINTED TO MATCH EXISTING LIGHT POLES LIGHT MOUNTED @ 40'-0" AFG
○	SOFFIT L.E.D.	7	A2/B1-05	WITH WHITE TRIM AND RECESSED WHITE PLASTIC LENS	LEDS. LUMEN RATING = 648 LMS.	647	0.95	LIGHT MOUNTED @ 12'-0" AFG @ ENTRANCE SOFFIT
■	WALL 175	14	ASW1 175M SR2 HS (PROBE)	AERIS ARCHITECTURAL BUILDING MOUNTED LUMINAIRE, SR2 DISTRIBUTION WITH HOUSE SIDE SHIELD,	ONE 175-WATT CLEAR ED17 METAL HALIDE, HORIZONTAL POS.	12800	0.81	LIGHT MOUNTED @ 14'-0" AFG UNDER CANVAS CANOPY

STATISTICS						
Description	Symbol	Avg	Max	Min	Max/Min	Avg/Min
Landscape Zone	□	5.6 fc	16.2 fc	0.5 fc	32.4:1	11.2:1
Outside Lot	X	5.0 fc	10.8 fc	0.5 fc	21.6:1	10.0:1
Parking Zone	X	5.8 fc	12.6 fc	1.8 fc	7.0:1	3.2:1

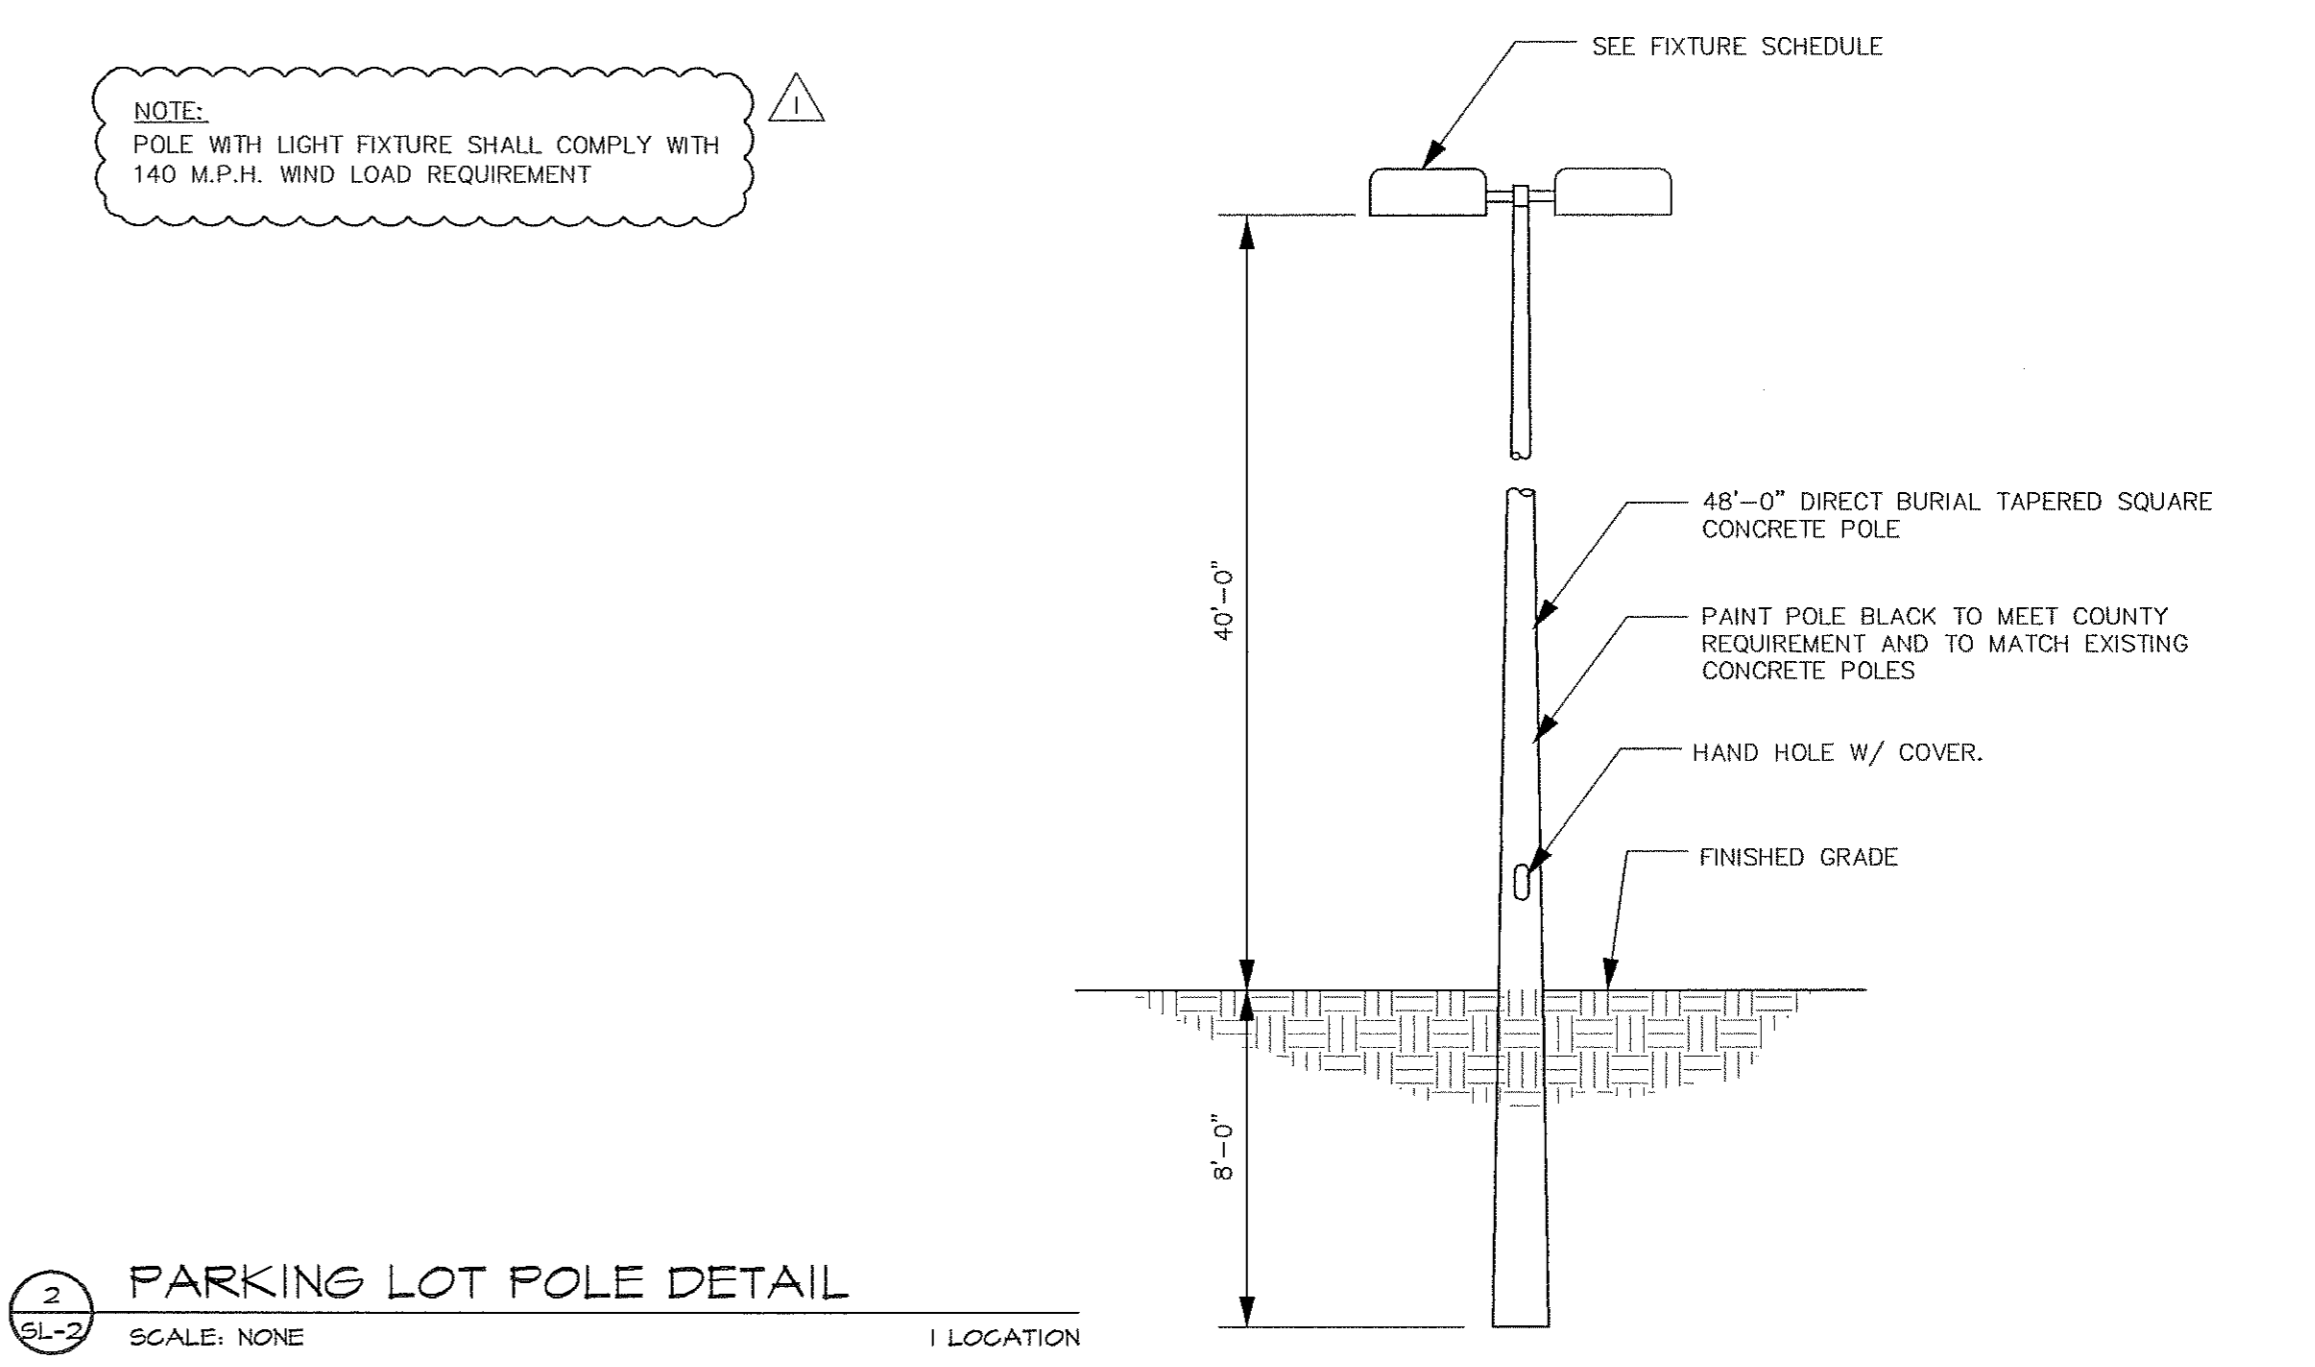

REVISIONS		BY
BUILDING DEPT REVISION 1-26-09		MCM

*Signature*  
1-28-09

**ABC LIQUORS, INC.**  
8989 S. ORANGE AVE. - ORLANDO, FLA. 32809

**ABC STORE NO. 43**  
VERO BEACH CENTURY TOWN CENTER

SITE PHOTOMETRICS PLAN

DRAWN: M. MAISCO  
CHECKED: S. RIVERA  
DATE: 5-15-09  
SCALE: AS NOTED  
JOB No: 43  
SHEET

SL-2