
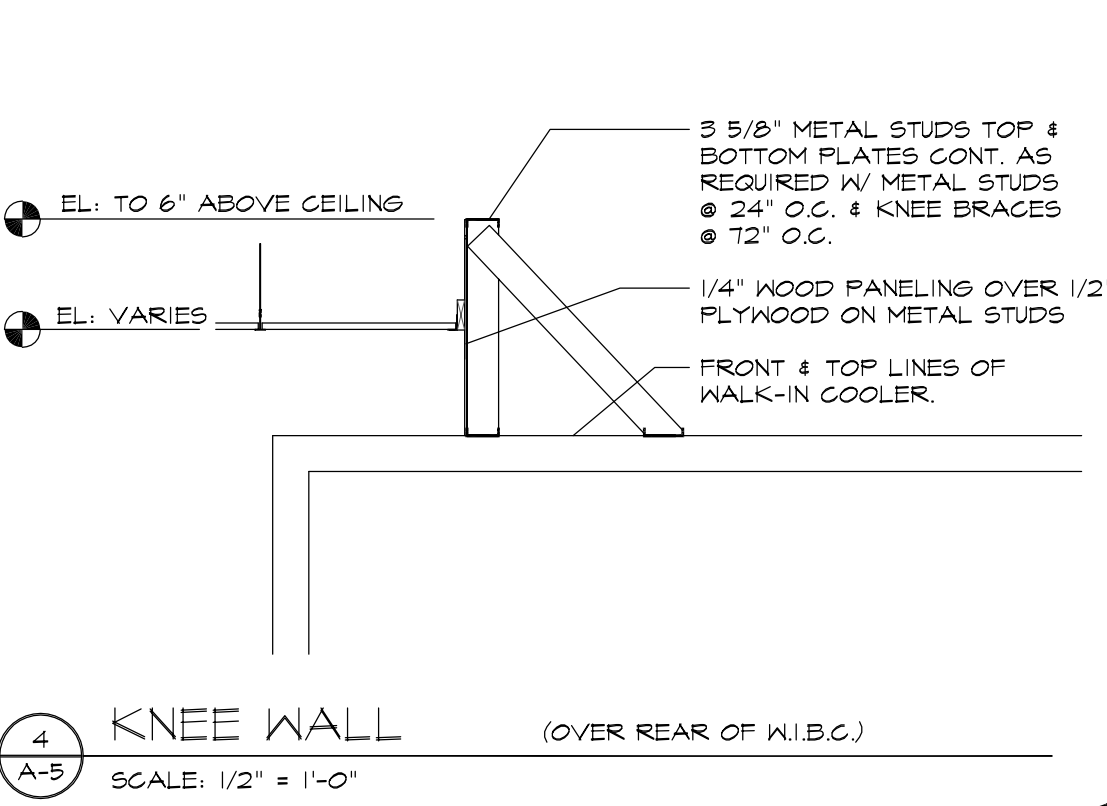
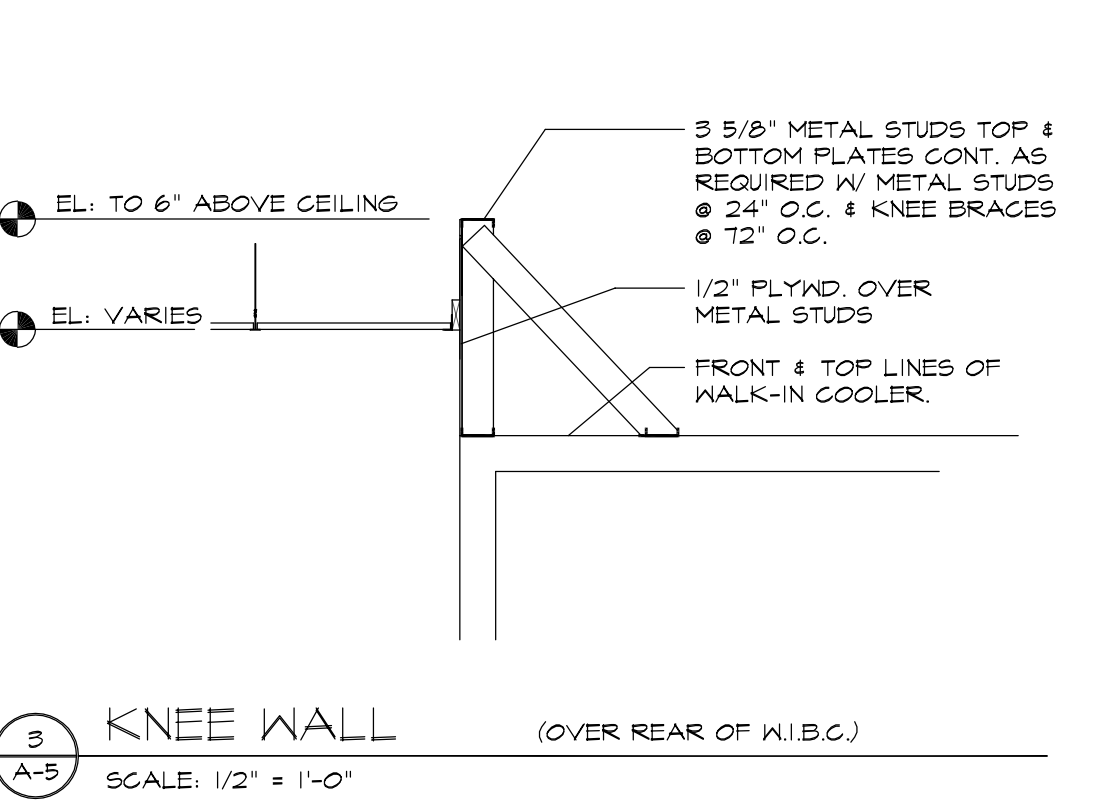


1 REFLECTED CEILING PLAN
SCALE: 1/8" = 1'-0"

LEGEND:

	24"x24" SUPPLY DIFFUSER. SEE MECH. DWG'S. FOR SPEC.		1"x8" SURFACE MTD. LIGHT FIXTURE SEE ELECT. DWG'S. FOR SPEC.
	24"x24" RETURN REGISTER. SEE MECH. DWG'S. FOR SPEC.		24"x48" CEILING TILE GRID
	12"x12" SUPPLY DIFFUSER. SEE MECH. DWG'S. FOR SPEC.		EXIT/EMERGENCY LIGHT COMBO. SEE ELECT. DWG'S. FOR SPEC.
	12"x12" RETURN REGISTER. SEE MECH. DWG'S. FOR SPEC.		EMERGENCY LIGHT. SEE ELECT. DWG'S. FOR SPEC.
	EXHAUST GRILLE. SEE MECH. DWG'S. FOR SPEC.		PADDLE FAN. SEE ELECT. DWG'S. FOR SPEC.
	2"x4" RECESSED LIGHT FIXTURE. SEE ELECT. DWG'S. FOR SPEC.		TRACK LIGHTING. SEE ELECT. DWG'S. FOR SPEC.
	2"x2" RECESSED LIGHT FIXTURE. SEE ELECT. DWG'S. FOR SPEC.		8"x4" EGG CRATE GRILL, ALUMINUM CONST. 1/2"x1/2"x1/2". MANUF. BY TITUS OR EQUAL. REFER TO MECH. PLAN FOR ADDITIONAL INFORMATION.
	AUDIO SPEAKER. SEE ELECT. DWG'S. FOR SPEC.		
	1"x4" SURFACE MTD. LIGHT FIXTURE SEE ELECT. DWG'S. FOR SPEC.		

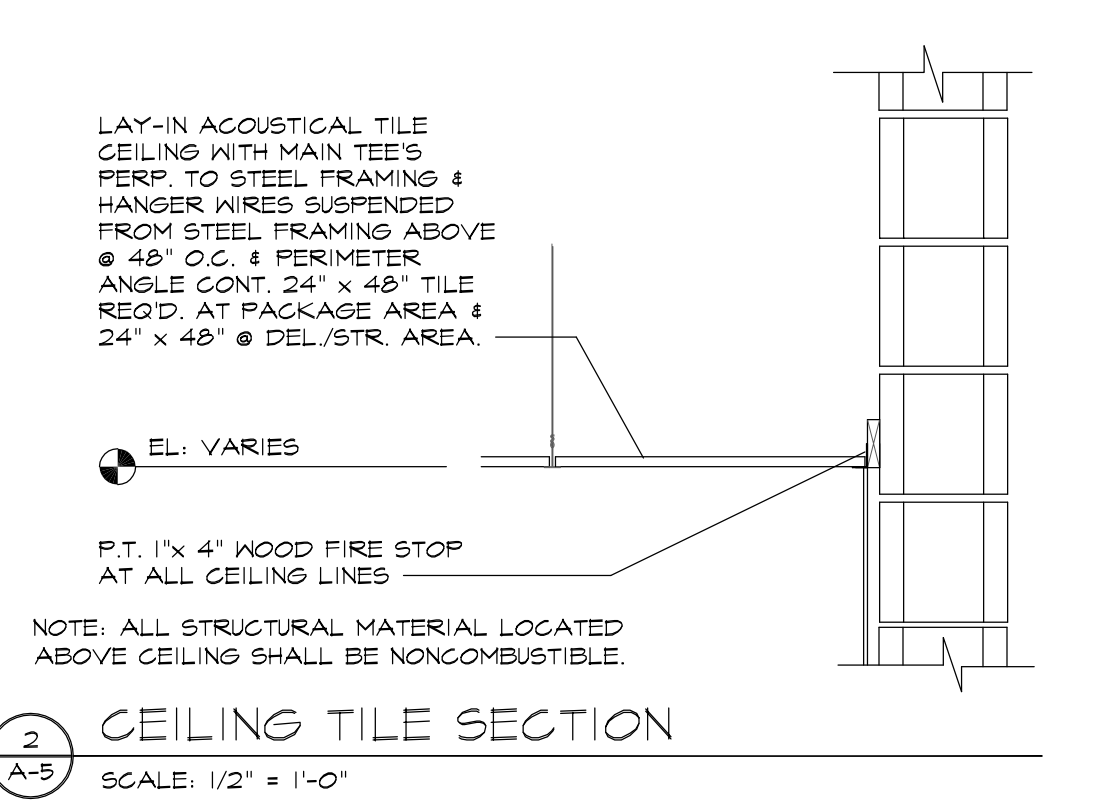

NOTE: REFER TO ELEC./LIGHTING PLAN FOR EXIT, EMERGENCY, AND NIGHT LIGHTING LOCATIONS.

REVISIONS	BY
OWNER REVISION 5-14-06	MCM

ARTERBURY ARCHITECTS, INC.
A A 26000718

2400 SAND LAKE ROAD
LONGWOOD, FLORIDA 32779

(407) 774-2233
FAX (407) 774-7377

ABC LIQUORS, INC.
8989 S. ORANGE AVE. - ORLANDO, FLA. 32809

ABC STORE NO. 50
SAWGRASS MILLS, SUNRISE, FLORIDA

REFLECTED CEILING PLAN

DRAWN: R. CARDONA
CHECKED: S. RIVERA
DATE: 5-1-07
SCALE: AS NOTED
JOB No: 50
SHEET

A-5