


# CODE SUMMARY

<b>APPLICABLE CODES</b>		<b>ABC PACKAGE STORE</b>		<b>TENANT SPACE #1</b>	
FLORIDA STATUTES Edition : CURRENT		<b>CONSTRUCTION</b>		<b>CONSTRUCTION</b>	
Building : FLORIDA BUILDING CODE Edition : 2004 W/2006 SUPPLEMENTS		1ST FLOOR GROSS AREA : 15,082 SQ. FT.		1ST FLOOR GROSS AREA : 3,402 SQ. FT.	
Mechanical : FLORIDA MECHANICAL CODE Edition : 2004 W/2006 SUPPLEMENTS		<b>EXITS PER FLOOR</b>		<b>EXITS PER FLOOR</b>	
Plumbing : FLORIDA PLUMBING CODE Edition : 2004 W/2006 SUPPLEMENTS		Number of Exits : 4		Number of Exits : 3	
Electrical : NATIONAL ELECTRICAL CODE Edition : 2002		<b>OCCUPANCY (PROJECT AREA)</b>		<b>OCCUPANCY (PROJECT AREA)</b>	
A.D.A. : FLORIDA ACCESSIBILITY CODE Edition : 2004 W/2006 SUPPLEMENTS		Occupancy(s)/Group Classification : GROUP M / Mercantile		Occupancy(s)/Group Classification : GROUP M / Mercantile	
Life Safety : FLORIDA FIRE PROTECTION CODE Edition : 2004 W/2006 SUPPLEMENTS		Public Area : 30 GROSS		Public Area : 30 GROSS	
		Non Public Area : 300 GROSS		Gross Floor Area : 3,402 SQ. FT. 114 PEOPLE	
<b>CONSTRUCTION</b>		Public Area : 12,230 SQ. FT. 408 PEOPLE			
Construction TYPE : TYPE V		Non Public Area : 2,852 SQ. FT. 10 PEOPLE			
Protected or Unprotected : UNPROTECTED		TOTAL 418 PEOPLE			
Sprinklered or Non-sprinklered : SPRINKLED		<b>PLUMBING FIXTURES</b>			
Max. Building Height : 55 FEET		Male : W.C. 1 Lav. 1			
Actual Building Height : 22'-10"		Female : W.C. 1 Lav. 1			
1ST FLOOR GROSS AREA : 18,484 S.F. TOTAL		Hand Sink 1 Drinking Fountain(s): 2			
		Utility Sink 1 3 COMP. SINK 1			
<b>TOTAL: EXITS PER FLOOR</b>					
Number of Exits : 5 TOTAL					
Maximum Travel Distance : 200 FT.					
Maximum Dead End Hall : 50 FT.					
Min. Corridor / Isle Width : 44 IN.					
Min. CLEAR OPEN'G. OF EXIT DOORS : 32 IN.					

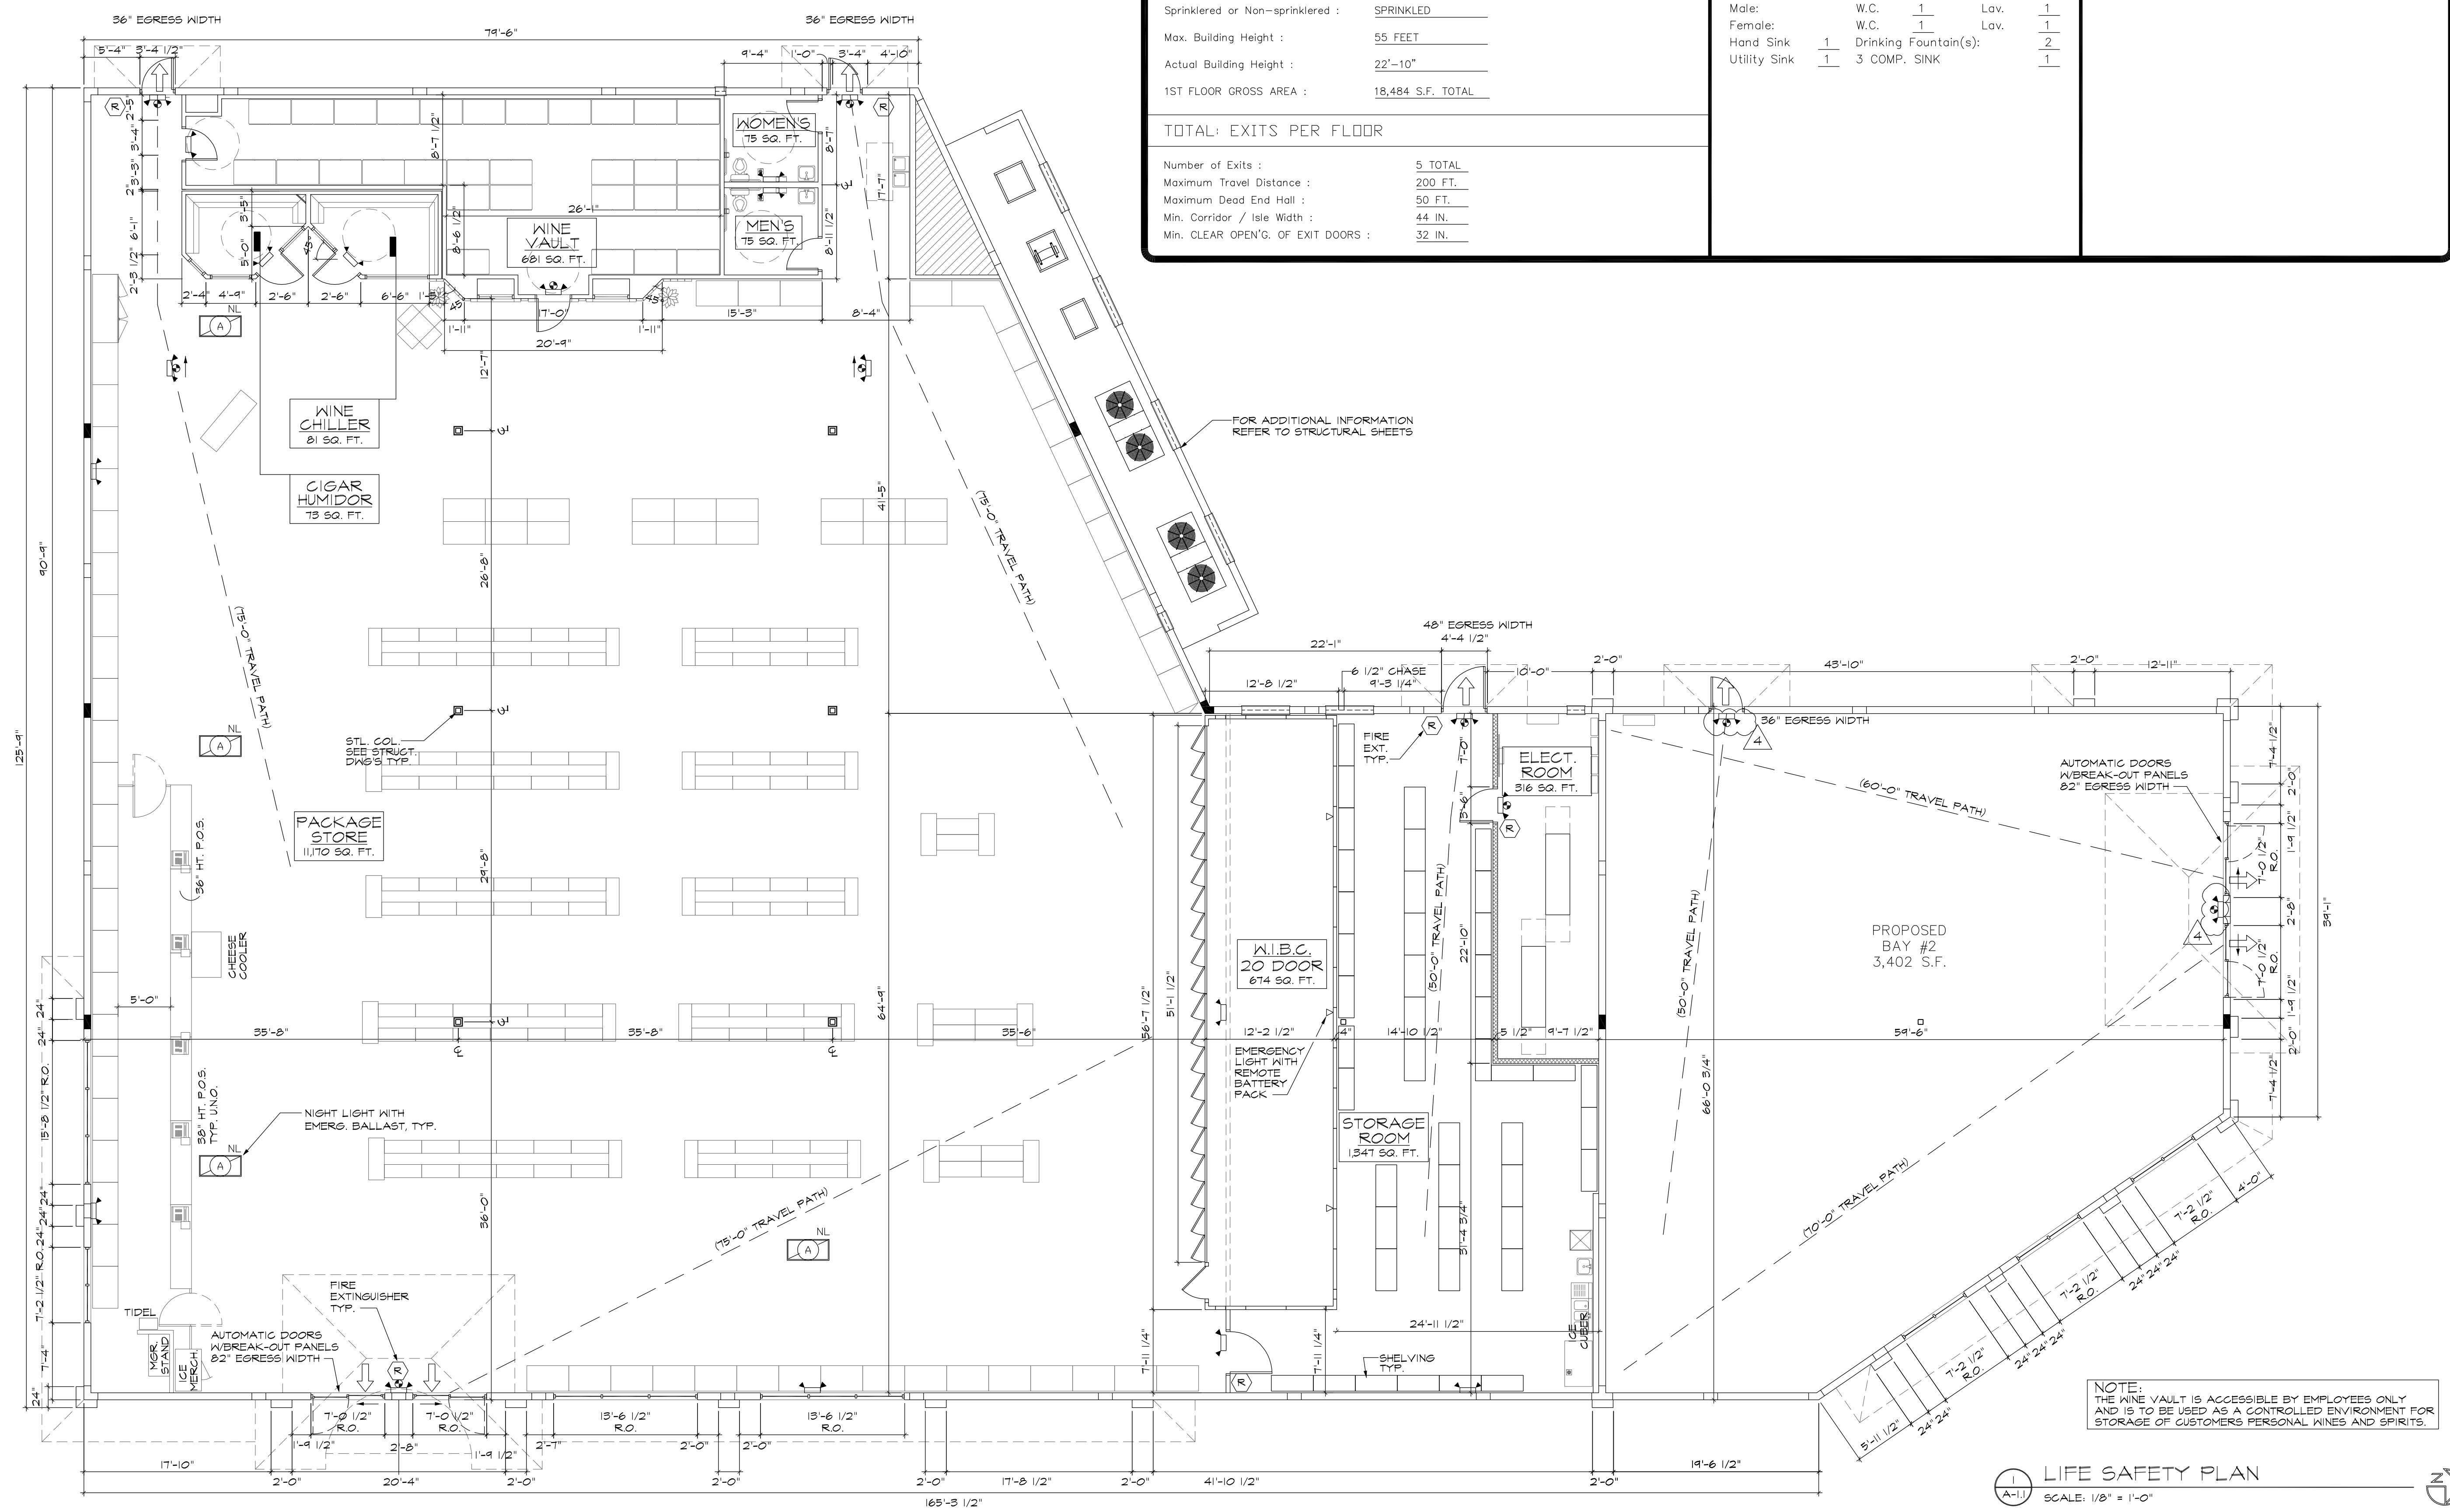

LIFE SAFETY PLAN  
SCALE: 1/8" = 1'-0"

REVISIONS	BY
BUILDING DEPT. REV. 5-14-08	MCM
BUILDING DEPT. REV. 7-17-08	S.L.M.
BUILDING DEPT. REV. 8-2-08	S.L.M.

**ARTERBURY ARCHITECTS, INC.**  
A A 26000718

2400 SAND LAKE ROAD  
LONGWOOD, FLORIDA 32779

(407) 774-2233  
FAX (407) 774-7377

**ABC LIQUORS, INC.**  
8989 S. ORANGE AVE. - ORLANDO, FLA. 32809

**ABC STORE NO. 50**  
SAWGRASS MILLS, SUNRISE, FLORIDA

DRAWN:	R. CARDONA
CHECKED:	S. RIVERA
DATE:	5-1-07
SCALE:	AS NOTED
JOB No:	50
SHEET	