


1 REFLECTED CEILING PLAN
A-3 SCALE: 1/8" = 1'-0"

LEGEND:

- ☒ 24"x24" SUPPLY DIFFUSER. SEE MECH. DWG'S. FOR SPEC.
 - ☒ 24"x24" RETURN REGISTER. SEE MECH. DWG'S. FOR SPEC.
 - ☒ 12"x12" SUPPLY DIFFUSER. SEE MECH. DWG'S. FOR SPEC.
 - ☒ 12"x12" RETURN REGISTER. SEE MECH. DWG'S. FOR SPEC.
 - ☒ EXHAUST GRILLE. SEE MECH. DWG'S. FOR SPEC.
 - ☐ 2'x4' RECESSED LIGHT FIXTURE. SEE ELECT. DWG'S. FOR SPEC.
 - ☐ 2'x2' RECESSED LIGHT FIXTURE. SEE ELECT. DWG'S. FOR SPEC.
 - ☐ 1'x4' SURFACE MTD. LIGHT FIXTURE SEE ELECT. DWG'S. FOR SPEC.
- ▢ 24"x48" CEILING TILE GRID
 - ☉ EXIT/EMERGENCY LIGHT COMBO. SEE ELECT. DWG'S. FOR SPEC.
 - ☉ EMERGENCY LIGHT. SEE ELECT. DWG'S. FOR SPEC.

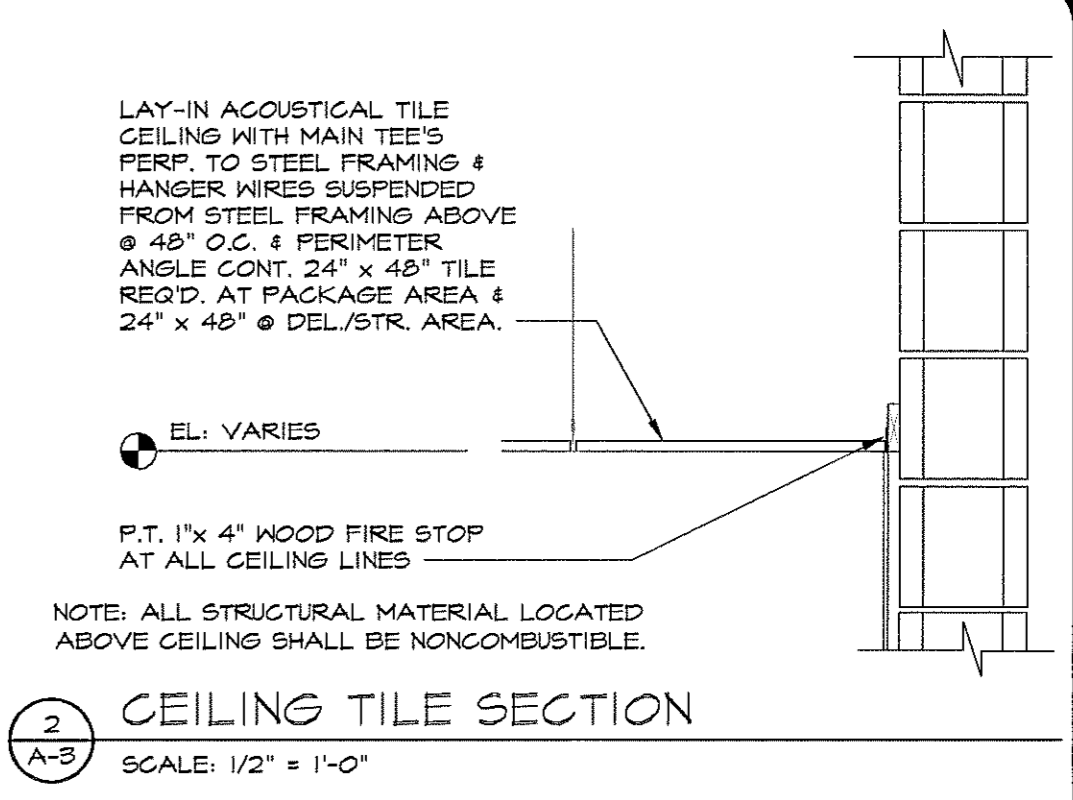

2 CEILING TILE SECTION
A-3 SCALE: 1/2" = 1'-0"

REVISIONS	BY

ARTERBURY ARCHITECTS, INC.
A A 26000718

2400 SAND LAKE ROAD
LONGWOOD, FLORIDA 32779

(407) 774-2838
FAX (407) 774-7877

[Signature]
10-6-09

ABC LIQUORS, INC.
8989 S. ORANGE AVE. - ORLANDO, FLA. 32809

ABC STORE NO. 50 TENANT
2613 N.W. 124TH AVE. SUNRISE, FL. 33233

DRAWN:	S.R.R.
CHECKED:	S. RIVERA
DATE:	9-29-09
SCALE:	AS NOTED
JOB No:	50 TENANT
SHEET	

A-3

TENANT REFLECTED CEILING PLAN