

CODE SUMMARY

APPLICABLE CODES

Building : FLORIDA BUILDING CODE Edition : 2007 w/ 2009 SUPPLEMENTS
 Mechanical : FLORIDA MECHANICAL CODE Edition : 2007 w/ 2009 SUPPLEMENTS
 Plumbing : FLORIDA PLUMBING CODE Edition : 2007 w/ 2009 SUPPLEMENTS
 Electrical : NATIONAL ELECTRICAL CODE Edition : 2005
 A.D.A. : FLORIDA ACCESSIBILITY CODE Edition : 2007 w/ 2009 SUPPLEMENTS
 Life Safety : FLORIDA FIRE PREVENTION CODE Edition : 2007

CONSTRUCTION

Construction TYPE : TYPE V
 Protected or Unprotected : UNPROTECTED
 Sprinklered or Non-sprinklered : SPRINKLED
 Max. Building Height : 55 FEET
 Actual Building Height : 22'-10"
 1ST FLOOR GROSS AREA : 18,484 S.F. TOTAL BUILDING

TOTAL: EXITS PER FLOOR

Number of Exits : 3 TOTAL
 Maximum Travel Distance : 200 FT.
 Maximum Dead End Hall : 50 FT.
 Min. Corridor / Isle Width : 44 IN.
 Min. CLEAR OPEN'G. OF EXIT DOORS : 32 IN.

TENANT SPACE #1

CONSTRUCTION

1ST FLOOR GROSS AREA : 3,424 SQ. FT.

EXITS PER FLOOR


Number of Exits : 3

OCCUPANCY (PROJECT AREA)

Occupancy(s)/Group Classification : GROUP M / Mercantile
 Public Area : 30 GROSS
 Gross Floor Area : 3,402 SQ. FT. 114 PEOPLE

PLUMBING FIXTURES

Male: W.C. 1 Lav. 1
 Female: W.C. 1 Lav. 1
 Drinking Fountain(s): 2

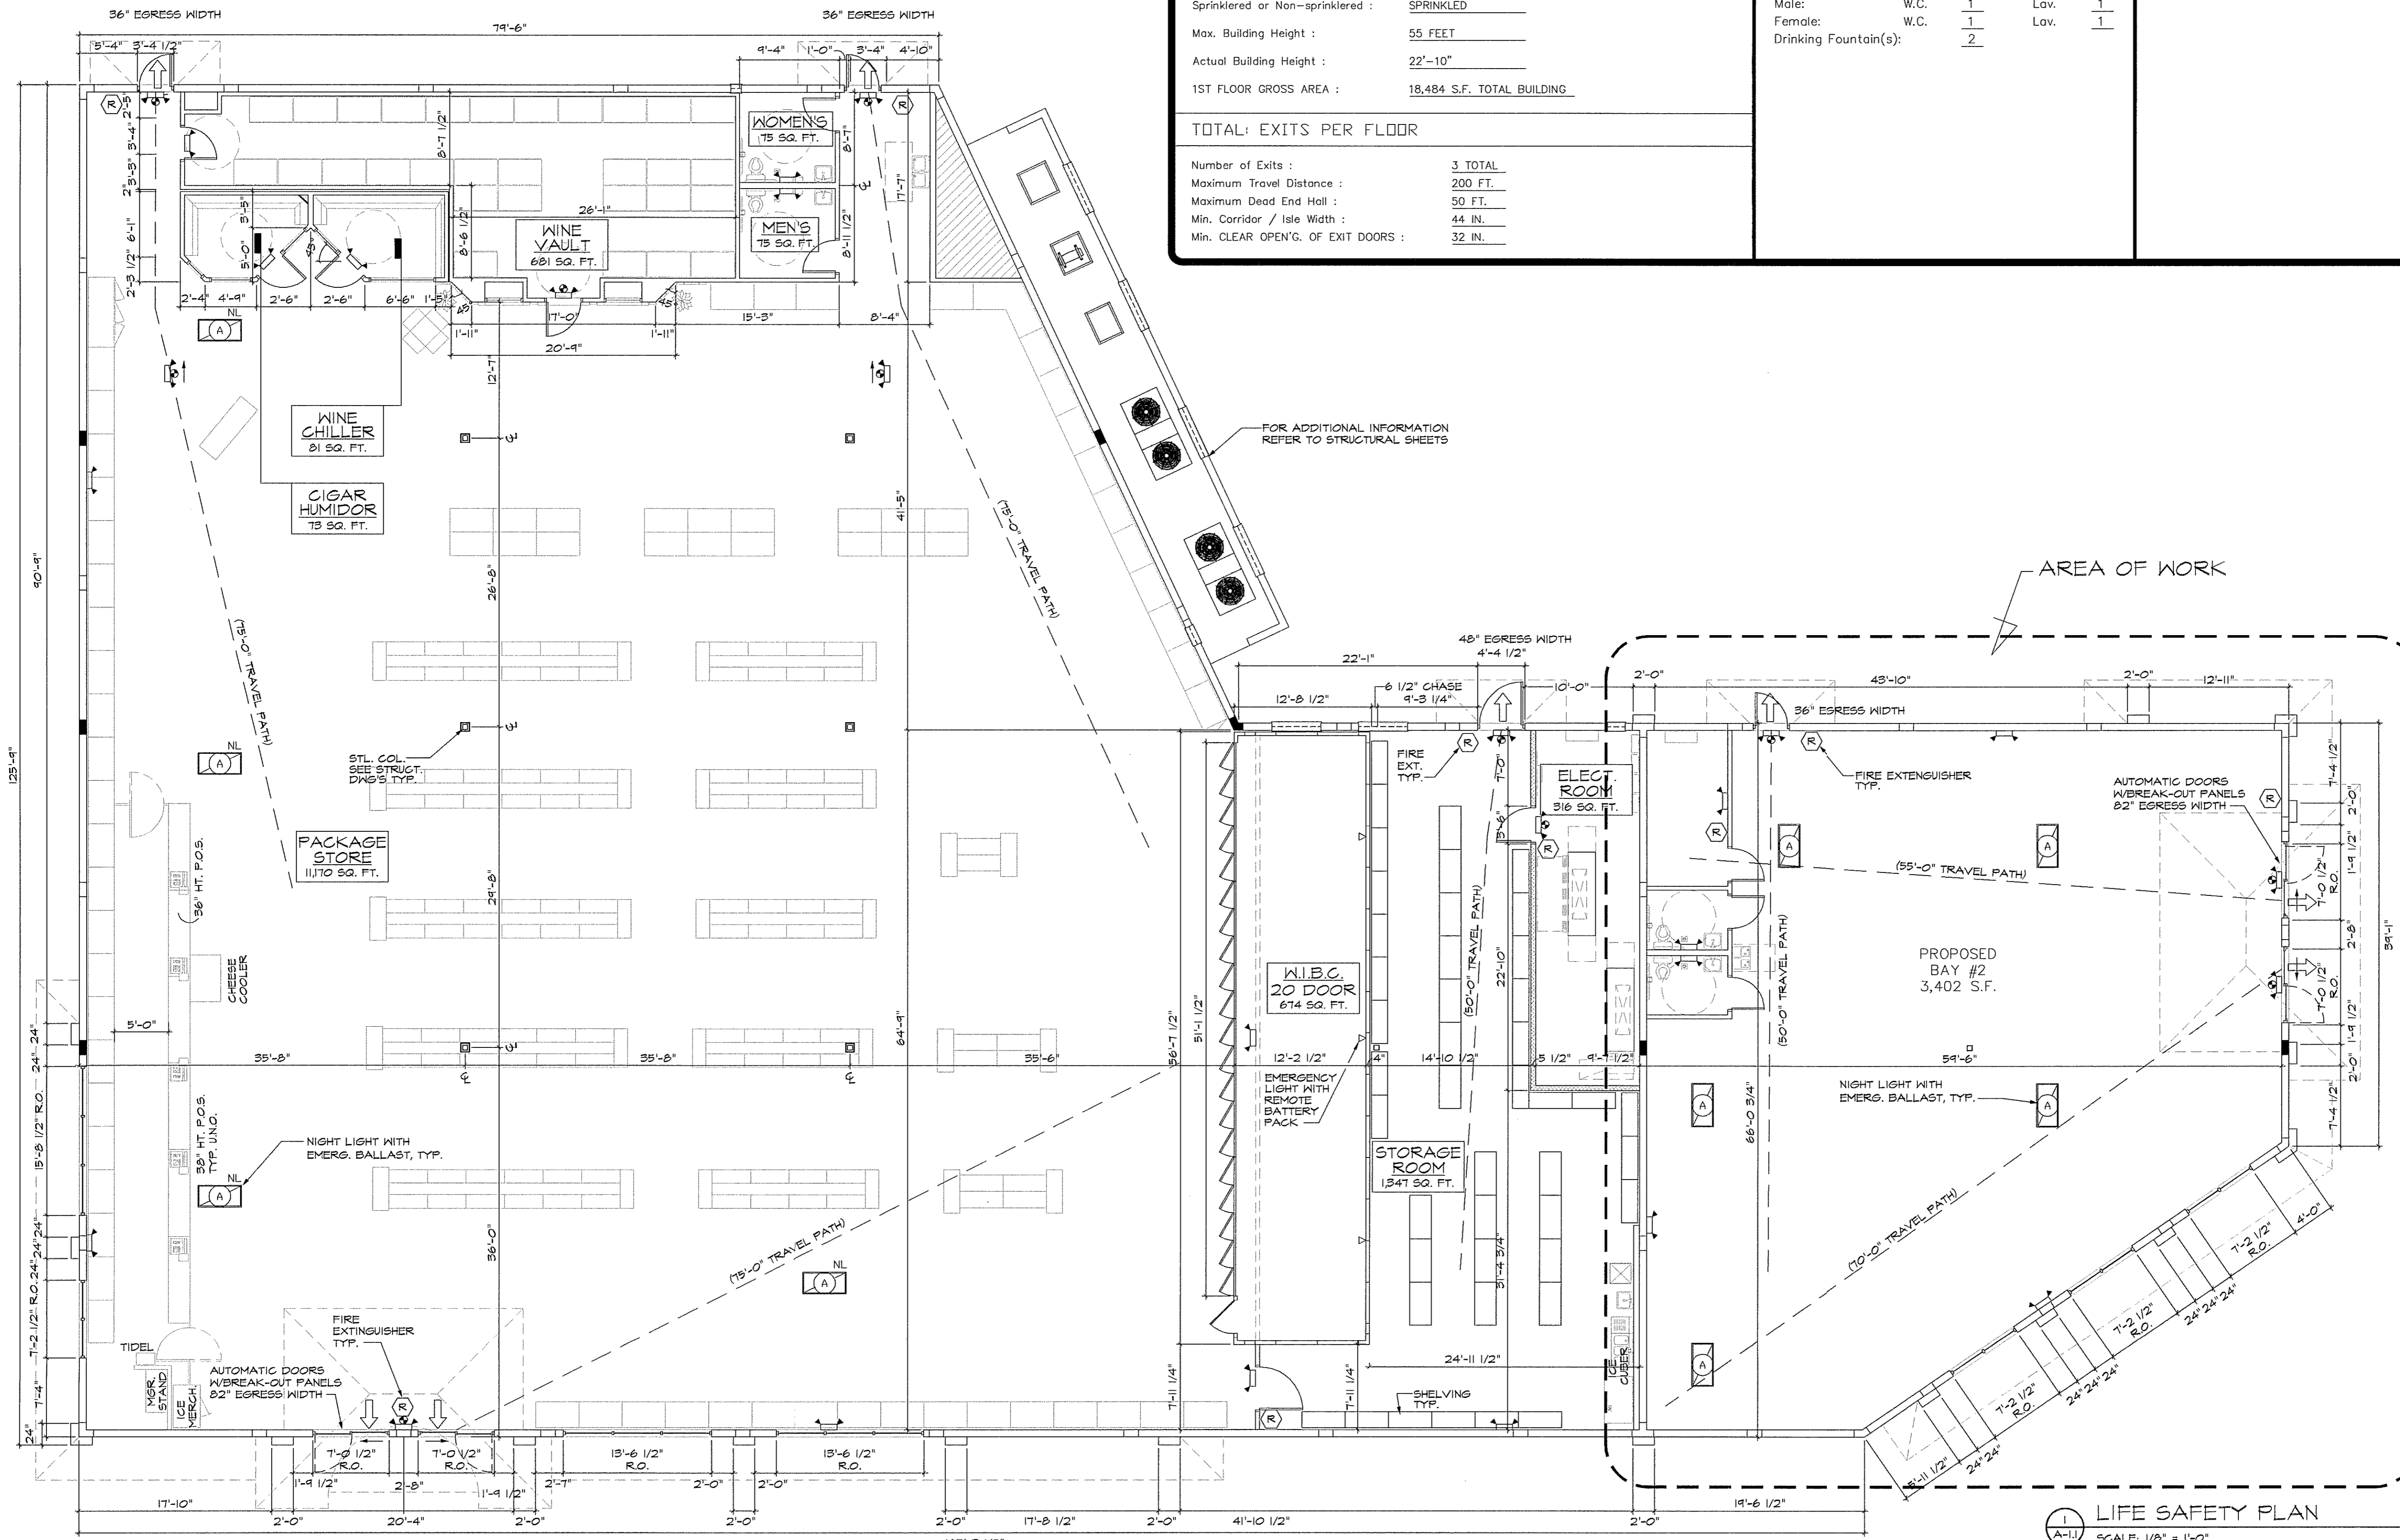

FOR ADDITIONAL INFORMATION REFER TO STRUCTURAL SHEETS

AREA OF WORK

LIFE SAFETY PLAN
 SCALE: 1/8" = 1'-0"

REVISIONS	BY

ARTERBURY ARCHITECTS, INC.
 AA 26000718
 2400 SAND LAKE ROAD
 LONGWOOD, FLORIDA 32779
 (407) 774-2838
 FAX (407) 774-7877

Handwritten signature and date: 10-6-09

ABC LIQUORS, INC.
 8989 S. ORANGE AVE. - ORLANDO, FLA. 32809
ABC STORE NO. 50 TENANT
 2613 N.W. 124TH AVE. SUNRISE, FL. 33233

LIFE SAFETY PLAN

DRAWN: S.R.R.
 CHECKED: S. RIVERA
 DATE: 9-29-09
 SCALE: AS NOTED
 JOB No: 50 TENANT
 SHEET

A=|||