


LUMINAIRE SCHEDULE								
SYMBOL	LABEL	QTY	CATALOG NUMBER	DESCRIPTION	LAMP	LUMENS	LLF	NOTES
	KVF	6	KVF 400M SR4SCFL	SQUARE AREA LIGHT, SR4SC DISTRIBUTION, FLAT LENS, MEETS 'NIGHTTIME FRIENDLY' CRITERIA	ONE 400-WATT CLEAR ED-28 METAL HALIDE, HORIZONTAL POSITION.	32000	0.91	LIGHT AND POLE TO MATCH EXISTING SITE LIGHTING FINISH. PROVIDE W/ HOUSE SIDE SHIELD. TO MINIMIZE OVERFLOW OF LIGHT AT PROPERTY LINES
	EXIST KVF	EXIST	KVF 400M	SQUARE AREA LIGHT	ONE 400-WATT METAL HALIDE			

REVISIONS BY		
BUILDING DEPT	REVISION	MCM
	12/1/04	


ARTERBURY ARCHITECTS, INC.
A A C - 0 0 1 7 7 7

1009 MAITLAND CENTER COMMONS BLVD
SUITE 216
MAITLAND, FLORIDA 32751

(407) 774-2233
FAX (407) 774-7377

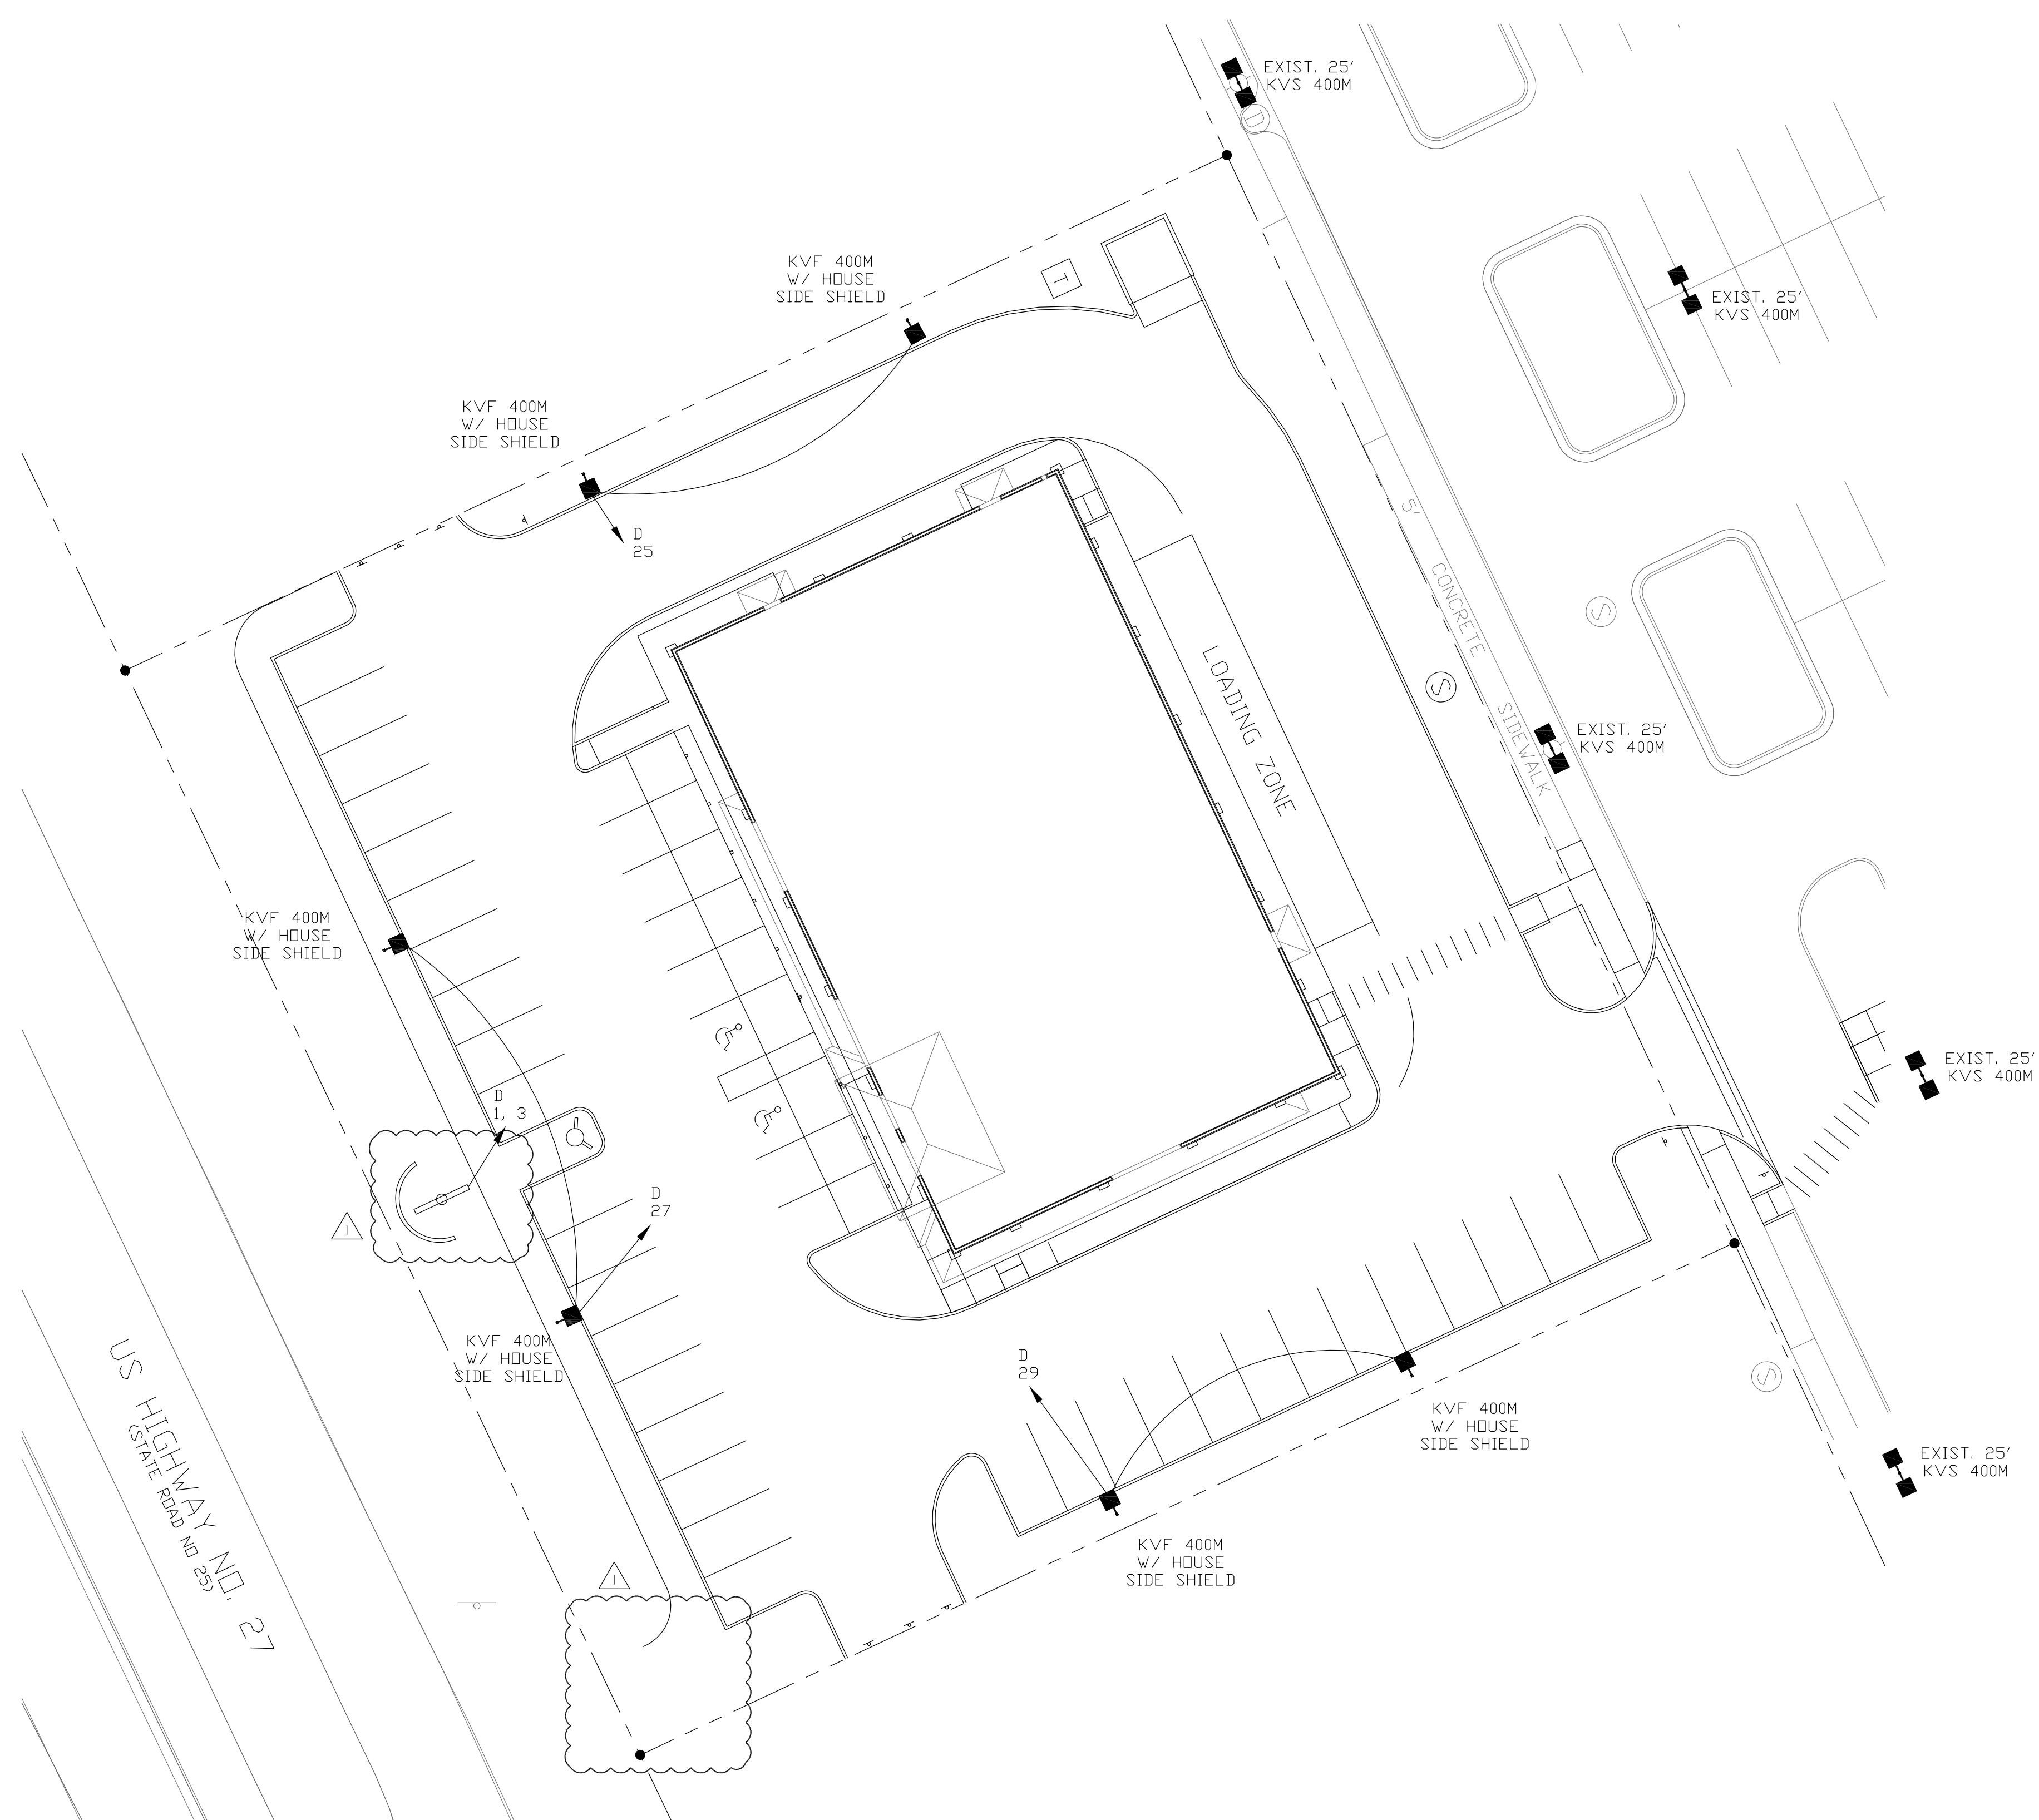


LITHONIA LIGHTING
Architectural Vertical Cutoff
KVF

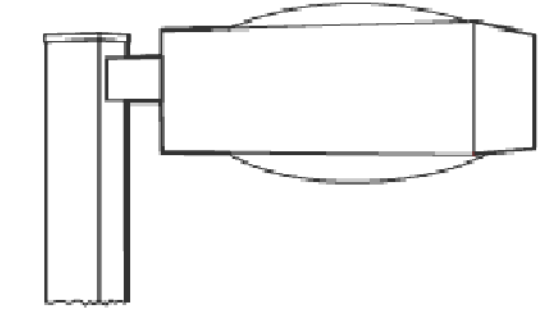

Dimensions are shown in inches (centimeters) unless otherwise noted.

EPA: 2.8ft² (.25m²)
Square: 21-1/2(54.6)
Height: 17(43.2)
Max. weight: 53 lbs (24 kg)

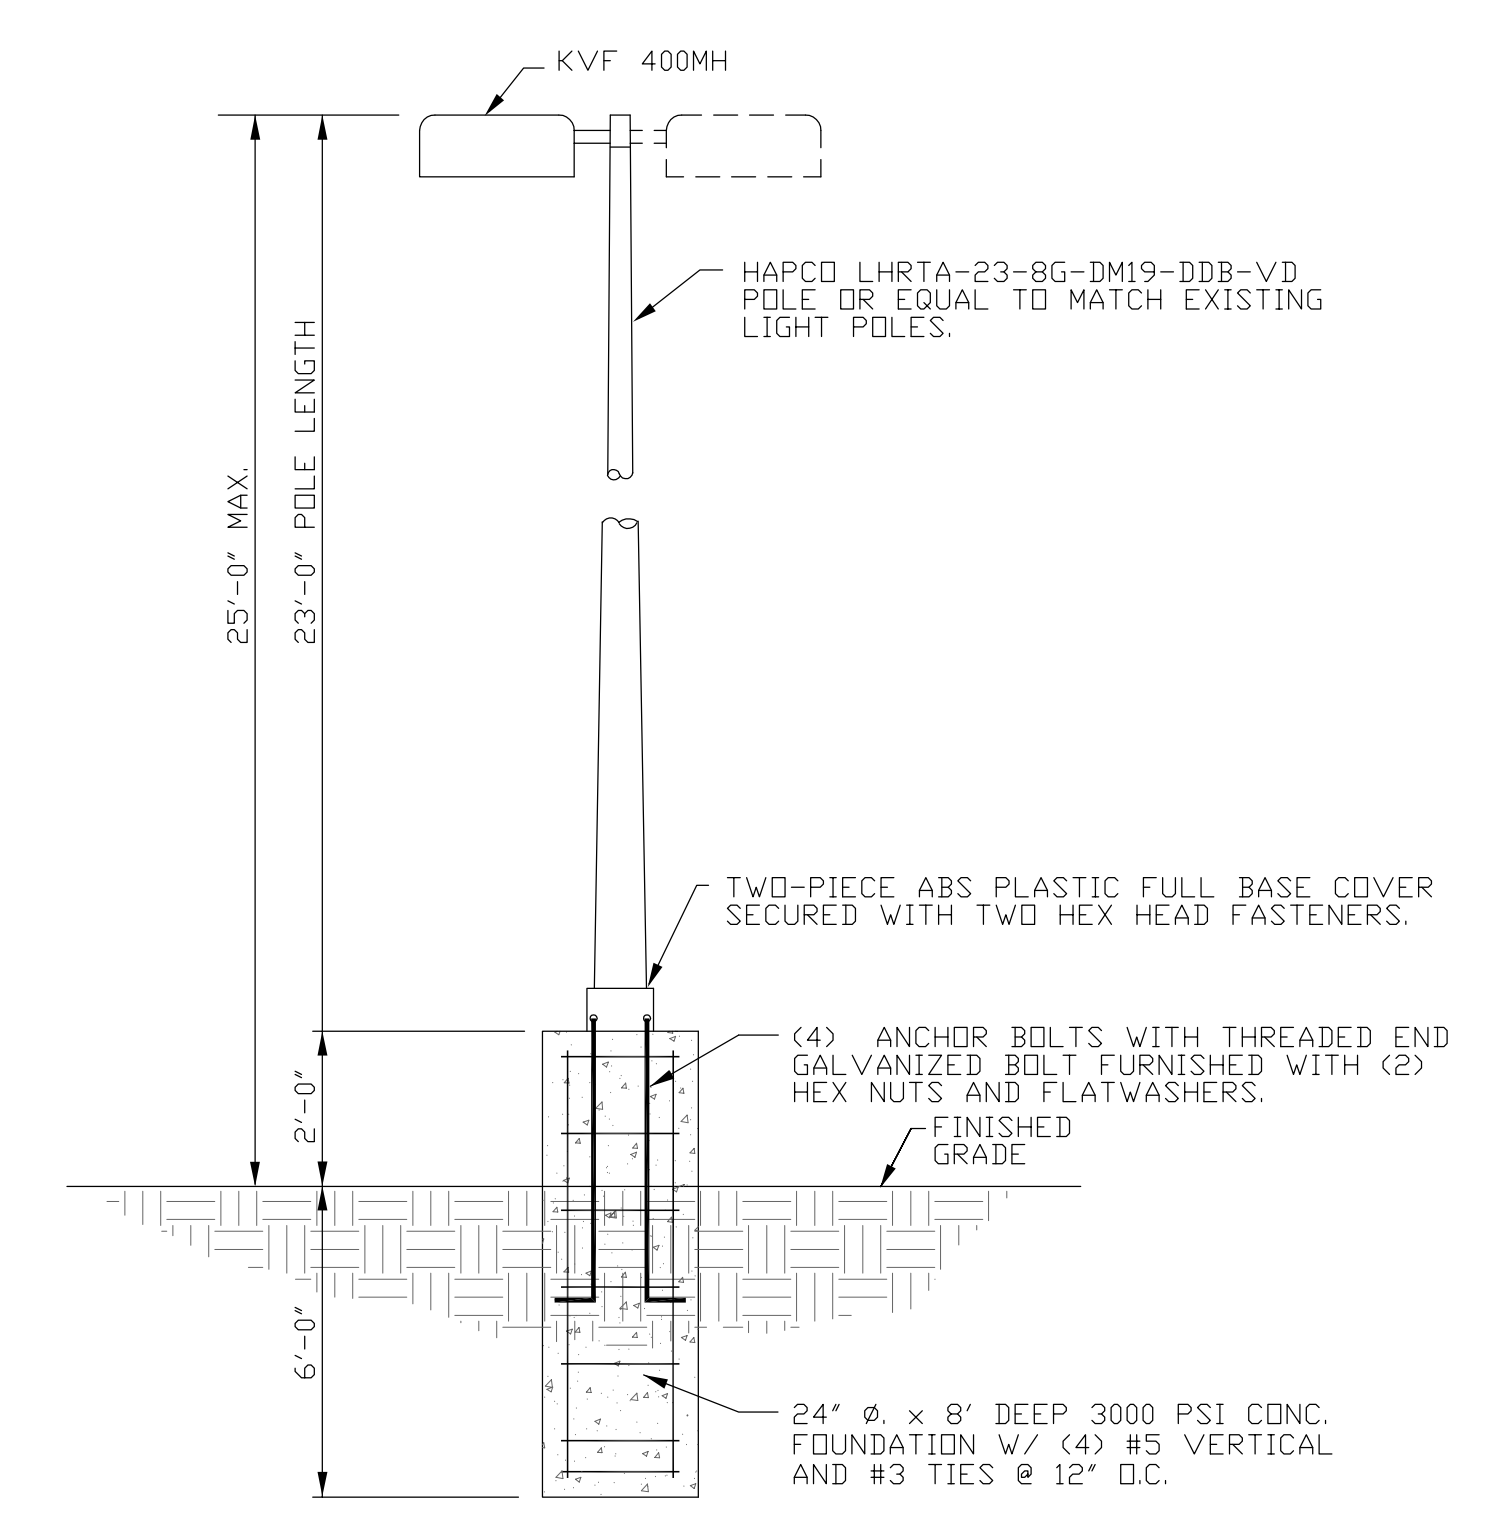

NOTE:
POLE WITH LIGHT FIXTURE SHALL COMPLY WITH 110 M.P.H. WIND LOAD REQUIREMENT


PARKING LOT POLE DETAIL 6 REQUIRED

SITE LIGHTING PLAN
SCALE: 1" = 20'-0"

ABC LIQUORS, INC.
8889 S. ORANGE AVE. - ORLANDO, FLA. 32809

ABC STORE NO. 59 B
LAKE WALES, FLORIDA

DRAWN:	M. MAISCO
CHECKED:	S. RIVERA
DATE:	7-2-04
SCALE:	AS NOTED
JOB No:	59 B
SHEET	

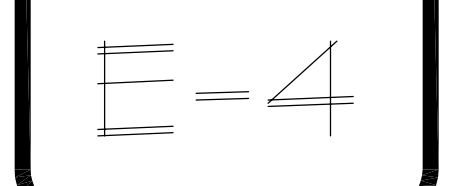

SITE LIGHTING PLAN