



**J. HOWARD
NUDELL
ARCHITECT**

31690 W. Twelve Mile Road
Farmington Hills, Michigan 48334
t 248 324 8800 f 248 324 5550
OFFICES IN

Dallas Texas
972 387 5900

Costa Mesa, California
714 979 8100

Chicago, Illinois
321 558 1144

Tempe, Arizona
480 446 3300

RBE
CONSULTING SERVICES, LLC

2000 W. WINDYBROOK DRIVE
SUITE 100 WINDYBROOK, ILL. 60090-1000
TEL: 312.291.1000 FAX: 312.291.1001
WWW.RBECONSULTING.COM
REGISTERED PROFESSIONAL ENGINEER
STATE OF ILLINOIS NO. 021-000000000-0000
REGISTERED PROFESSIONAL ARCHITECT
STATE OF ILLINOIS NO. 021-000000000-0000

State of Florida
Registered Architect

Joel Howard NuDell
Reg. No. 7953

project title



Suite - #2517
Interior Modification
David's World Cycle

OCCUPANCY:
"M" Mercantile

David's World Cycle

2517 Edgewater Dr Orlando FL 32804

sheet title

**PARTIAL PLUMBING
FLOOR PLAN**

DO NOT SCALE DRAWINGS
USE FIGURED DIMENSIONS ONLY

project number

2010-041

drawn NS

checked RMB

approved RMB

issued for date

OWNER ISSUE 03-11-10

OWNER ISSUE 03-18-10


PRICING ISSUE 03-23-10

PERMIT ISSUE 03-29-10

BULLETIN NO 01 04-20-10


sheet

P200

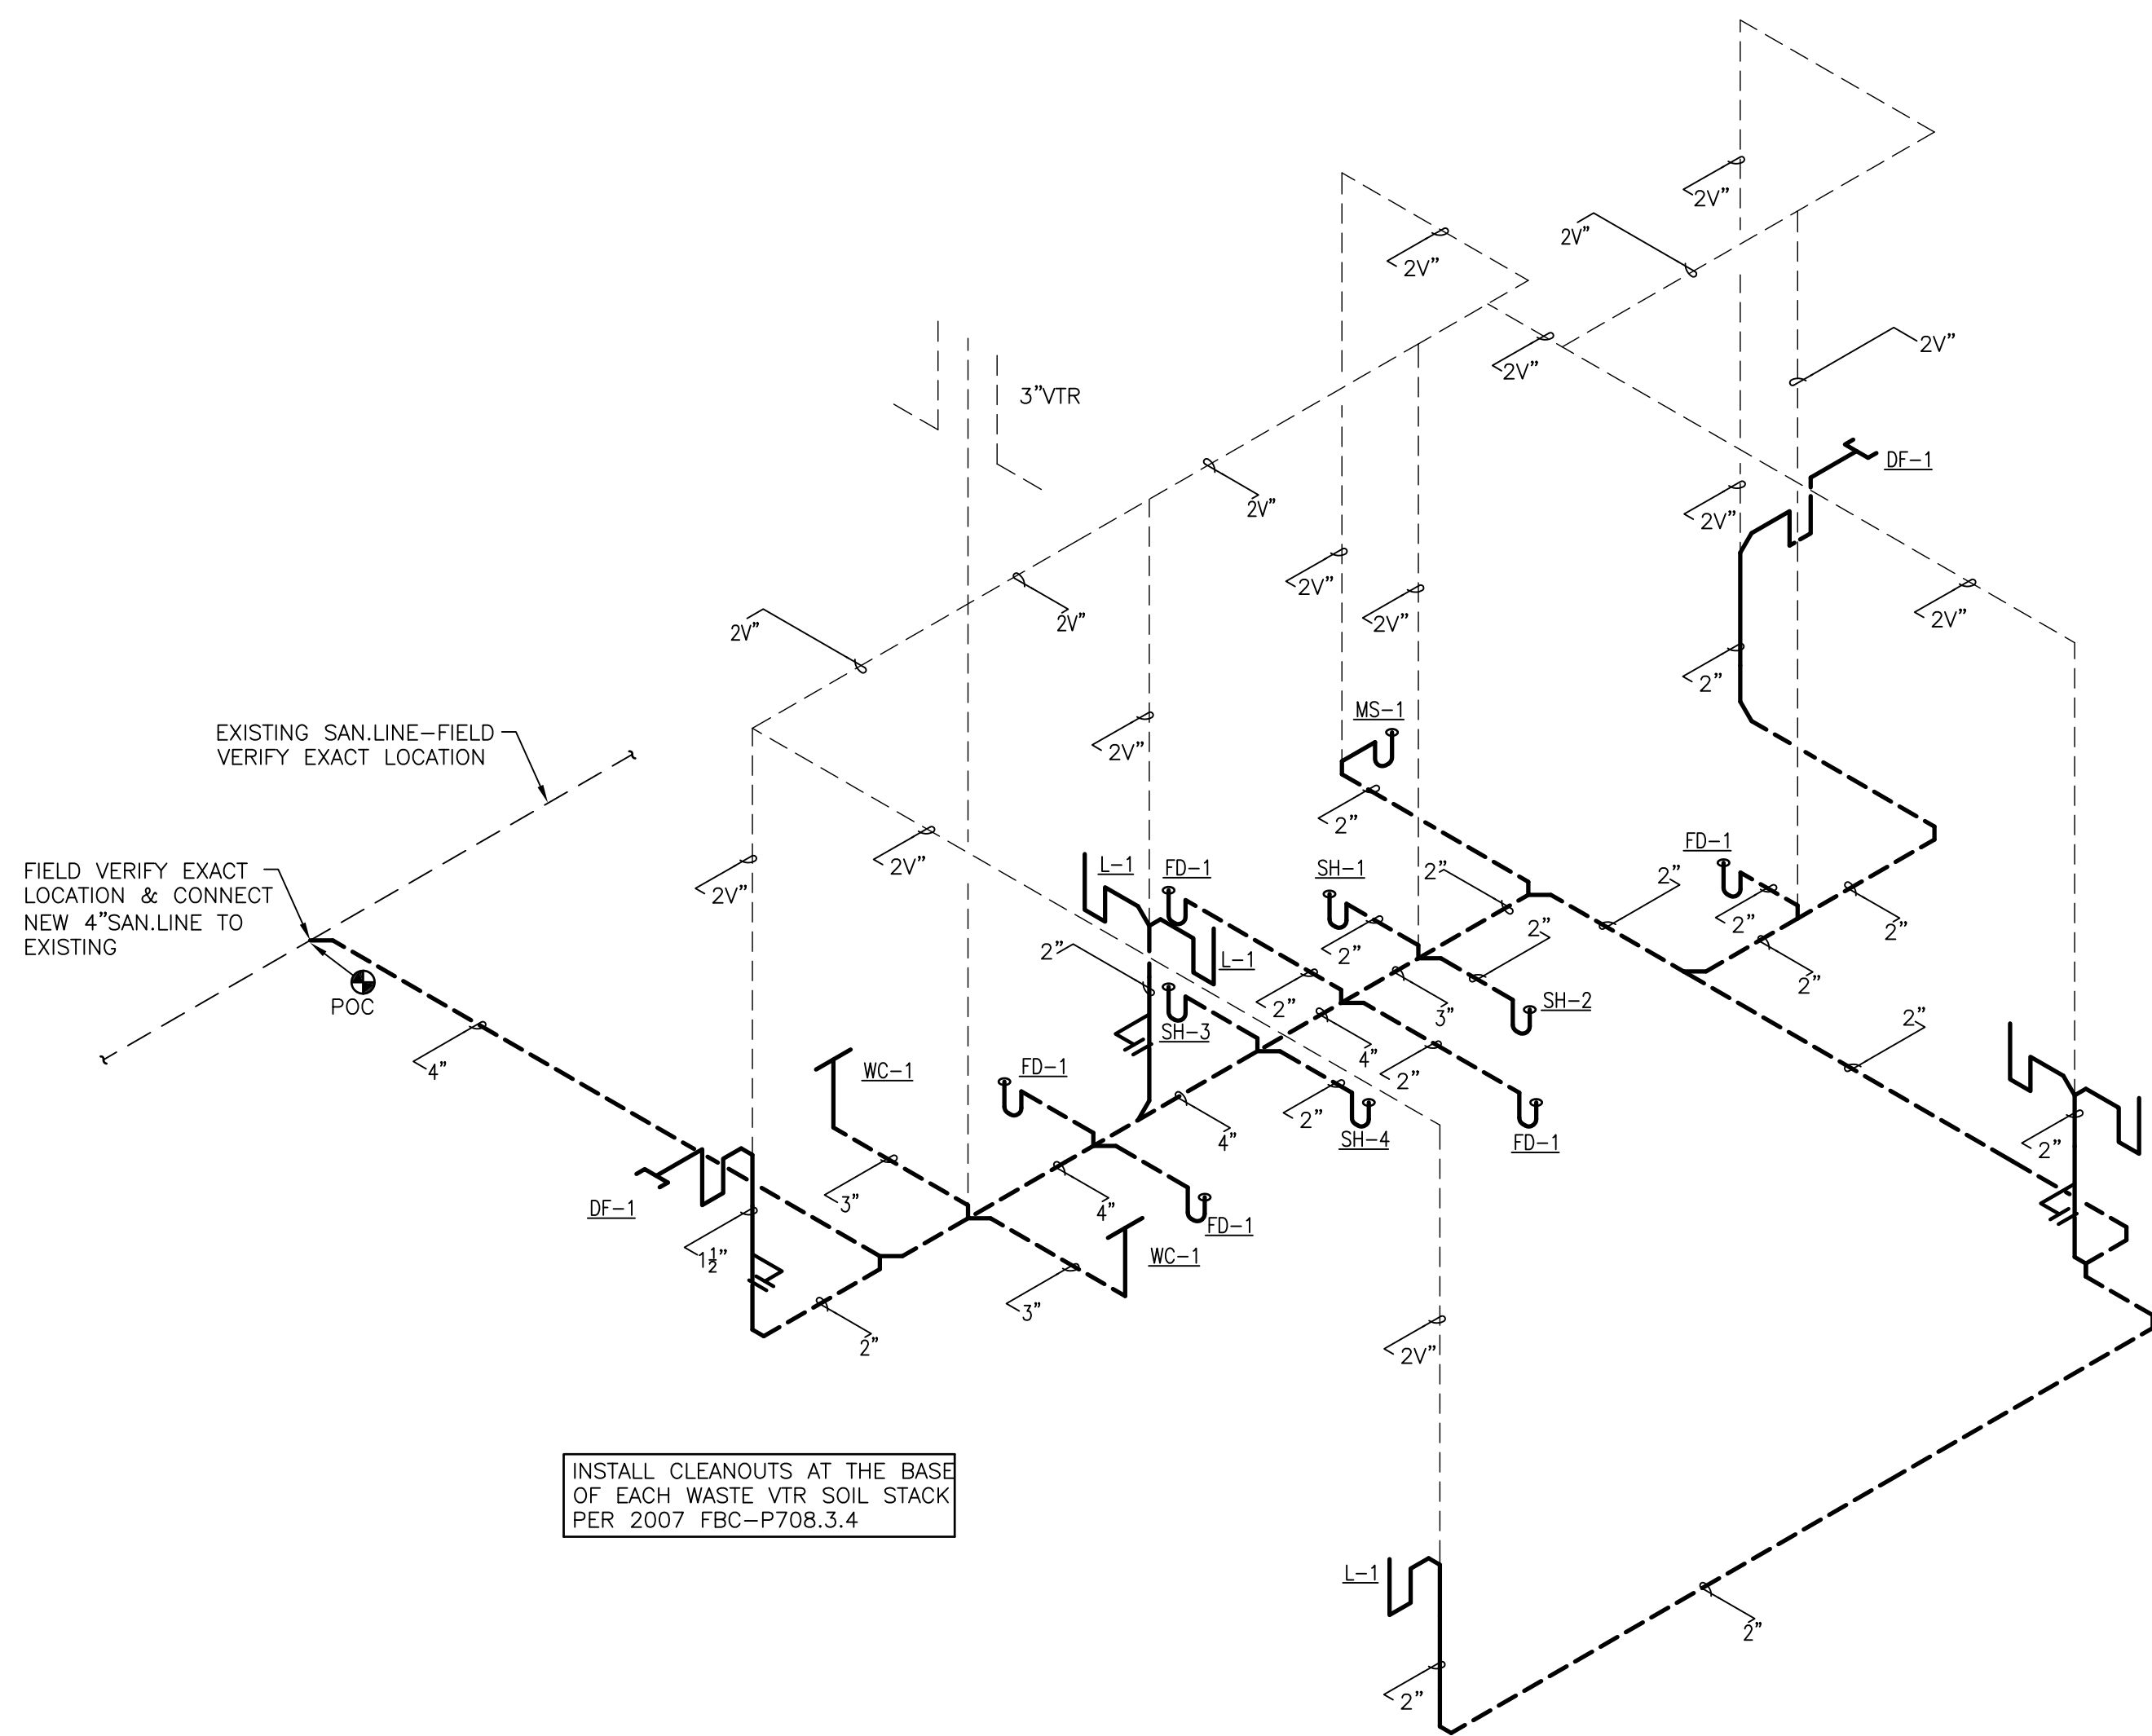


SANITARY RISER DIAGRAM

SCALE: NTS

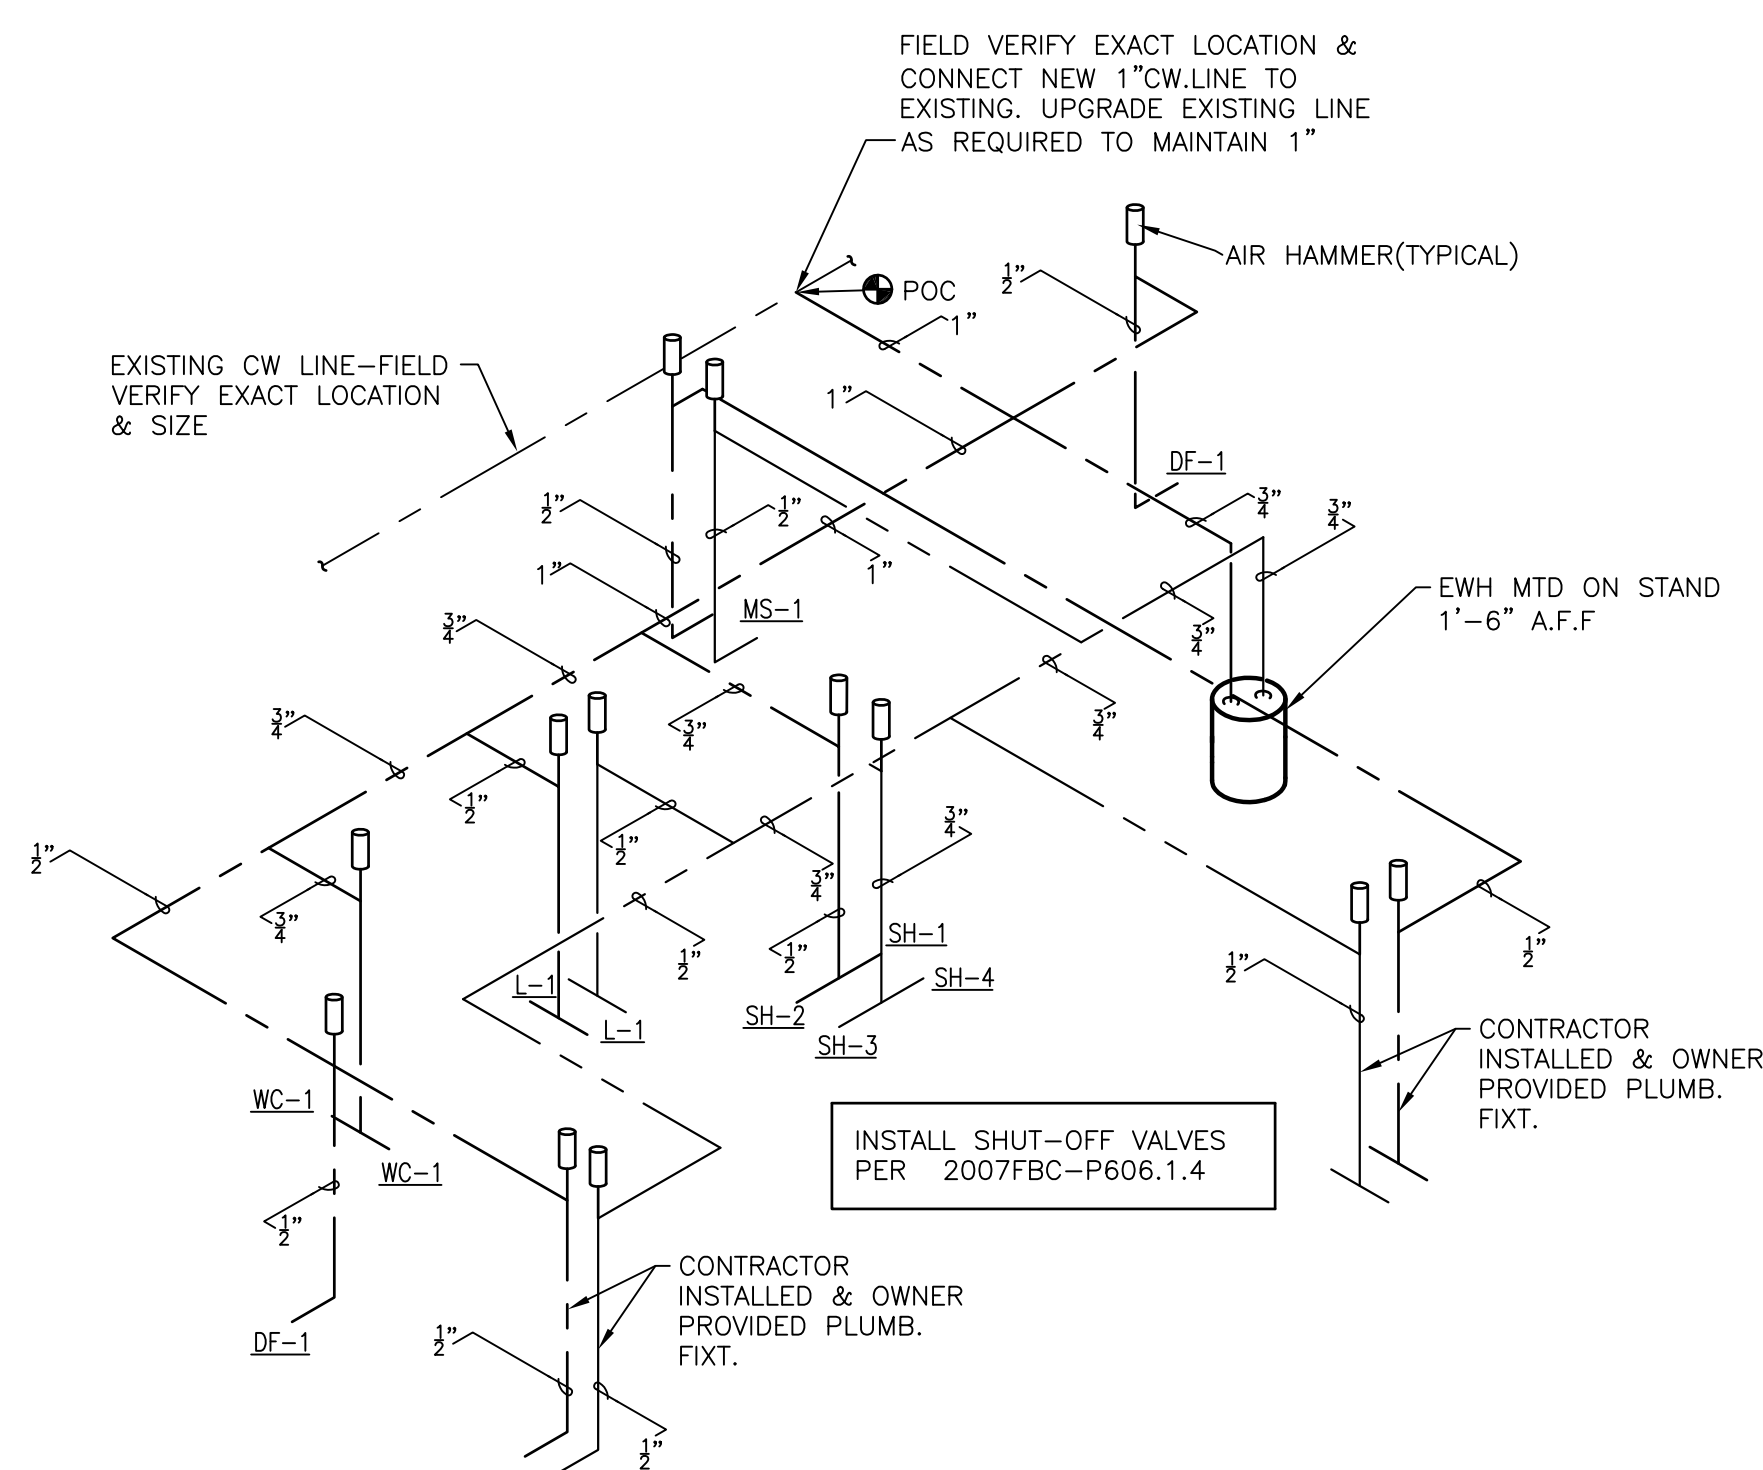

DOMESTIC WATER RISER DIAGRAM

SCALE: NTS

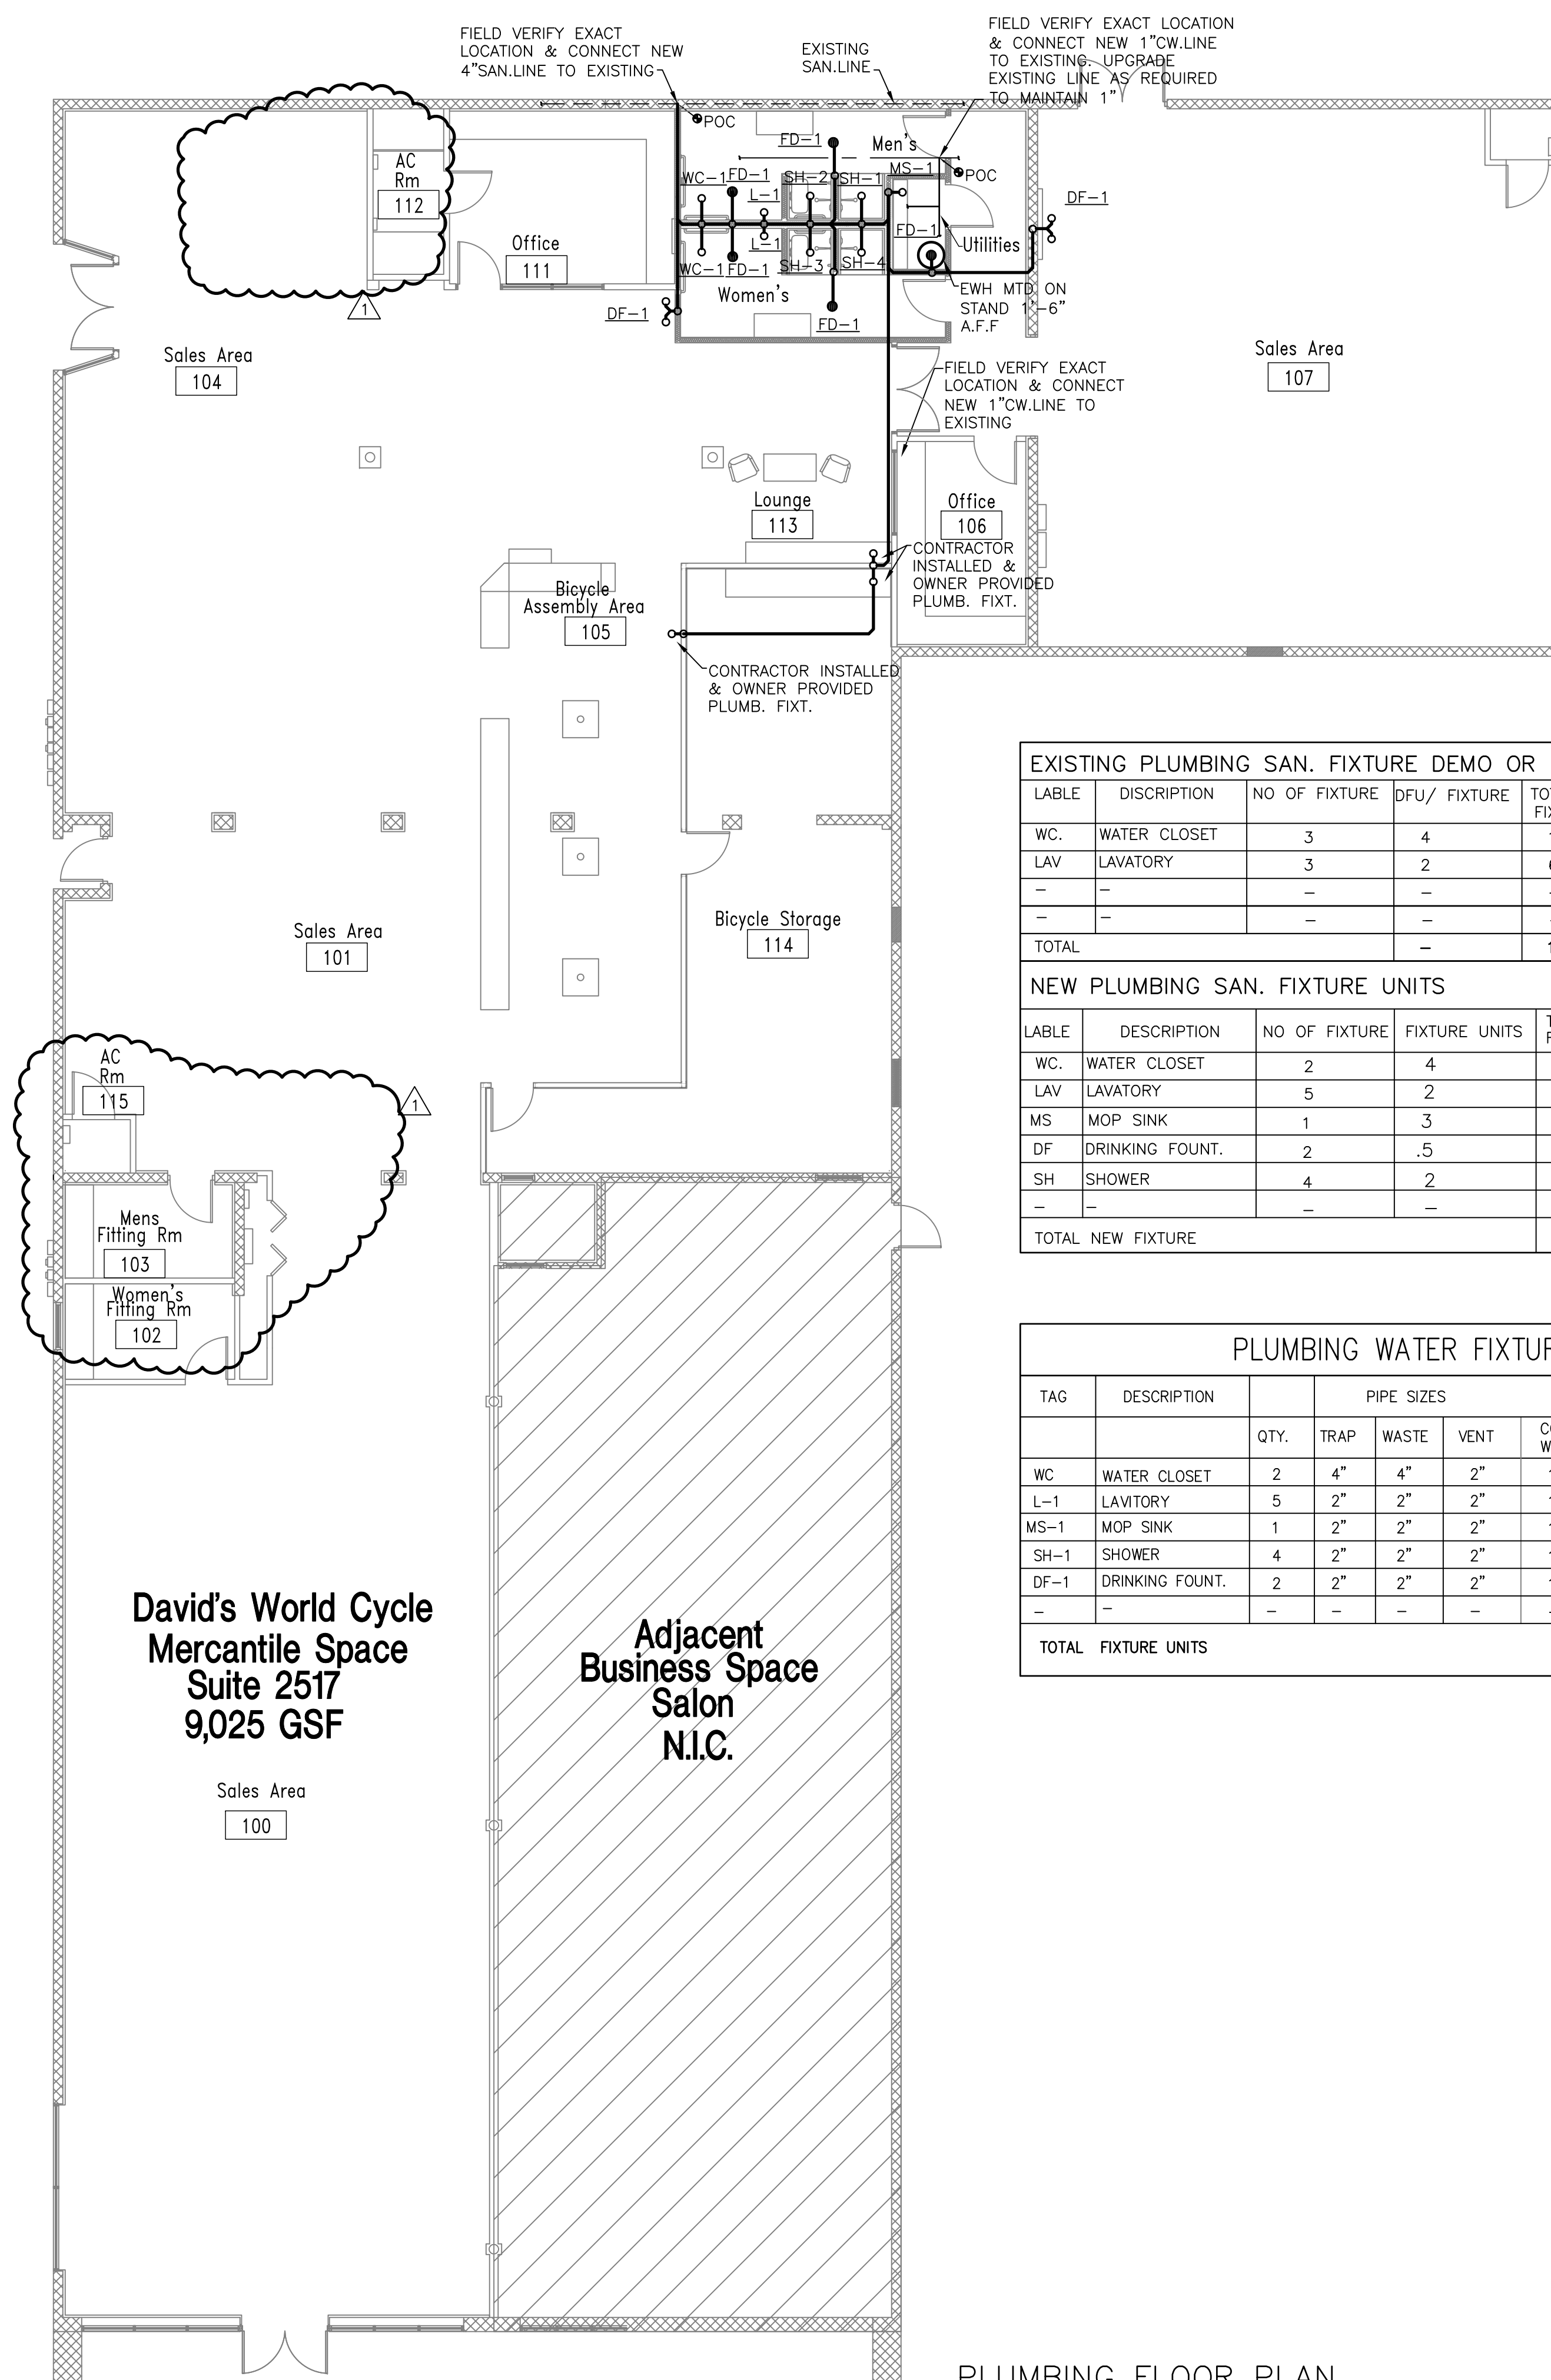

EXISTING PLUMBING SAN. FIXTURE DEMO OR REUSED

TABLE	DESCRIPTION	NO OF FIXTURE	DFU/ FIXTURE	TOTAL DEMO FIXTURE UNITS
WC	WATER CLOSET	3	4	12
LAV	LAVATORY	3	2	6
-	-	-	-	-
-	-	-	-	-
TOTAL				18 F.UNITS

NEW PLUMBING SAN. FIXTURE UNITS

TABLE	DESCRIPTION	NO OF FIXTURE	FIXTURE UNITS	TOTAL FIXTURE UNITS
WC	WATER CLOSET	2	4	8
LAV	LAVATORY	5	2	10
MS	MOP SINK	1	3	3
DF	DRINKING FOUNT.	2	.5	1
SH	SHOWER	4	2	8
-	-	-	-	-
TOTAL NEW FIXTURE				30 F.UNITS

PLUMBING WATER FIXTURE UNIT SCHEDULE

TAG	DESCRIPTION	QTY.	PIPE SIZES					FIXTURE UNITS			
			TRAP	WASTE	VENT	COLD WATER	HOT WATER	SFU/FIXT. WATER	DFU/FIXT. DRAINAGE	TOTAL DFU	TOTAL SFU WATER
WC	WATER CLOSET	2	4"	4"	2"	1/2"	-	5	4	8	10
L-1	LAVATORY	5	2"	2"	2"	1/2"	1/2"	2	2	10	10
MS-1	MOP SINK	1	2"	2"	2"	1/2"	1/2"	3	3	3	3
SH-1	SHOWER	4	2"	2"	2"	1/2"	1/2"	4	2	8	16
DF-1	DRINKING FOUNT.	2	2"	2"	2"	1/2"	-	.5	.5	1	1
-	-	-	-	-	-	-	-	-	-	-	-
TOTAL FIXTURE UNITS										30	40

PLUMBING FLOOR PLAN

SCALE: 1/8" = 1'-0"