


WATER HEATER DETAIL
NT5

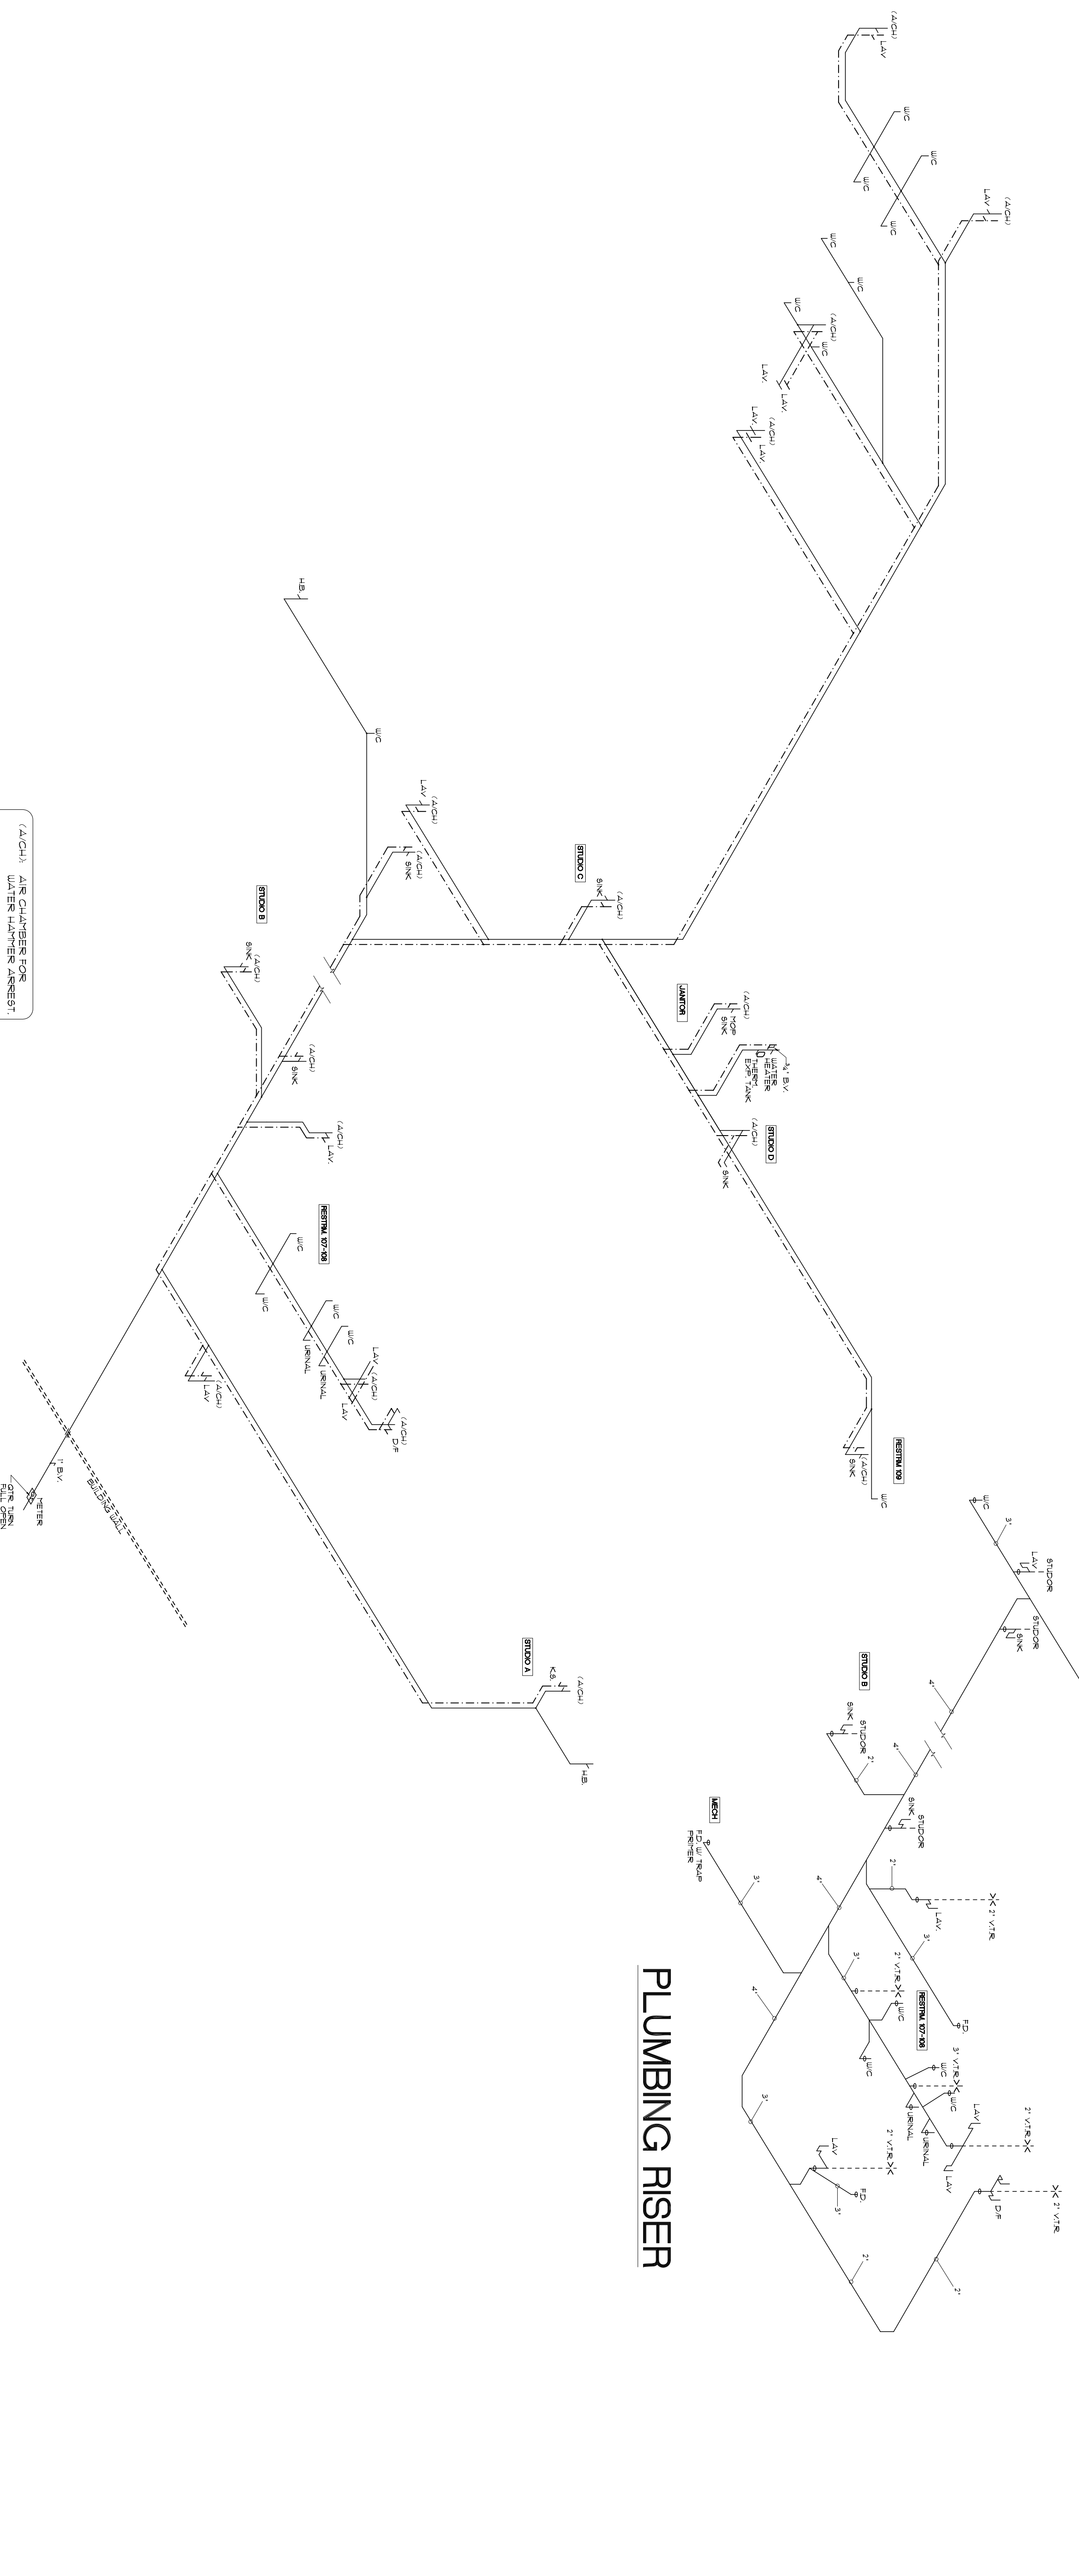

(A/CU) AIR CHAMBERS FOR WATER HAMMER ARREST.
--- HOT WATER LINE
--- COLD WATER LINE

FRESH WATER RISER

PLUMBING RISER

RISER DIAGRAMS

DESIGNER HEREBY EXPRESSLY RESERVES HIS COPYRIGHT AND OTHER PROPERTY RIGHTS IN THESE PLANS. THESE PLANS AND DRAWINGS ARE NOT TO BE REPRODUCED, CHANGED OR COPIED IN ANY FORM OR MANNER WHATSOEVER, NOR ARE THEY TO BE ASSIGNED TO ANY PARTY WITHOUT FIRST OBTAINING THE EXPRESSED WRITTEN PERMISSION AND CONSENT OF GERALD GROSS ARCHITECT.

PROJECT NO: 08CA108F2
DATE: 4 APR 2008
DRAWN BY: BVC
SHEET NO.: P-2

REVISIONS

RISER DIAGRAMS
Gateway Center for the Arts
DEBARY, FLORIDA

Ver. 10

GERALD GROSS AIA, FARA
architect
780 Deltona Blvd, Suite 105
Deltona, Florida 32725
386-574-2961
FL REG ARCHITECT NO. 5998