

5

4

3

2


1

D

C

B

A

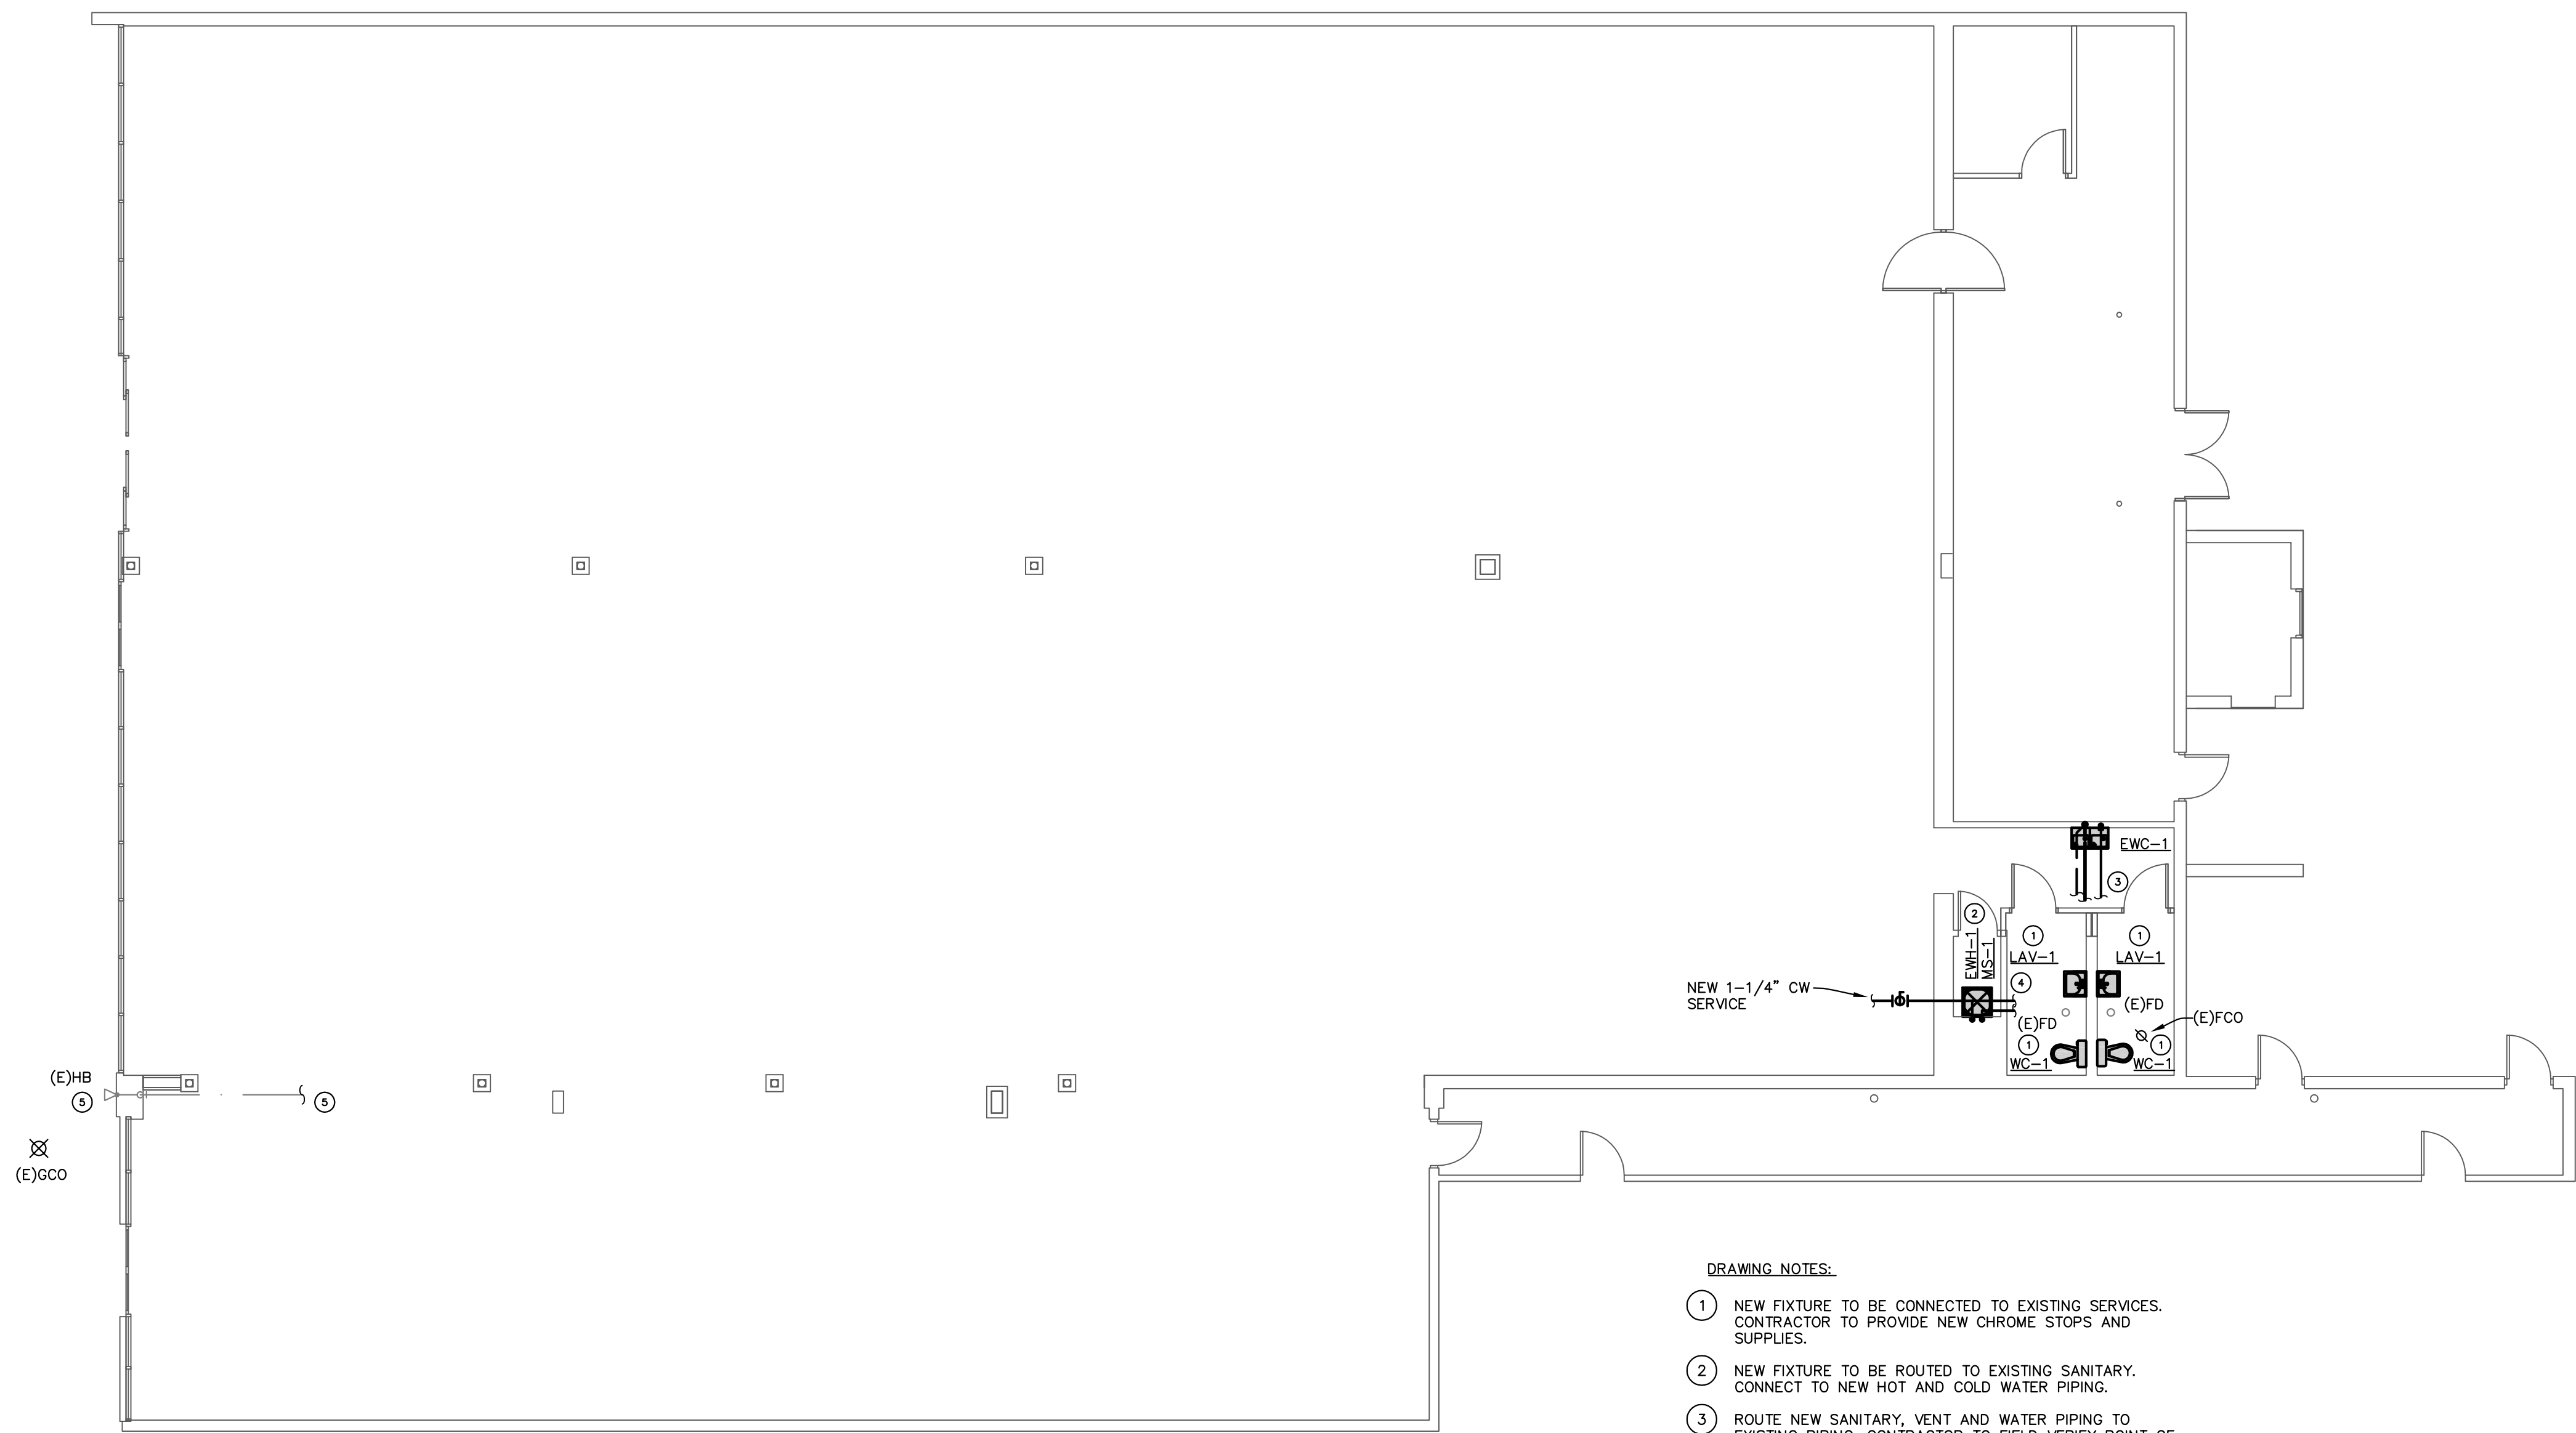

DRAWING NOTES:

- ① NEW FIXTURE TO BE CONNECTED TO EXISTING SERVICES. CONTRACTOR TO PROVIDE NEW CHROME STOPS AND SUPPLIES.
- ② NEW FIXTURE TO BE ROUTED TO EXISTING SANITARY. CONNECT TO NEW HOT AND COLD WATER PIPING.
- ③ ROUTE NEW SANITARY, VENT AND WATER PIPING TO EXISTING PIPING. CONTRACTOR TO FIELD VERIFY POINT OF NEW CONNECTION PRIOR TO START OF WORK.
- ④ ROUTE NEW WATER HEATER HOT AND COLD WATER PIPING TO EXISTING FIXTURES.
- ⑤ CONTRACTOR TO MAINTAIN WATER SERVICE TO EXISTING FIXTURE.


1 FLOOR PLAN - PLUMBING
 P-1.1 SCALE: 1/8" = 1'-0"

rojo

rojo Architecture
 AA 0002952
 5701 E. Hillsborough Avenue
 Suite 1130
 Tampa, FL 33610
 813 630 5508 (p)
 813 630 5518 (f)
 (e-mail) rojo@rojarchitecture.com
 www.rojarchitecture.com

STATE OF FLORIDA
 REGISTERED ENGINEER

MARK E. AWMILLER, P.E.
 53973

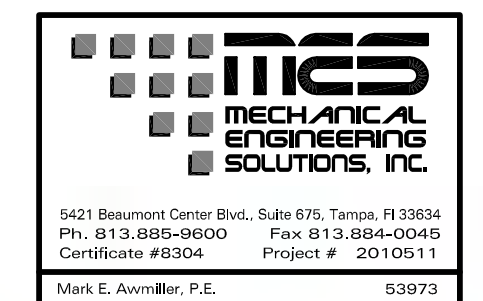

Party City
 THE DISCOUNT PARTY SUPER STORE

COLONIAL LANDING
 SHOPPING CENTER
 3220 EAST COLONIAL BLVD.
 ORLANDO, FL



Mark	Date	Description
-	3/2/10	Permit Set

Issue/Revision	Permit Set
Project ID	10003
CAD File Name	10003-CD.vwx
Drawn By	DM
Checked By	MEA
Plot Date:	3/2/10
Record Date:	Record Date

FLOOR PLAN -
 PLUMBING

SCALE: 1/8"=1'-0"

Drawing No.
P-1.1

5

4

3

2

1