


STATE OF FLORIDA
 REGISTERED ENGINEER

MARK E. AWMILLER, P.E.
 53973

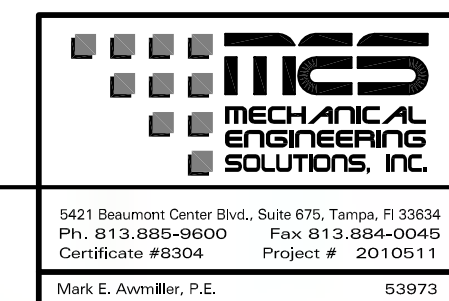

COLONIAL LANDING
 SHOPPING CENTER
 3220 EAST COLONIAL BLVD.
 ORLANDO, FL



3/2/10 Permit Set


Mark	Date	Description
-	3/2/10	Permit Set

FLOOR PLAN -
 FIRE PROTECTION

SCALE: 1/8"=1'-0"

Drawing No.

F-1.1

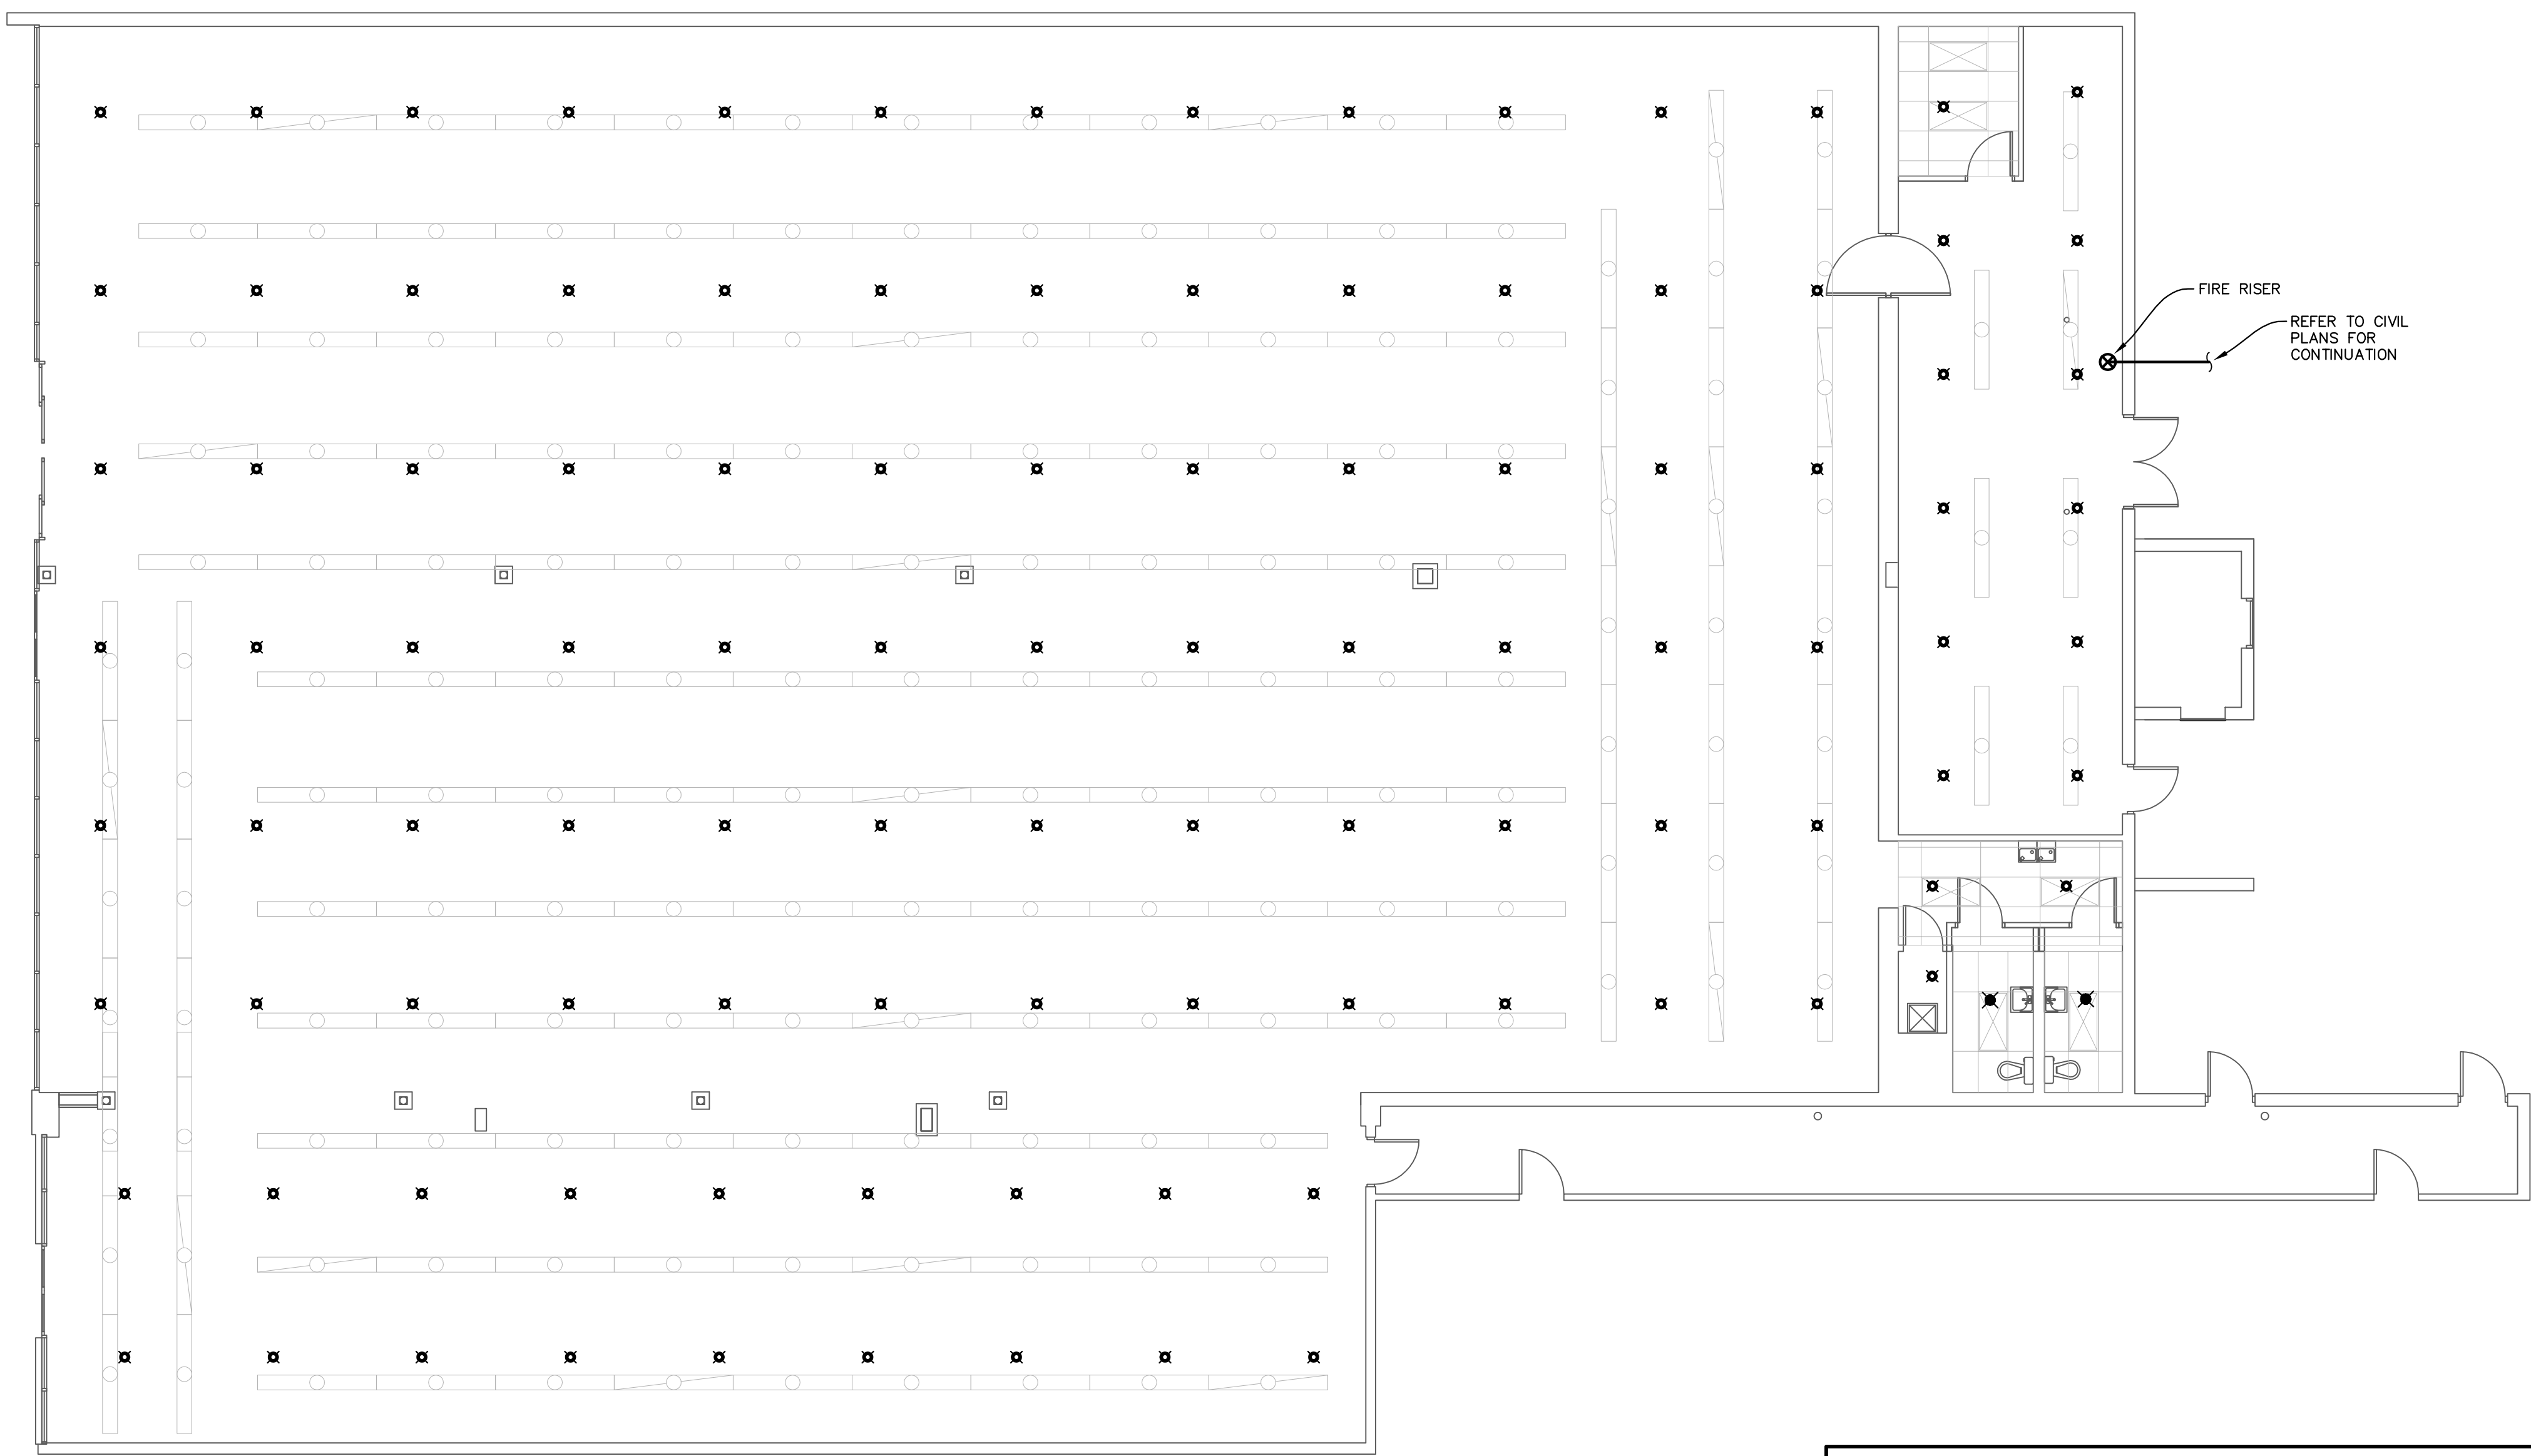

NOTE:
 ACTUAL PIPE SIZING, ROUTING AND LOCATION SHALL BE BY THE FIRE SPRINKLER CONTRACTOR PER F.A.C. 61G15. CONTRACTOR SHALL PROVIDE SHOP DRAWINGS AND HYDRAULIC CALCULATIONS TO THE ENGINEER AND FIRE MARSHAL FOR REVIEW.

OCCUPANCY HAZARDS:
 ORDINARY HAZARD OCCUPANCY (GROUP 2), 130 SQUARE FEET – MAXIMUM SPRINKLER SPACING – DENSITY 0.2/1500 SQ.FT.

CODE REFERENCE:
 NFPA 13 – STANDARD FOR THE INSTALLATION OF SPRINKLER SYSTEMS 2002 EDITION.
 FLORIDA BUILDING CODE 2007 EDITION WITH ALL AMENDMENTS AND SUPPLEMENTS.
 FLORIDA FIRE PREVENTION CODE 2007 EDITION WITH ALL AMENDMENTS AND SUPPLEMENTS.

SYM NAME	METAL	TEMP	DESCRIPTION
✕ UPRIGHT	BRASS	155	STANDARD COVERAGE, QUICK RESPONSE
✕ RECESSED PENDENT	CHROME	155	STANDARD COVERAGE, QUICK RESPONSE

1 FLOOR PLAN - FIRE PROTECTION
 F-1.1 SCALE: 1/8" = 1'-0"