

PROJECT NO.	200617
DATE	07/22/09
DRAWN	
TAB	
CHECKED	JFK

RELEASE	

Joseph F. Keene P. E.  
 FL# 60322


PROJECT NAME  
**Ross Dress for Less**  
 The Marketplace  
 Seminole Towne Center  
 Sanford, Florida

SHEET TITLE  
**HVAC Roof Plan**

CLIENT NAME  
**Weingarten Realty Investors**  
 2720 E Colonial Drive  
 Orlando, Florida 32803

**Cuhaci & Peterson**  
 Architects Engineers Planners  
 Florida Corporate Certificate #PA 000535

1925 Project Avenue, Orlando, FL 32814  
 Tel: 407.681.9100 - Fax: 407.681.9101  
 www.cpa.com

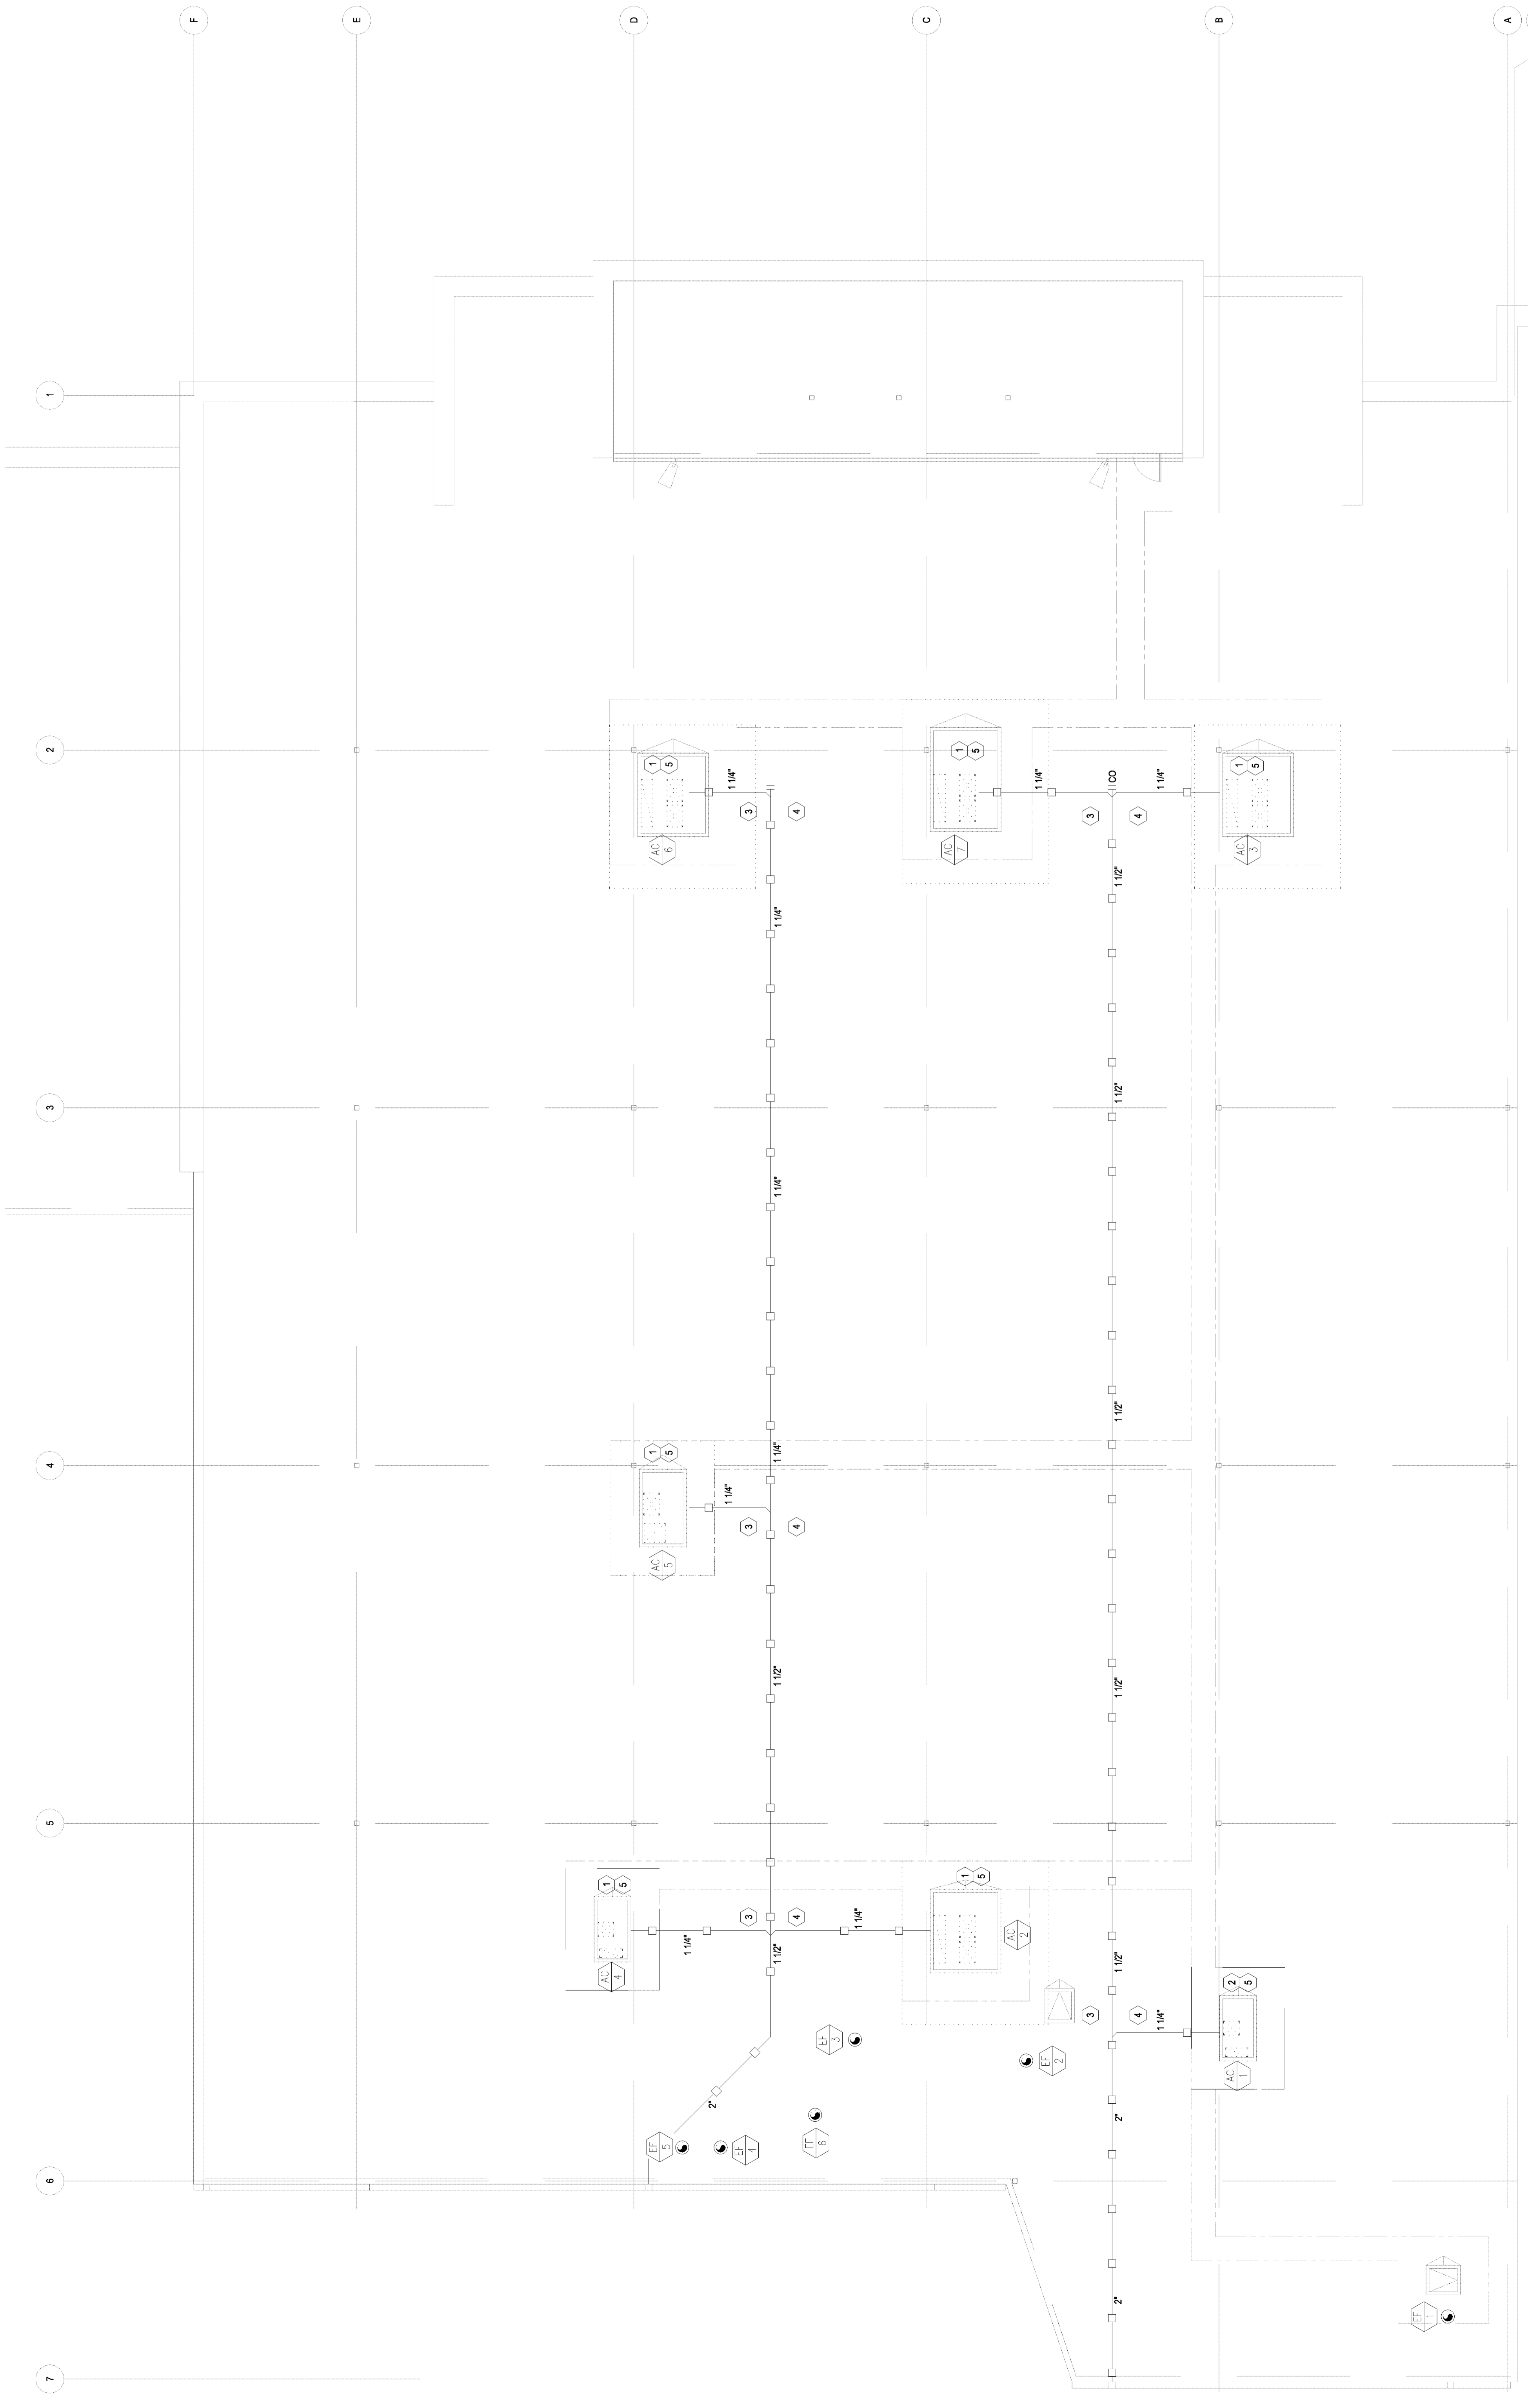

- MECHANICAL KEY PLAN NOTES:**
- COORDINATE EXACT LOCATION OF MECHANICAL UNITS WITH EXISTING CURB LOCATIONS. REFER TO THE DOWN DETAIL ON MECHANICAL DETAIL SHEET. COORDINATE WITH MANUFACTURERS RECOMMENDATIONS.
  - COORDINATE EXACT LOCATION OF MECHANICAL UNIT WITH ARCHITECTURAL ROOF PLAN. REFER TO THE DOWN DETAIL ON ARCHITECTURAL ROOF PLAN. REFER TO THE DOWN DETAIL ON MECHANICAL DETAIL SHEET. COORDINATE WITH MANUFACTURERS RECOMMENDATIONS.
  - RUN CONDENSATE FROM MECHANICAL UNITS TO ROOF DRAINAGE AND TERMINATE WITH APPROVED AIR CAP. REFER TO ARCHITECTURAL ROOF PLAN FOR LOCATION OF DRAIN/GUTTER.
  - REFER TO CONDENSATE TRAP DETAIL ON MECHANICAL DETAIL SHEET FOR PIPE SIZE. REFER TO PIPE SUPPORT DETAIL ON MECHANICAL DETAIL SHEET FOR INSTALLATION.
  - INSTALL FLEXIBLE CONNECTIONS BETWEEN ALL DUCT WORK AND MECHANICAL UNITS.

HVAC Roof Plan  
 Scale: 1/8"=1'-0"