


PROJECT NO.	202517
DATE	07/22/09
DRAWN	AV
CHECKED	TTN

RELEASE	


PROJECT NAME
TIMOTHY T. MASH
FL 43254

SHEET TITLE
Electrical Roof Power Plan

CLIENT NAME
Weingarten Realty Investors
2720 E Colonial Drive
Orlando, Florida 32803




Cuhaci & Peterson
Architects Engineers Planners
Florida Corporate Certificate #VA C000526
1925 Prospect Avenue, Orlando, FL 32814
Ph: 407.661.9100 - Fax: 407.661.9101
www.cpa.com

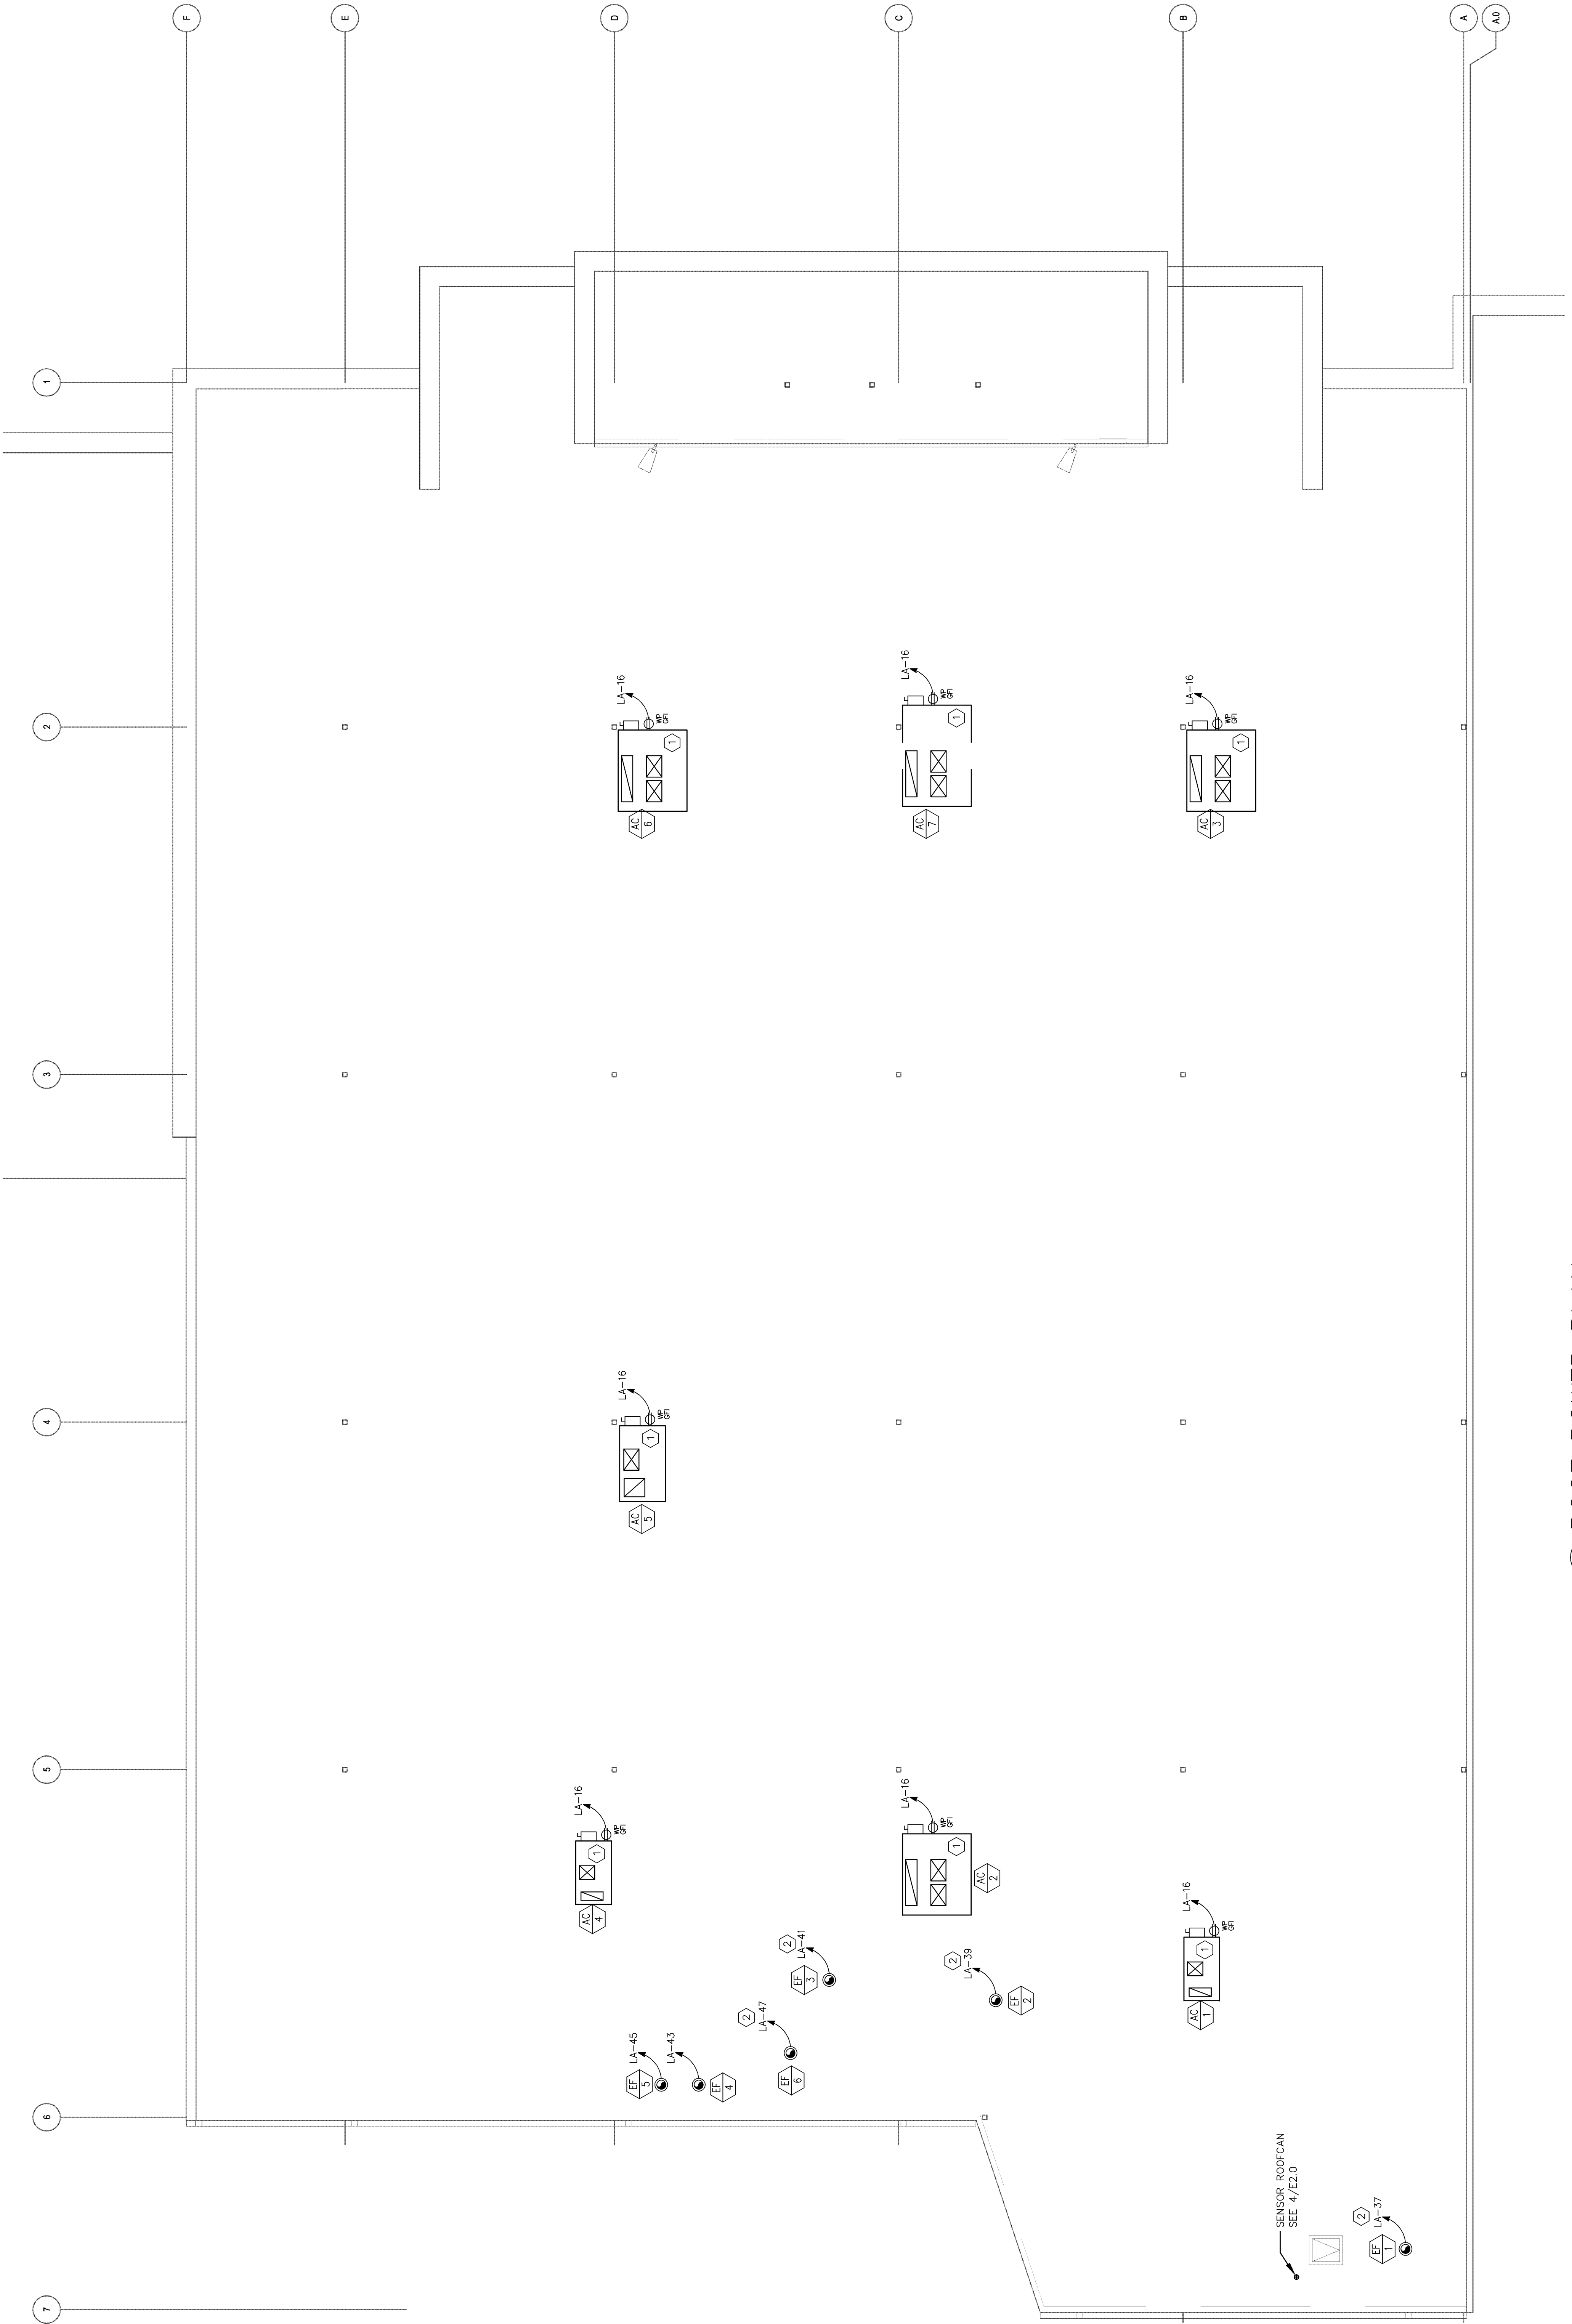

- REMARKS/NOTES:
- ① ROOF TOP UNIT PROVIDED WITH SERVICE DISCONNECT SWITCH AND AFCI RECEPTACLE CONNECT COMPLETE. SEE PANEL SCHEDULE. SMOKE DETECTORS WILL BE FACTORY PROVIDED AND INSTALLED ON APPLICABLE LENOX UNITS.
 - ② PROVIDE CONTROL BY ENERGY MANAGEMENT SYSTEM AND LINE VOLTAGE THERMOSTAT IN PARALLEL.

1 ROOF POWER PLAN
E4.0

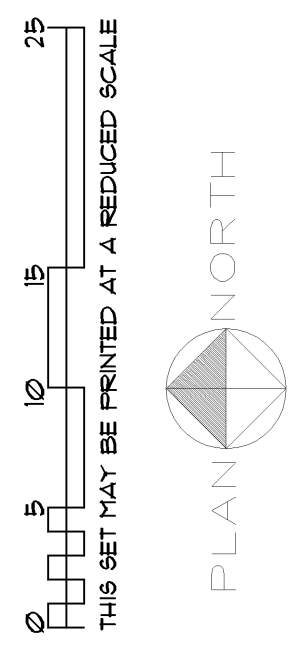

SENSOR ROOFTOPCAN
SEE 4/12.00