



ELECTRICAL DEMOLITION PLAN - AREA A
SCALE: 1/4"=1'-0"

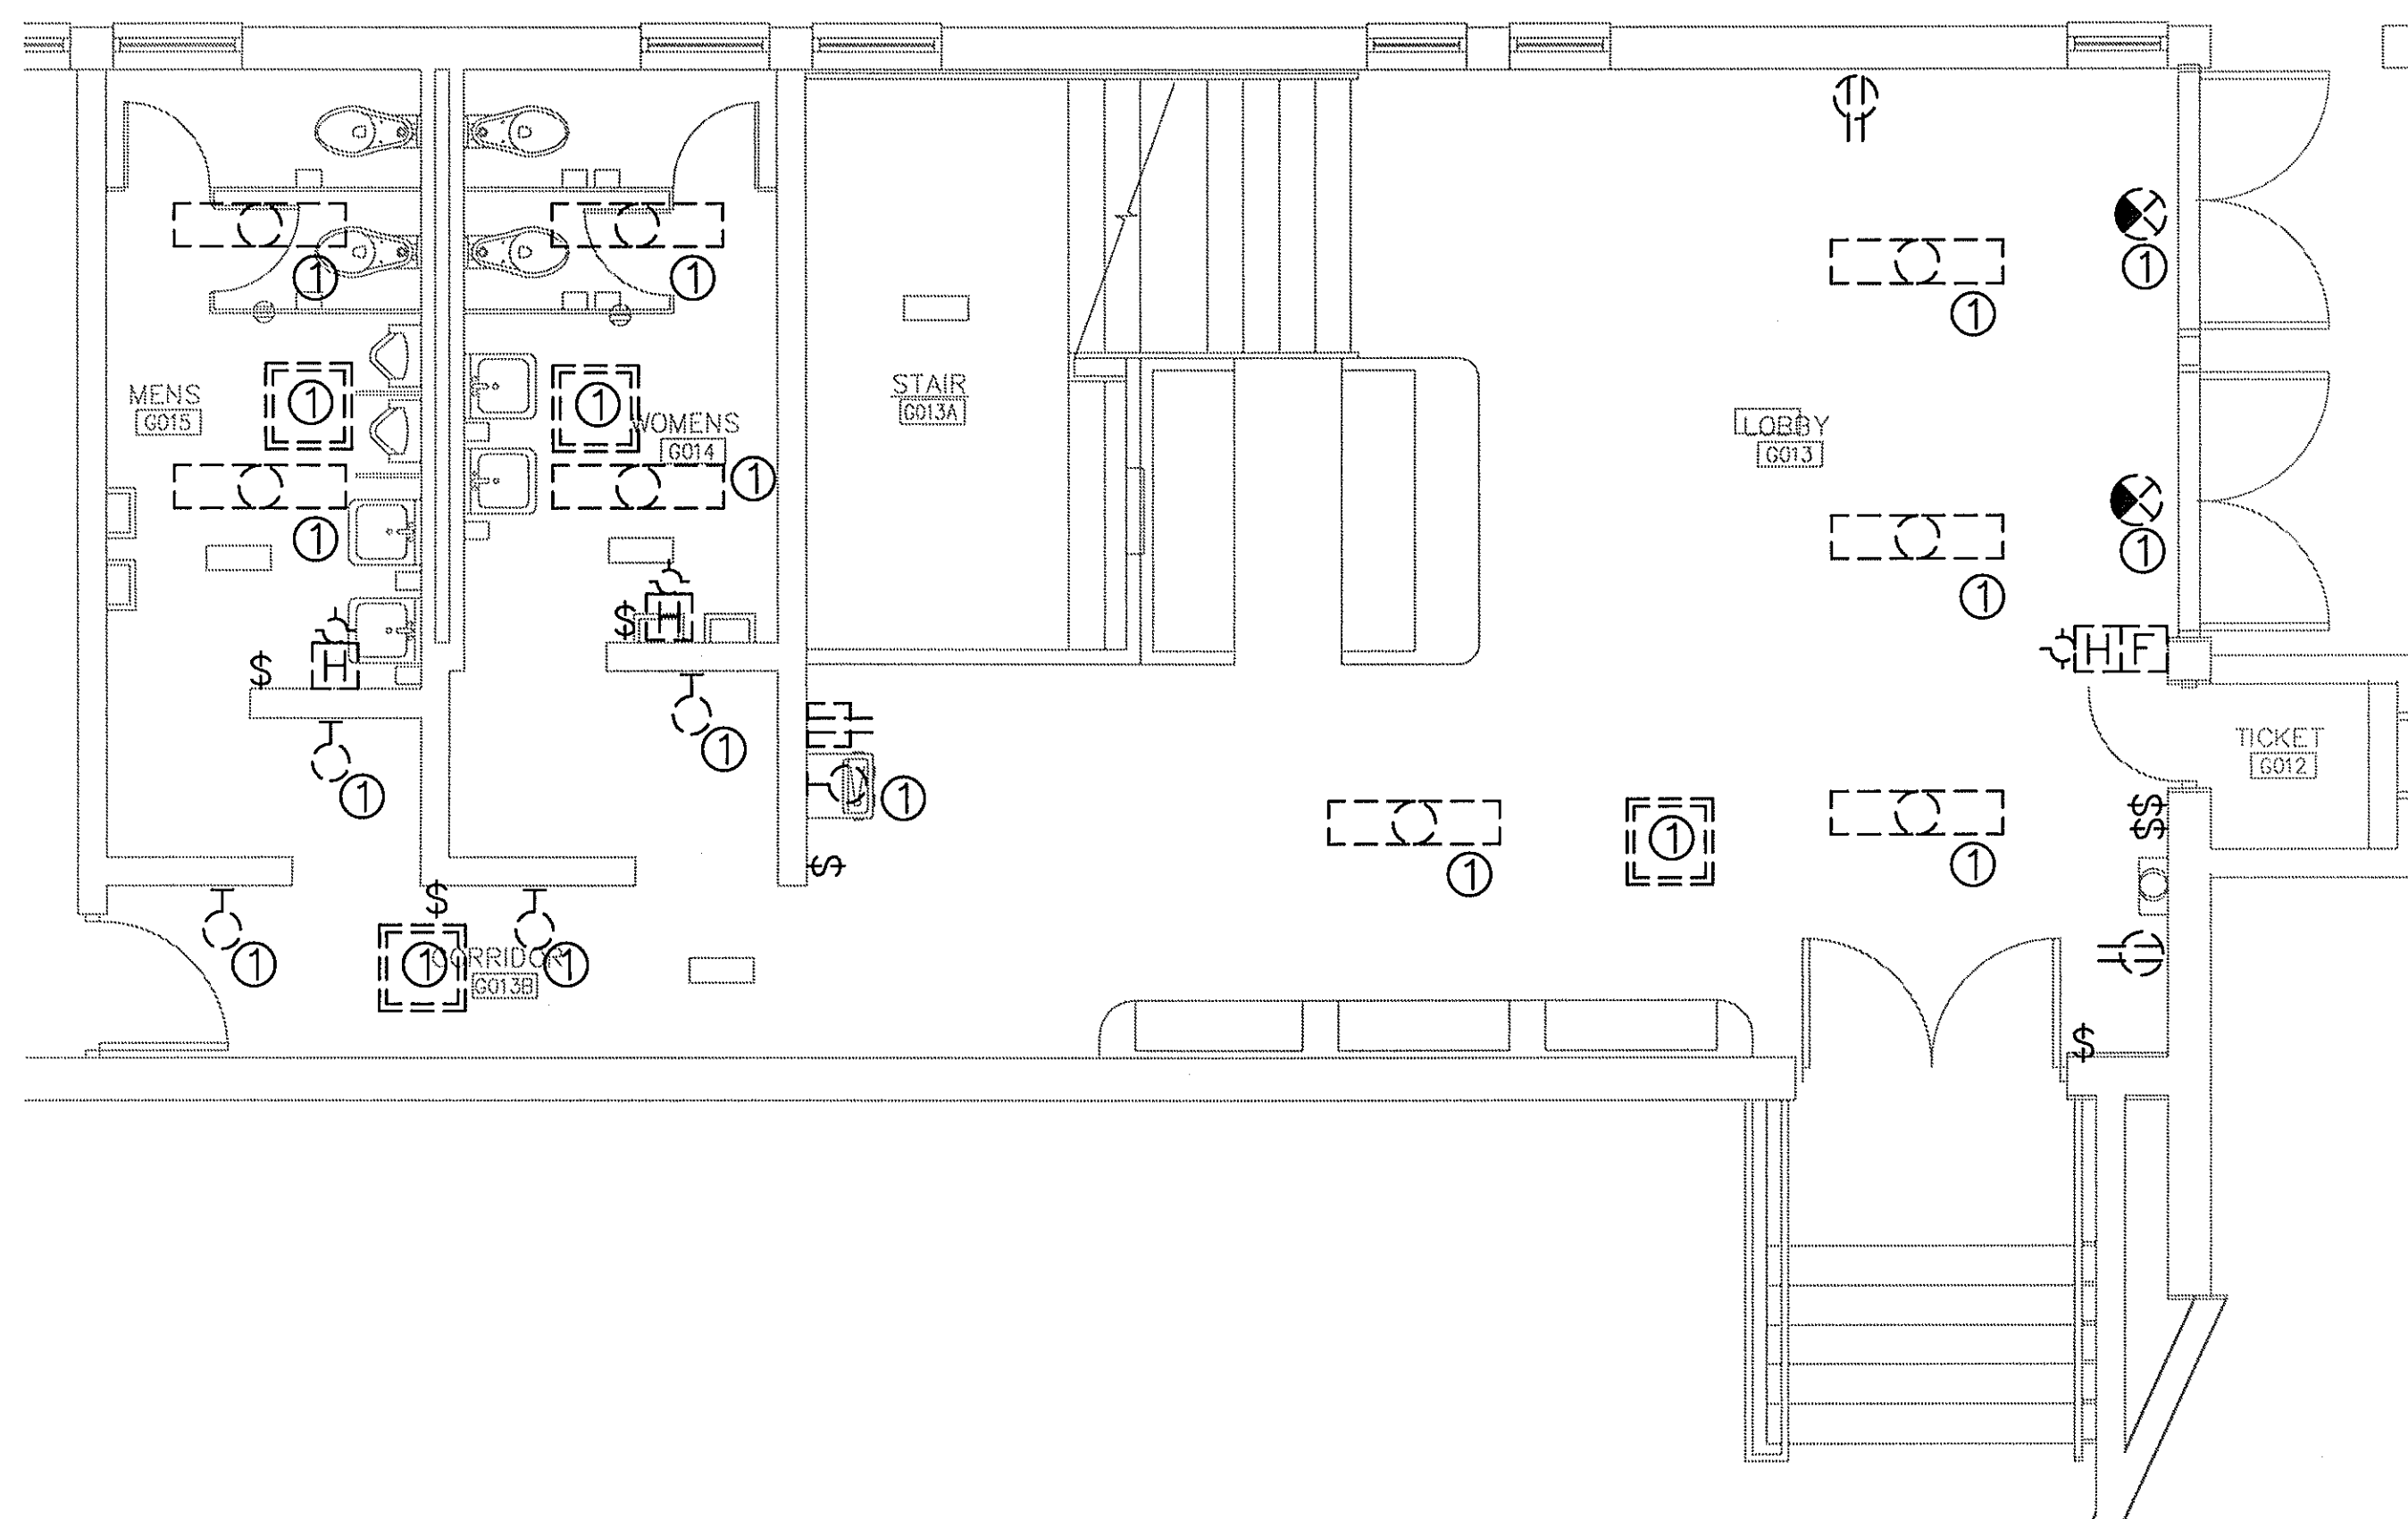

ELECTRICAL DEMOLITION PLAN - AREA B
SCALE: 1/4"=1'-0"

FLOOR PLAN NOTES:
 ⓪ REFERENCE NOTE ON DRAWING
 1. EXISTING DEVICE TO BE REMOVED.
 2. EXISTING AHU TO BE RELOCATED.

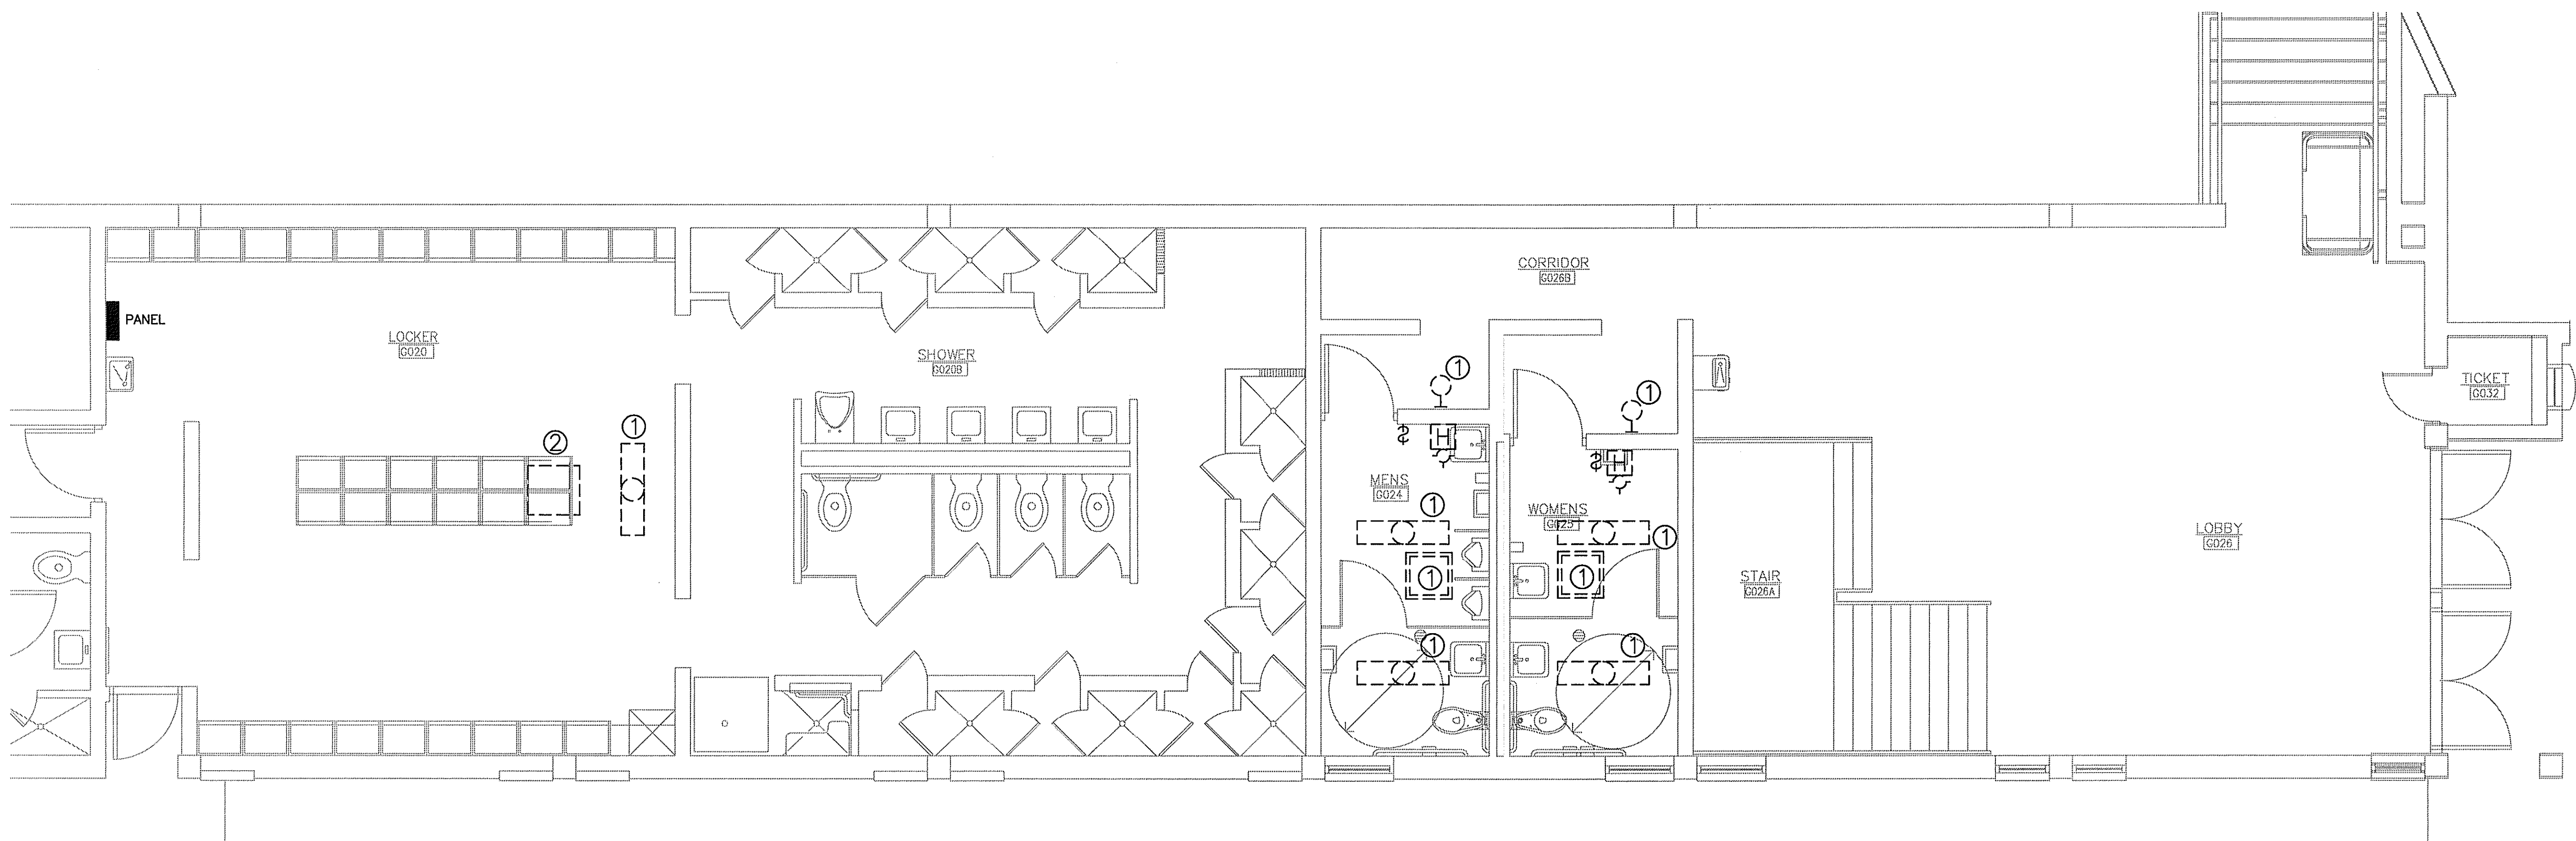

ELECTRICAL DEMOLITION PLAN - AREA C
SCALE: 1/4"=1'-0"

REVISION	BY

CRG ARCHITECTS/PALATKA, INC
 216 ST. JOHNS AVE. PALATKA, FL 32177
 440002604 (366) 325 0213 FAX (366) 326 1401

ELECTRICAL
DEMOLITION PLAN

RENOVATIONS TO THE HEALTH BUILDING(2010)
 ST. JOHNS COMMUNITY COLLEGE
 PALATKA, FL

Seal/Signature:

Date: 06/18/10
 Scale: AS NOTED
 Drawn: JBS
 Job: 015G02



Sheet:
E-2
 8 Of 11 Sheets

COPYRIGHT © CRG ARCHITECTS