

SEAL

DEAN S. KENYON, P.E.  
 FL. LIC. No. 44012

Signature \_\_\_\_\_ Date \_\_\_\_\_

**DRAWING REVISIONS**

REVISION	COMMENTS
△	
△	
△	
△	
△	
△	


**UNIVERSITY OF SOUTH FLORIDA**  
**SOUTH EAST CHILLER PLANT**  
**BR-590 COMPONENT #6**  
 12225 USF MAPLE DRIVE  
 TAMPA, FLORIDA 33620

DRAWING TITLE :  
**MECHANICAL 3-D PIPING LAYOUT**  
 Drawing Progress: 100% CONSTRUCTION DOCUMENTS

FILE NAME: 081106\_M-12-13.DWG  
 DATE: 03-31-2009  
 PLOT SIZE: AS NOTED  
 CADDED BY: SRN  
 DESIGNED BY: TSH  
 CHECKED BY: TSH


PROJECT NO.  
 081106  
 SHEET NO.

**M-12**

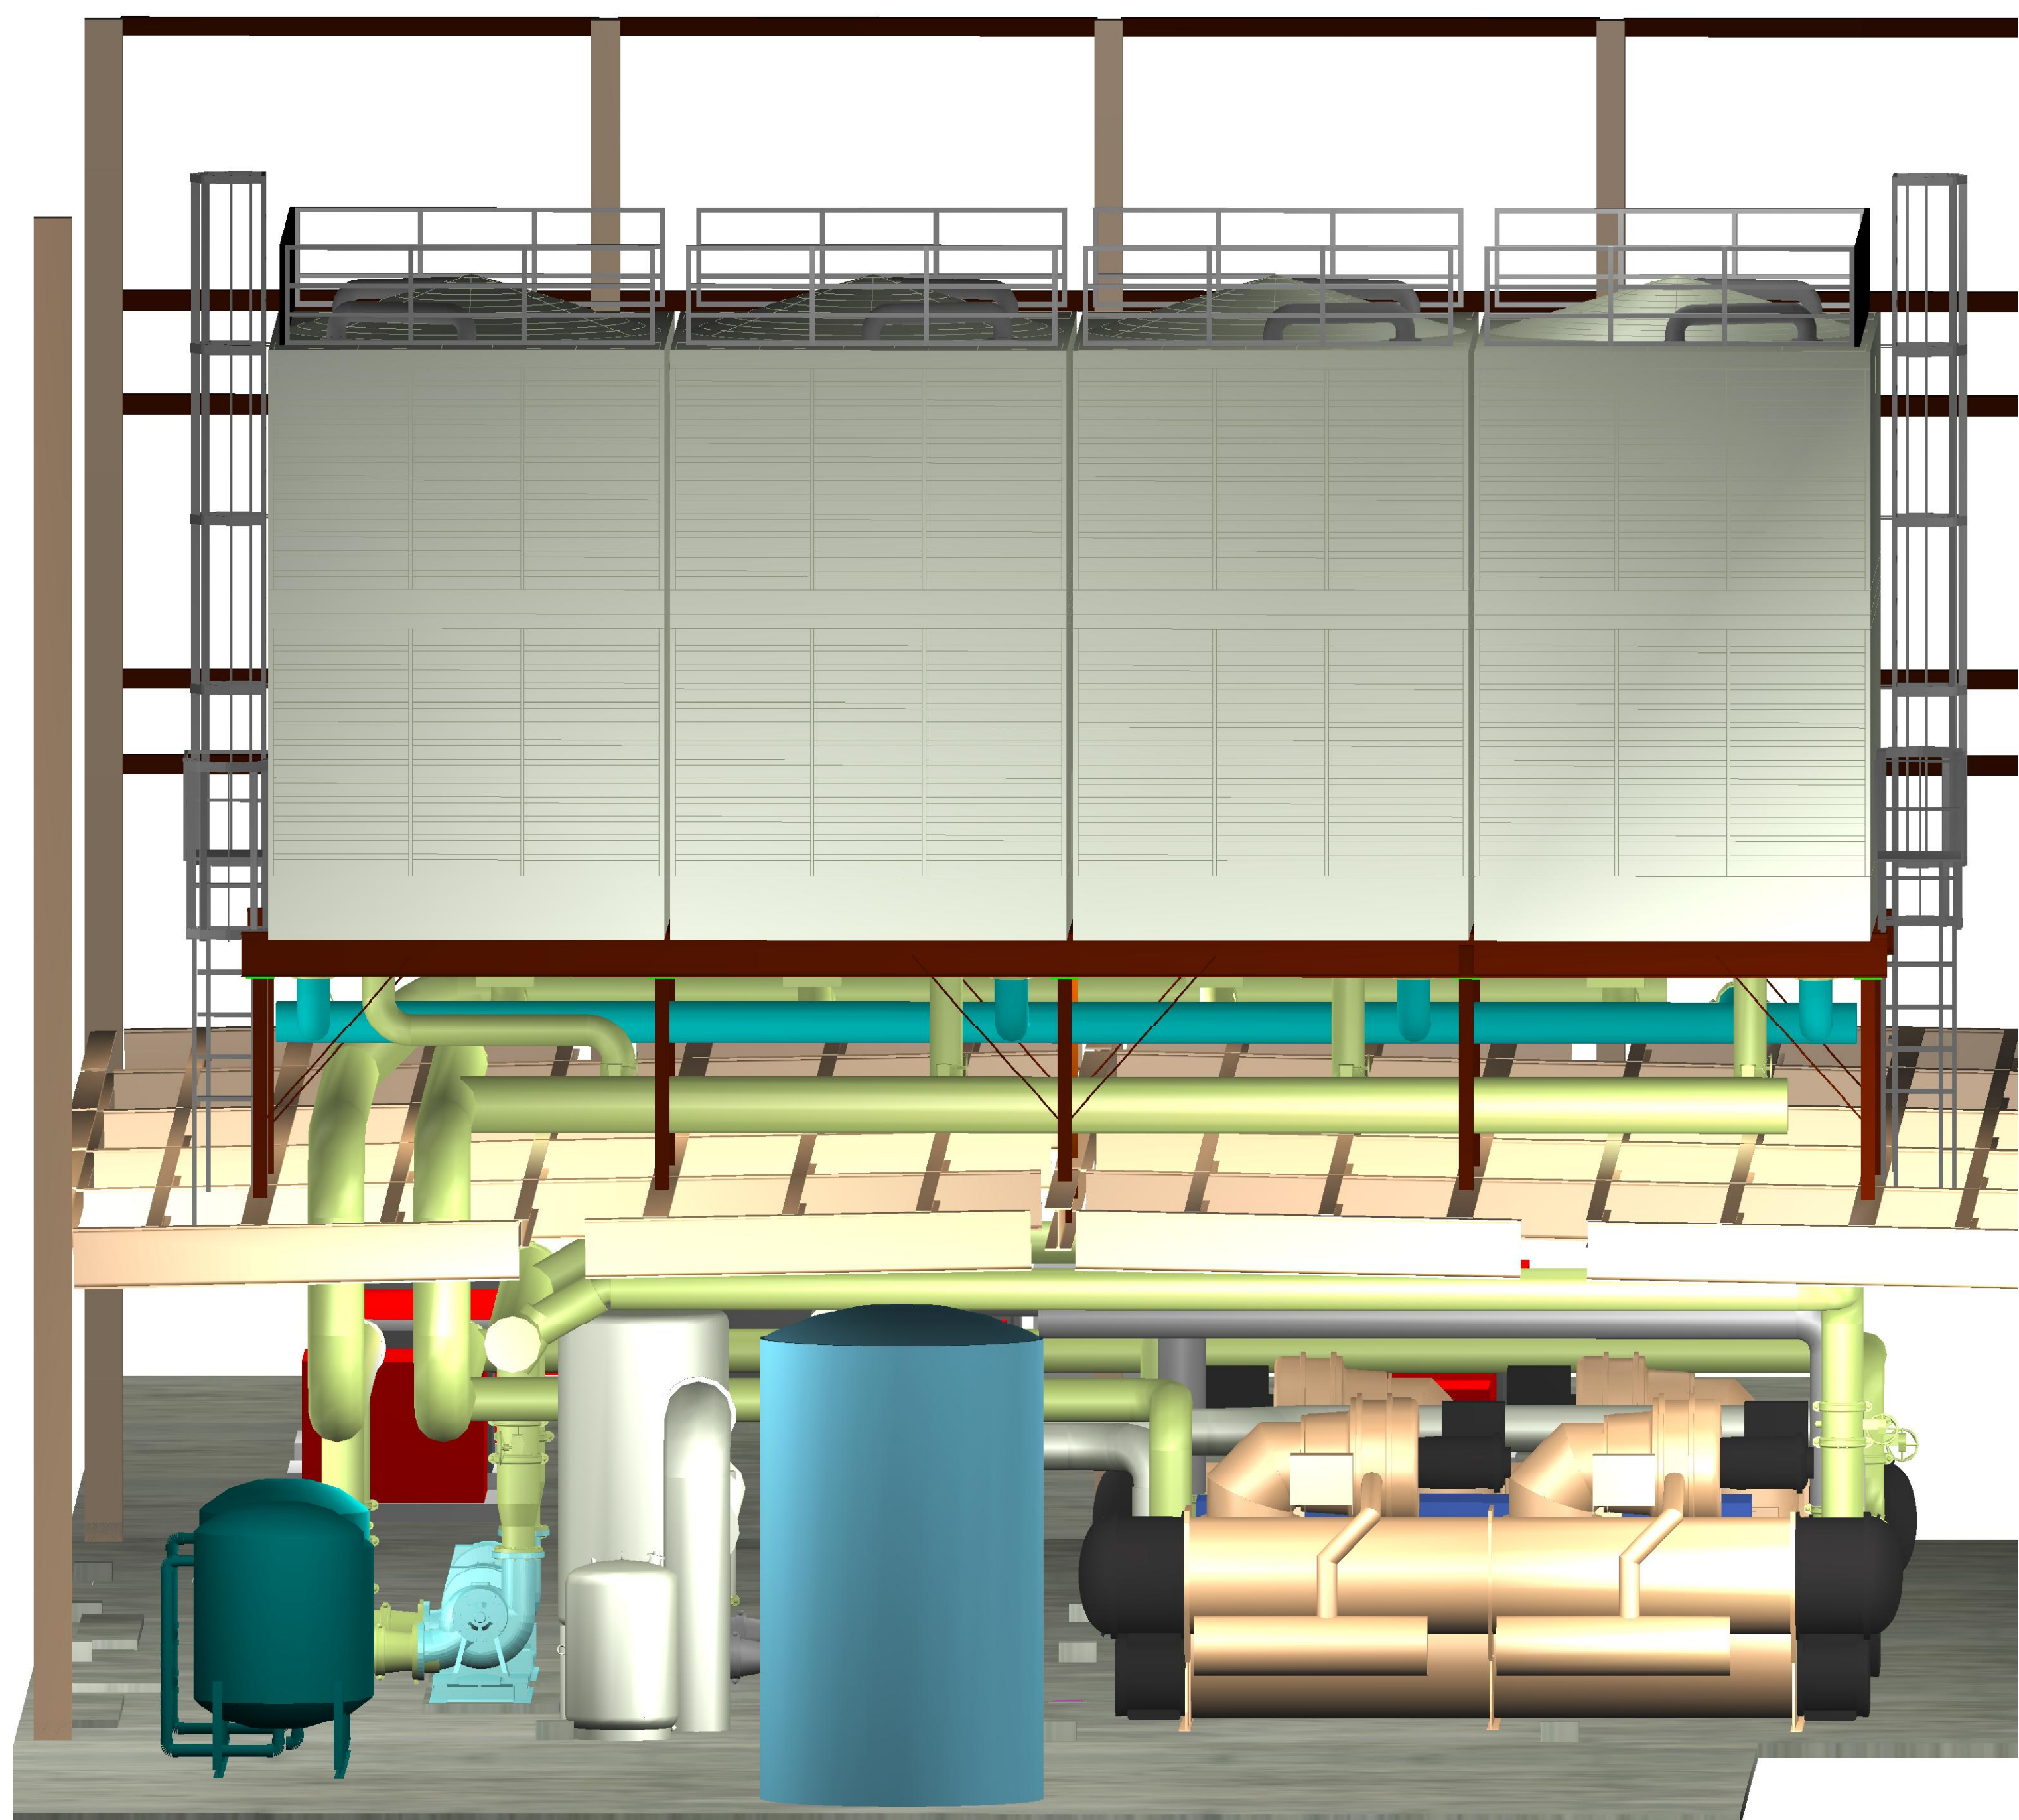



**MECHANICAL CHILLER PLANT 3-D - NORTH ELEVATION**

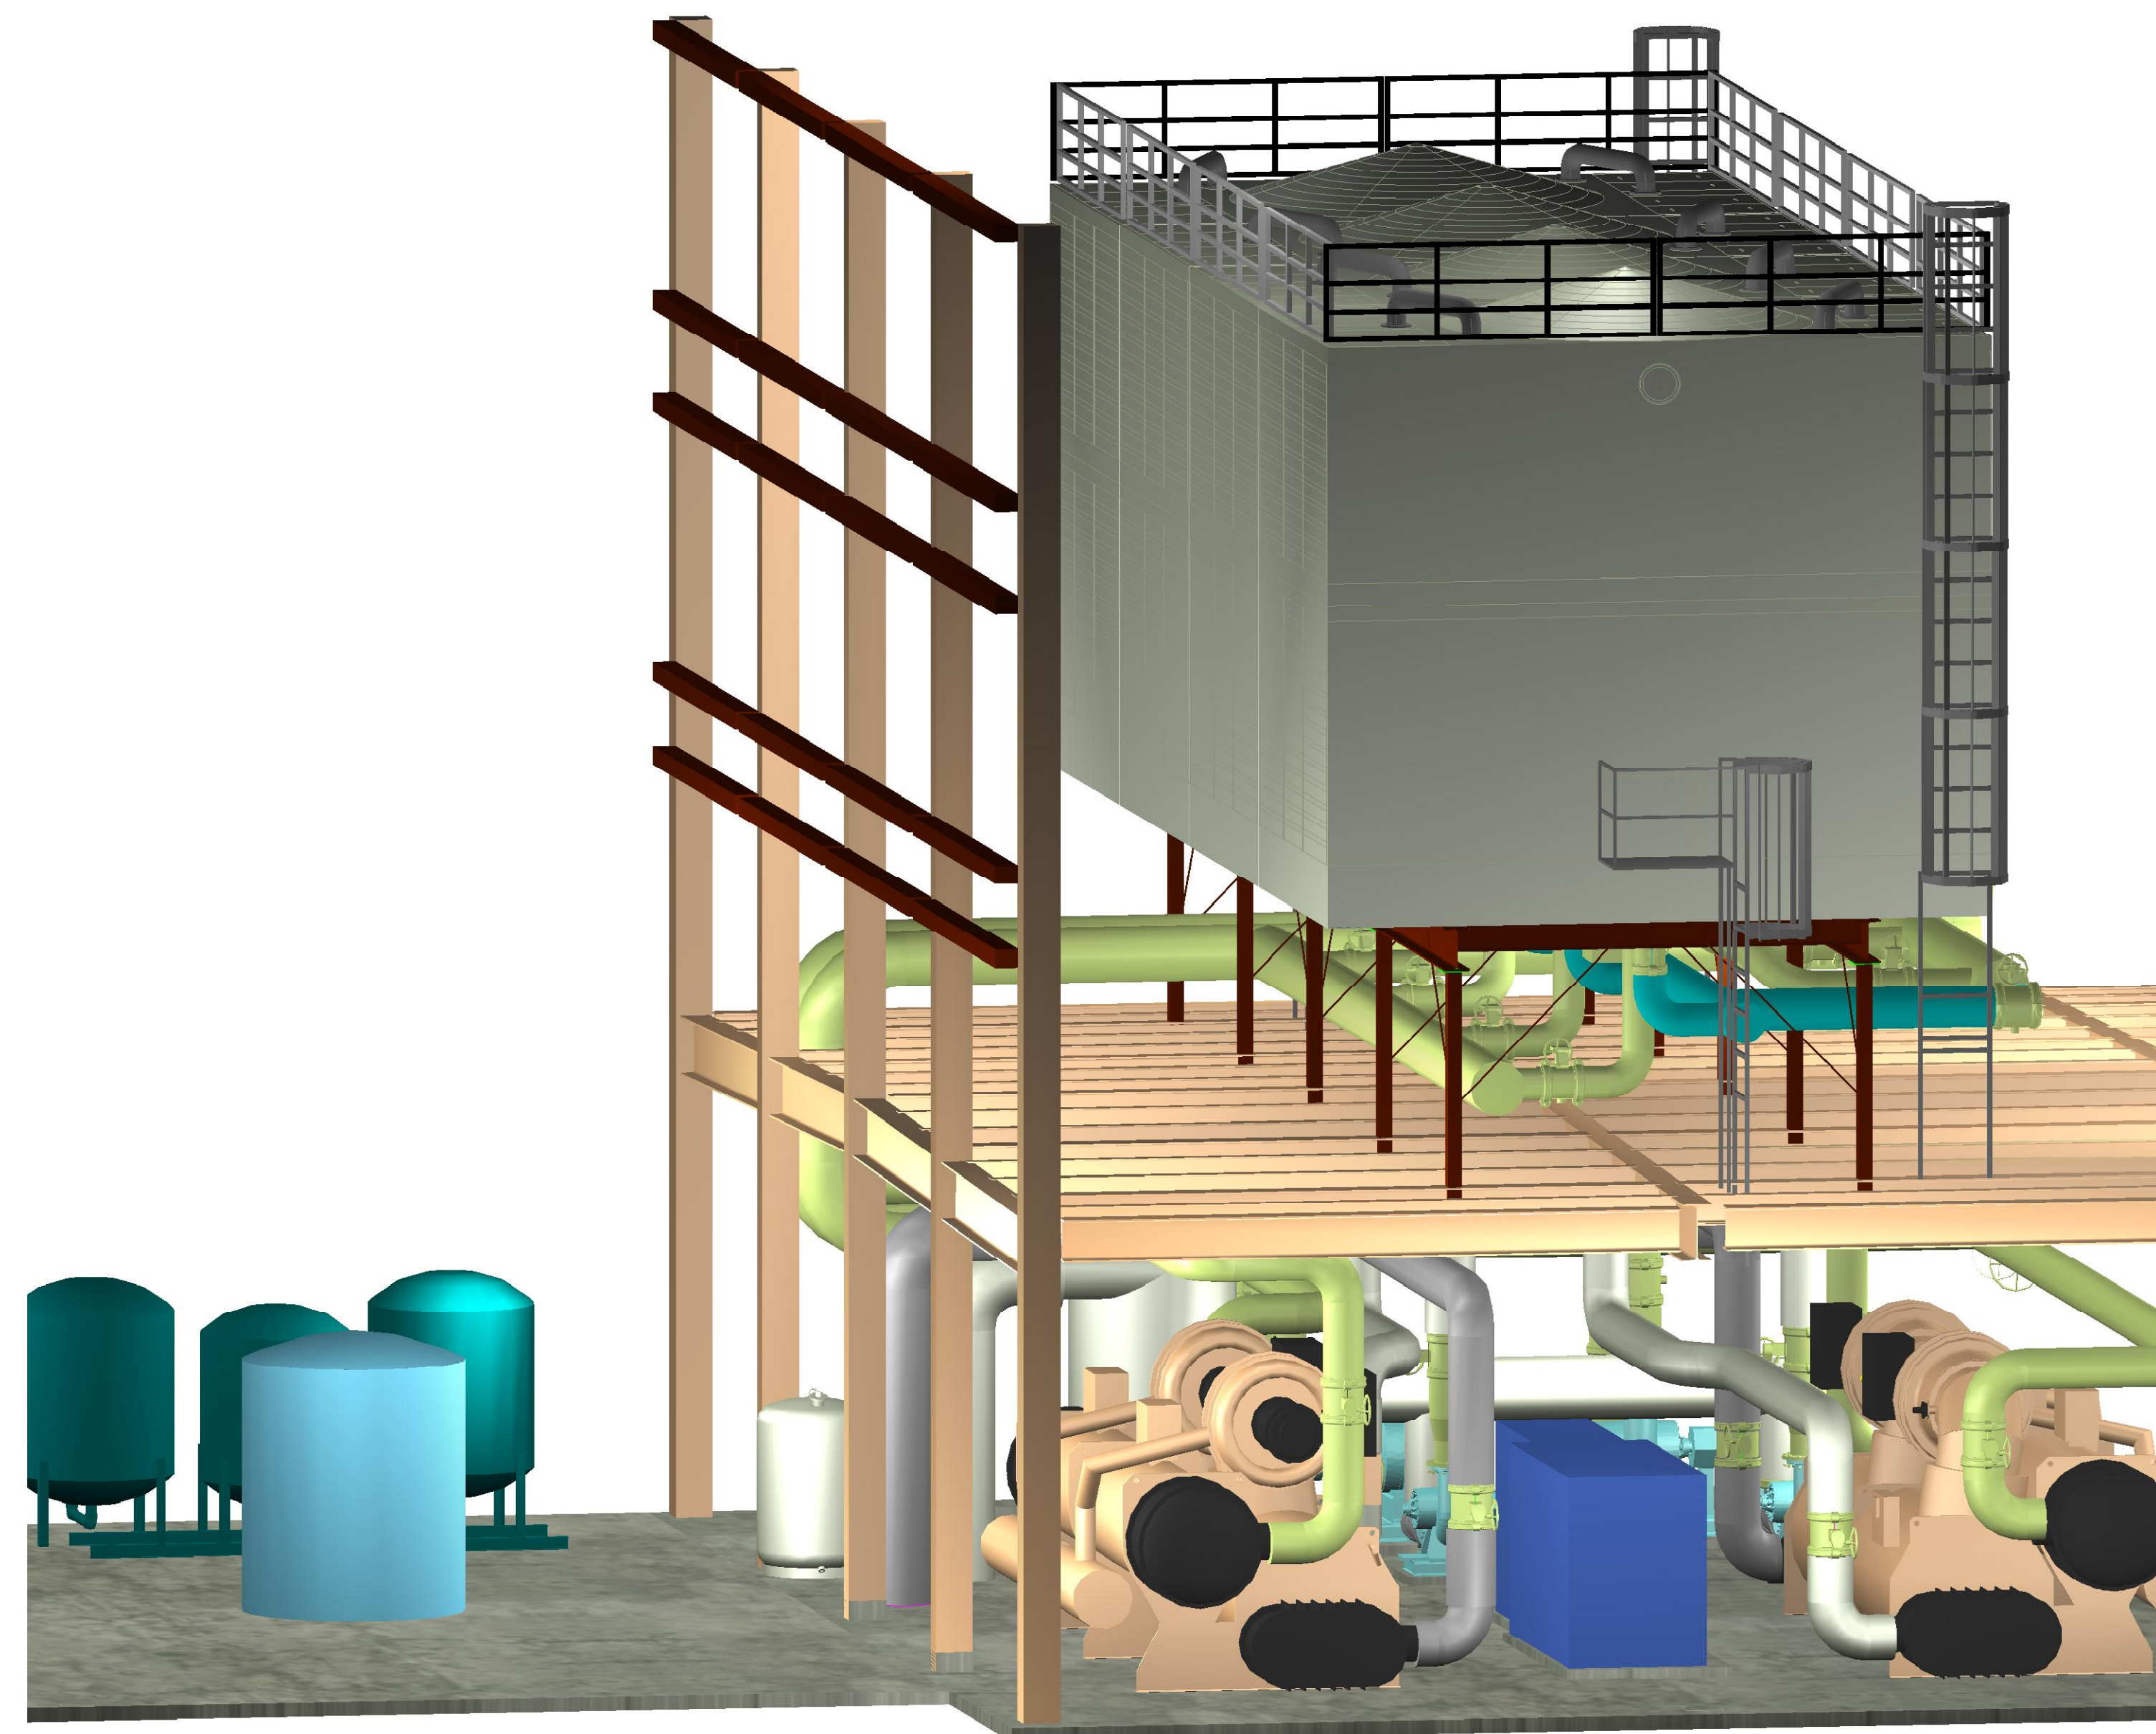SCALE: NONE



**MECHANICAL CHILLER PLANT 3-D - WEST ELEVATION**

SCALE: NONE

PIPING COLOR LEGEND	
CONDENSER WATER PIPE	
CHILLED WATER PIPE	
EQUALIZER PIPE	