

DEAN S. KENTON, P.E.
 F.L.I.C. No. 44012




Signature	Date

**UNIVERSITY OF SOUTH FLORIDA
 SOUTH EAST CHILLER PLANT
 BR-590 COMPONENT #6**

12225 USF MAPLE DRIVE
 TAMPA, FLORIDA 33620

DRAWING TITLE :	
MECHANICAL DETAILS	
FILE NAME :	081106_M-19.006
DATE :	03-31-2008
PLOT SIZE: NOT TO SCALE	
DRAWN BY :	HR
DESIGNED BY :	TSH
CHECKED BY :	TSH
PROJECT NO. :	081106
SHEET NO. :	

Drawing Progress: 100% CONSTRUCTION DOCUMENTS

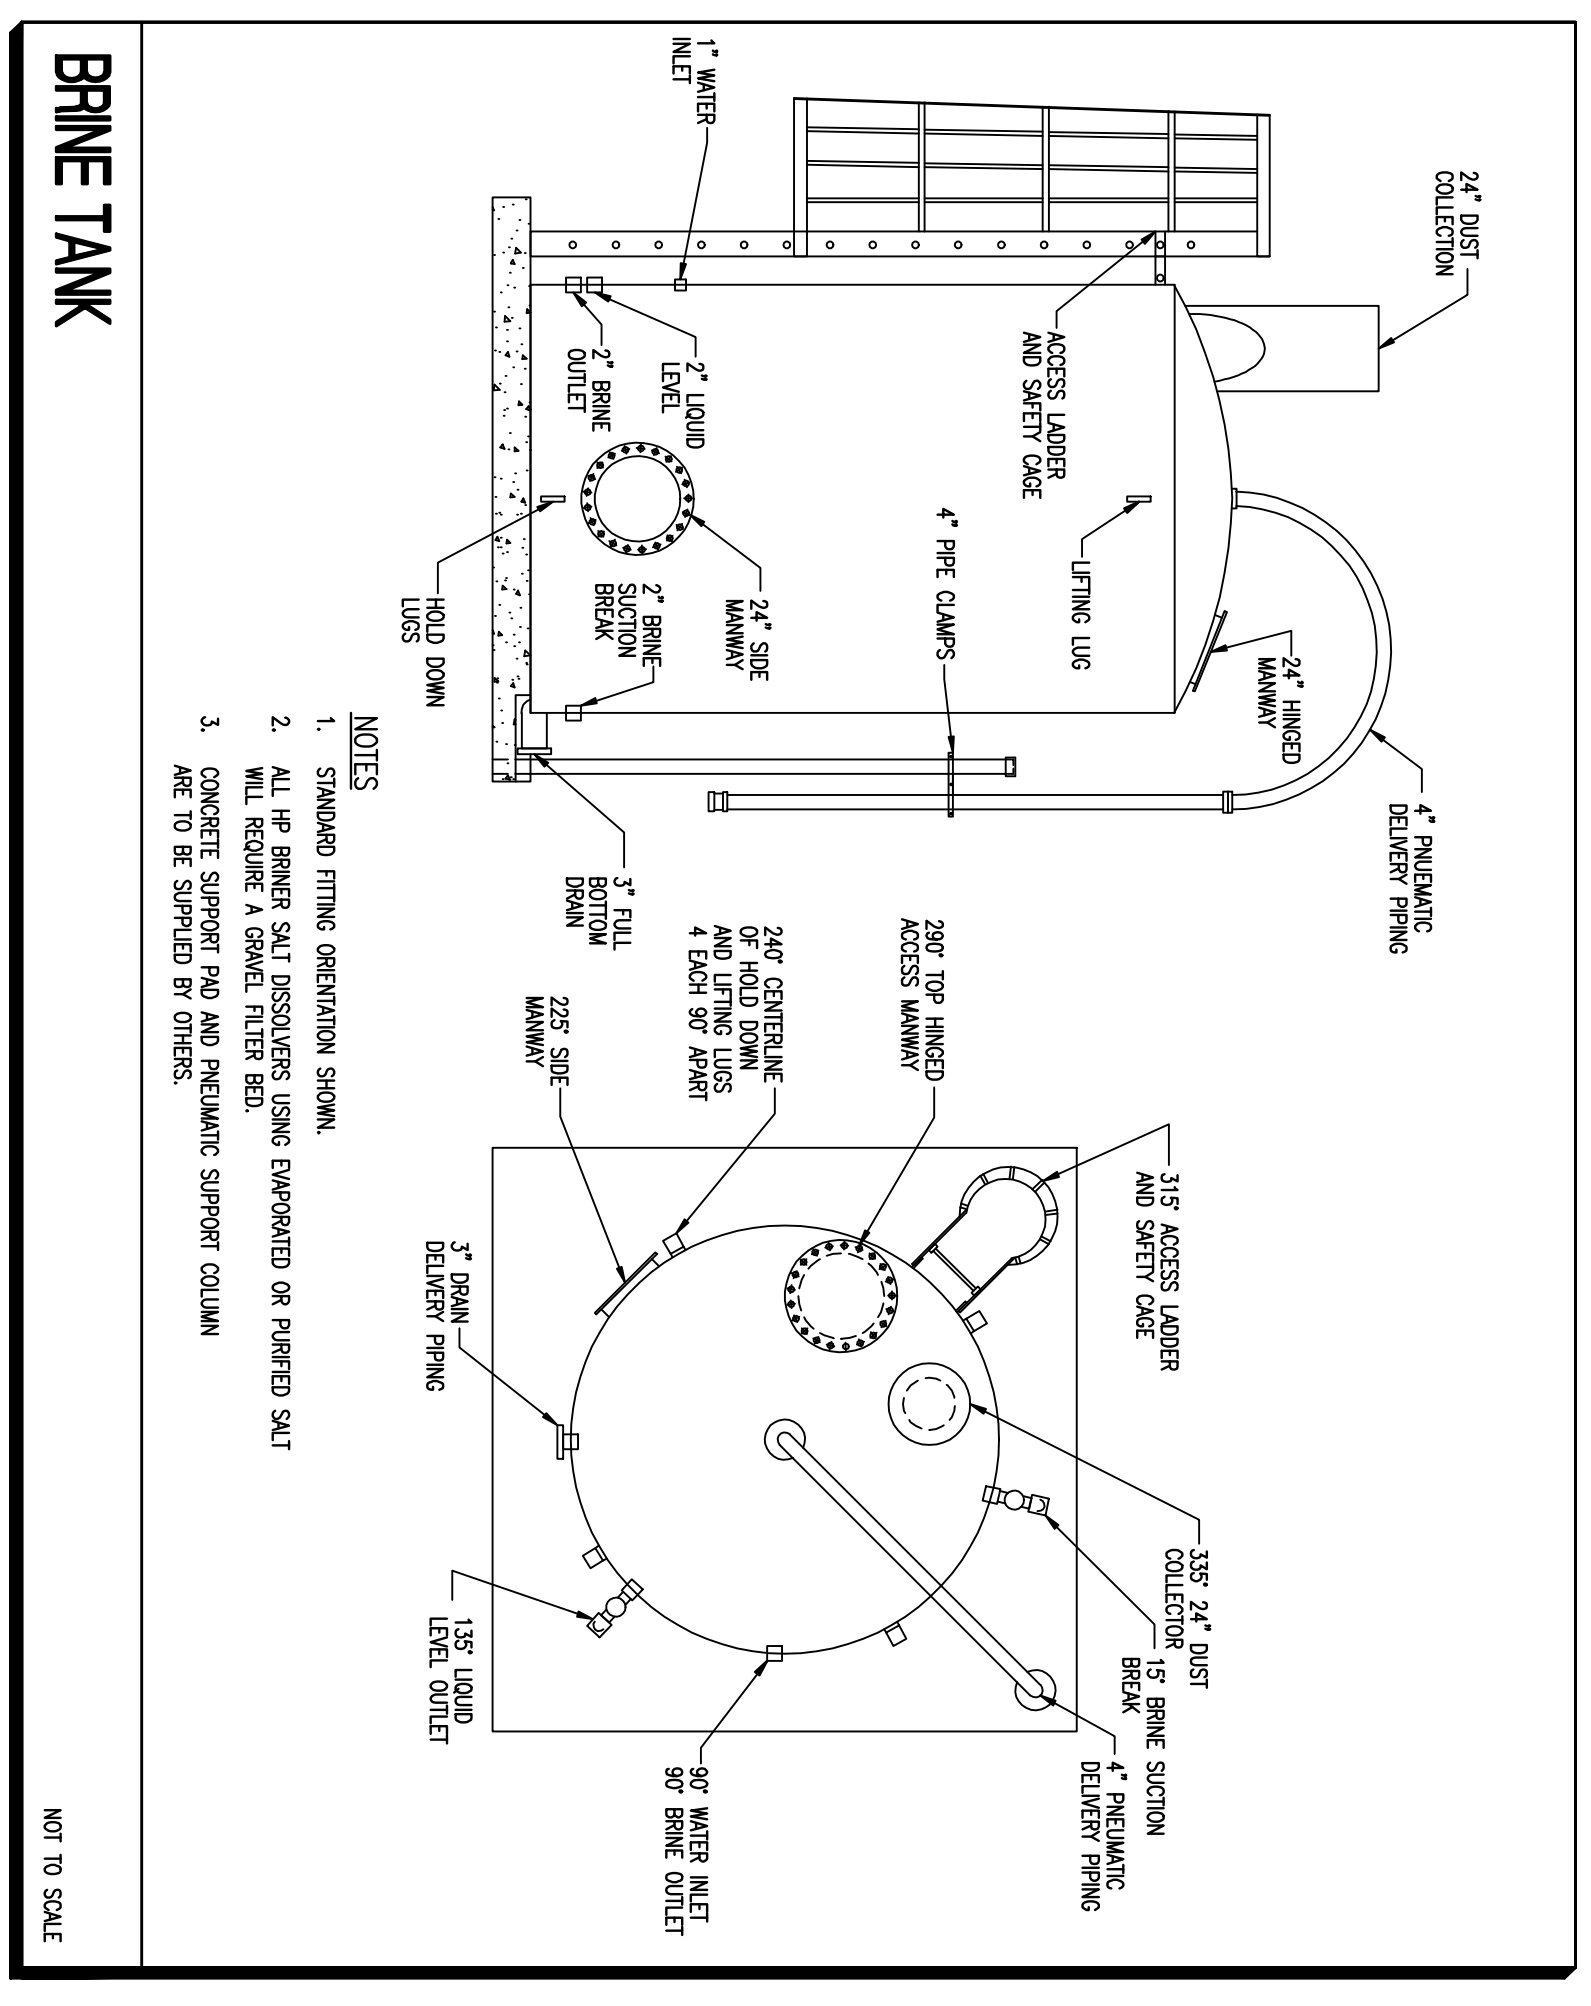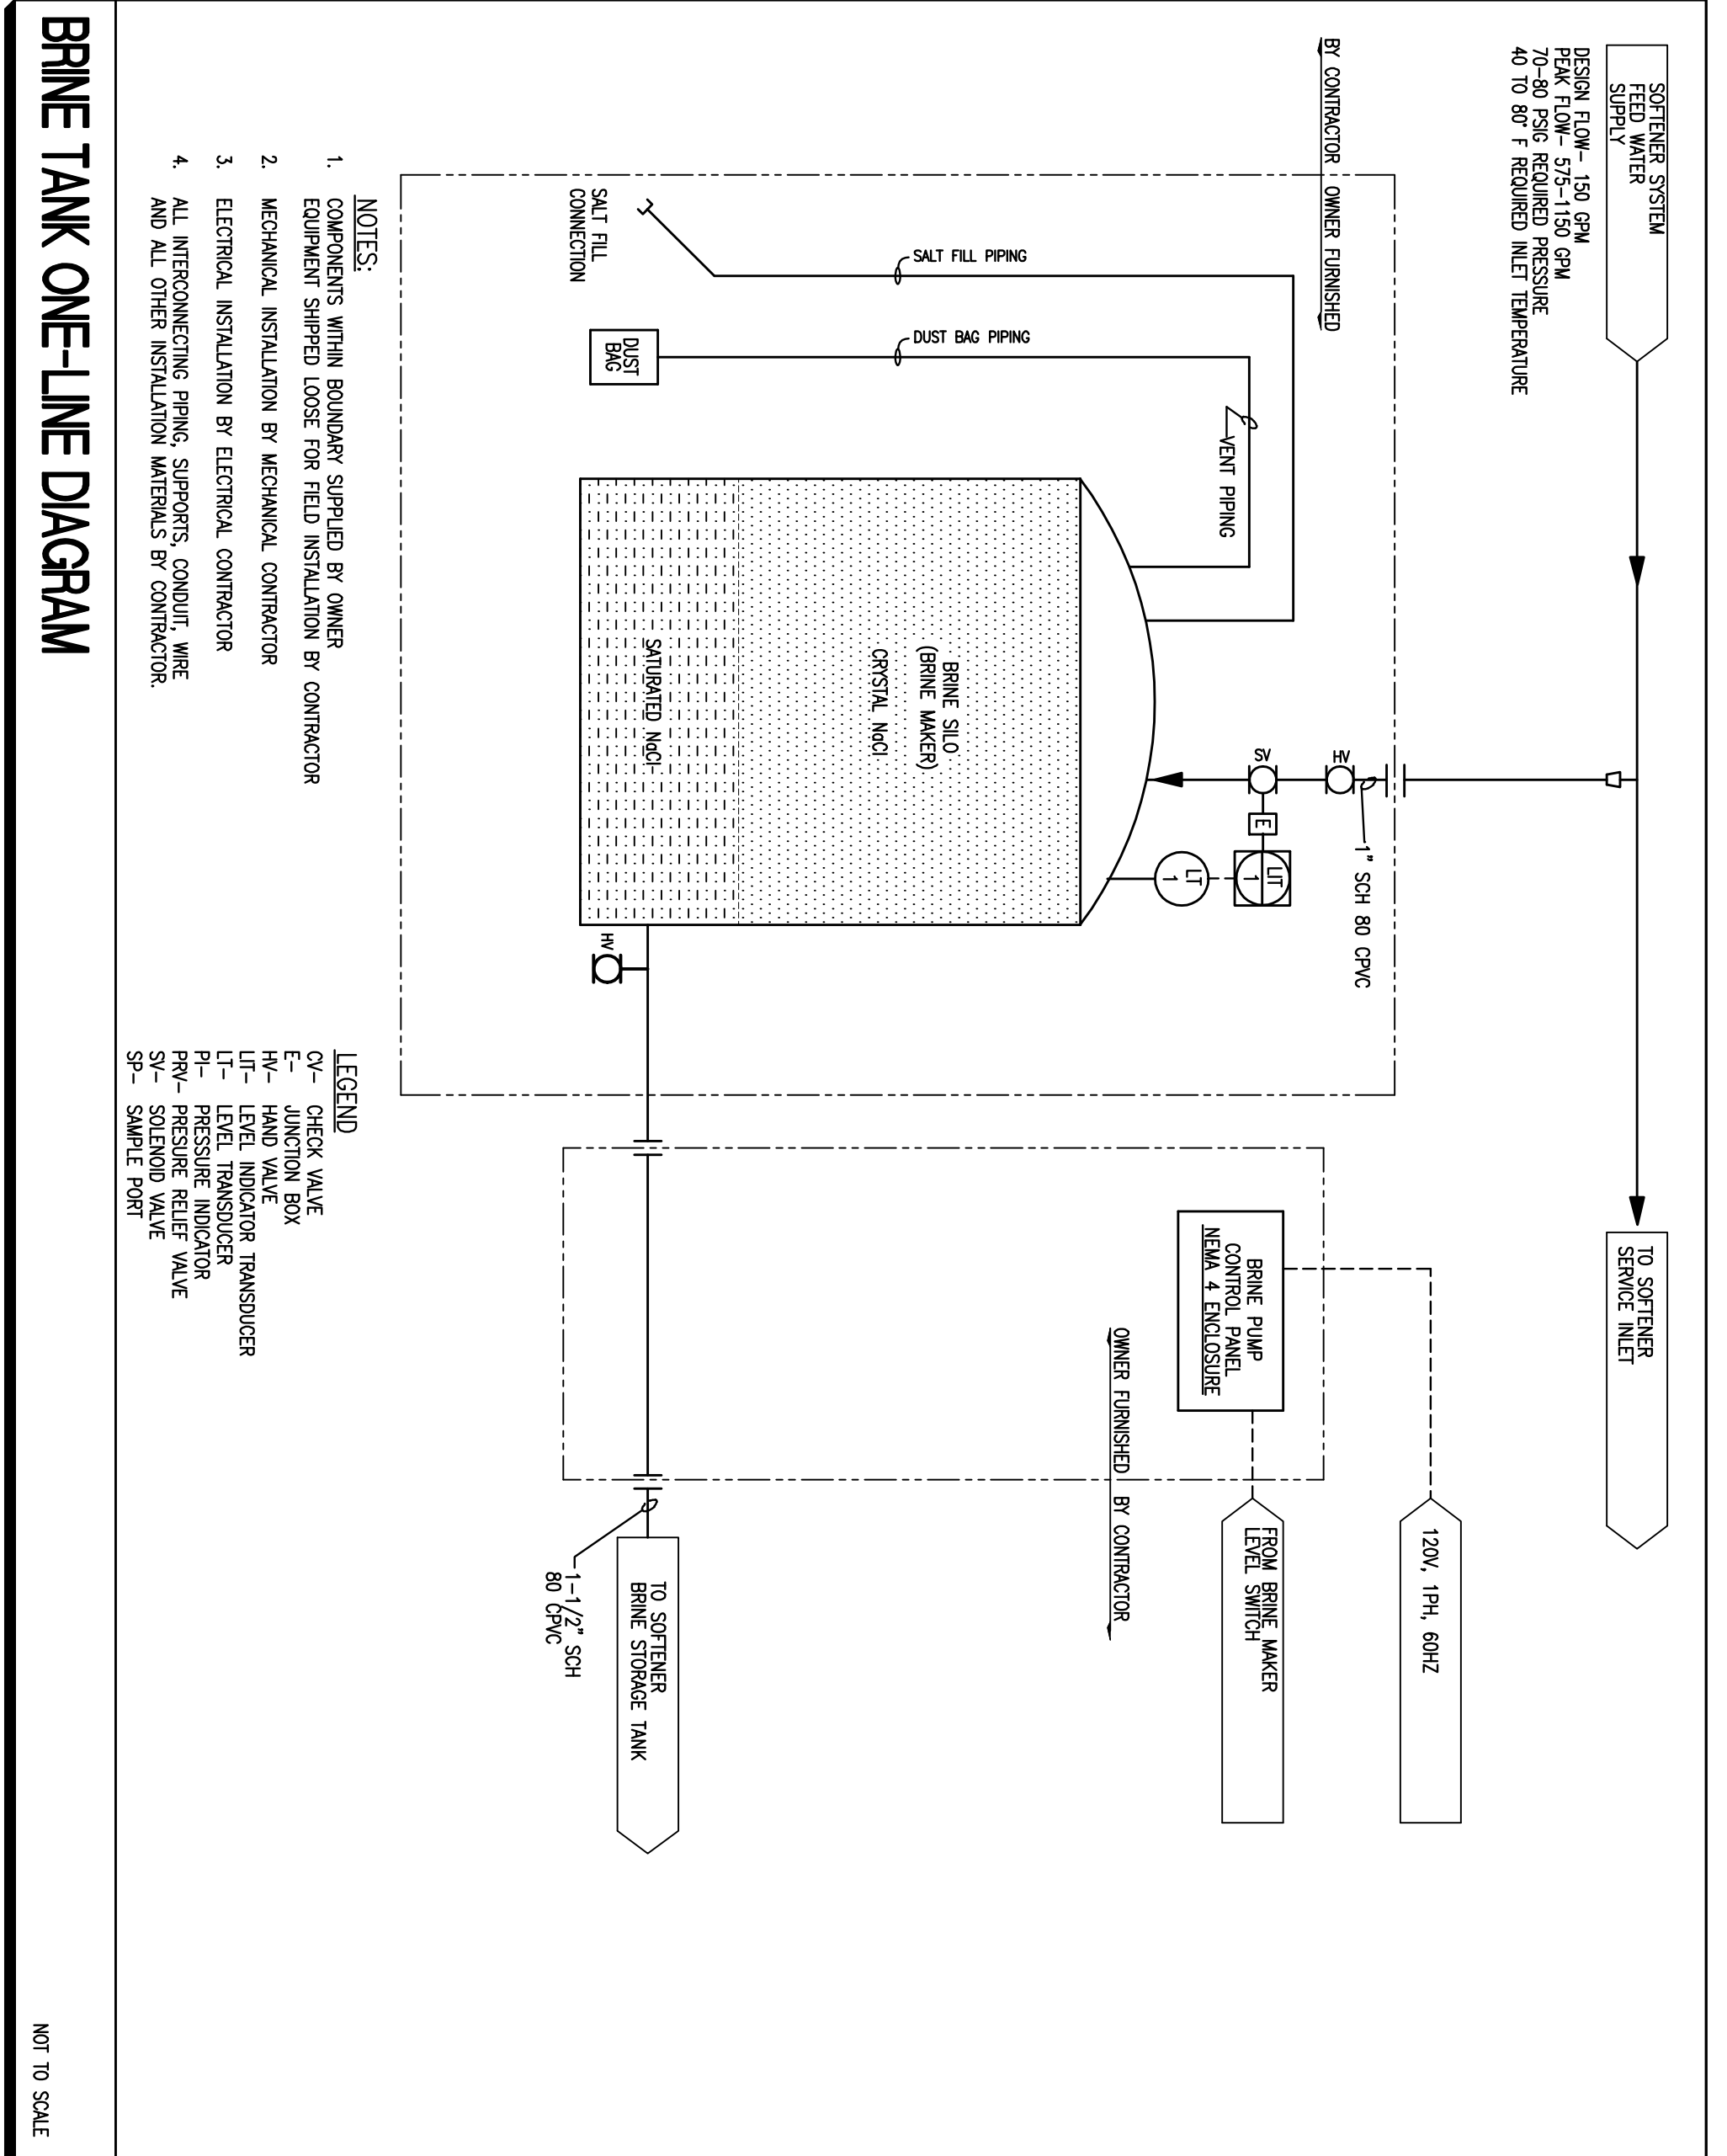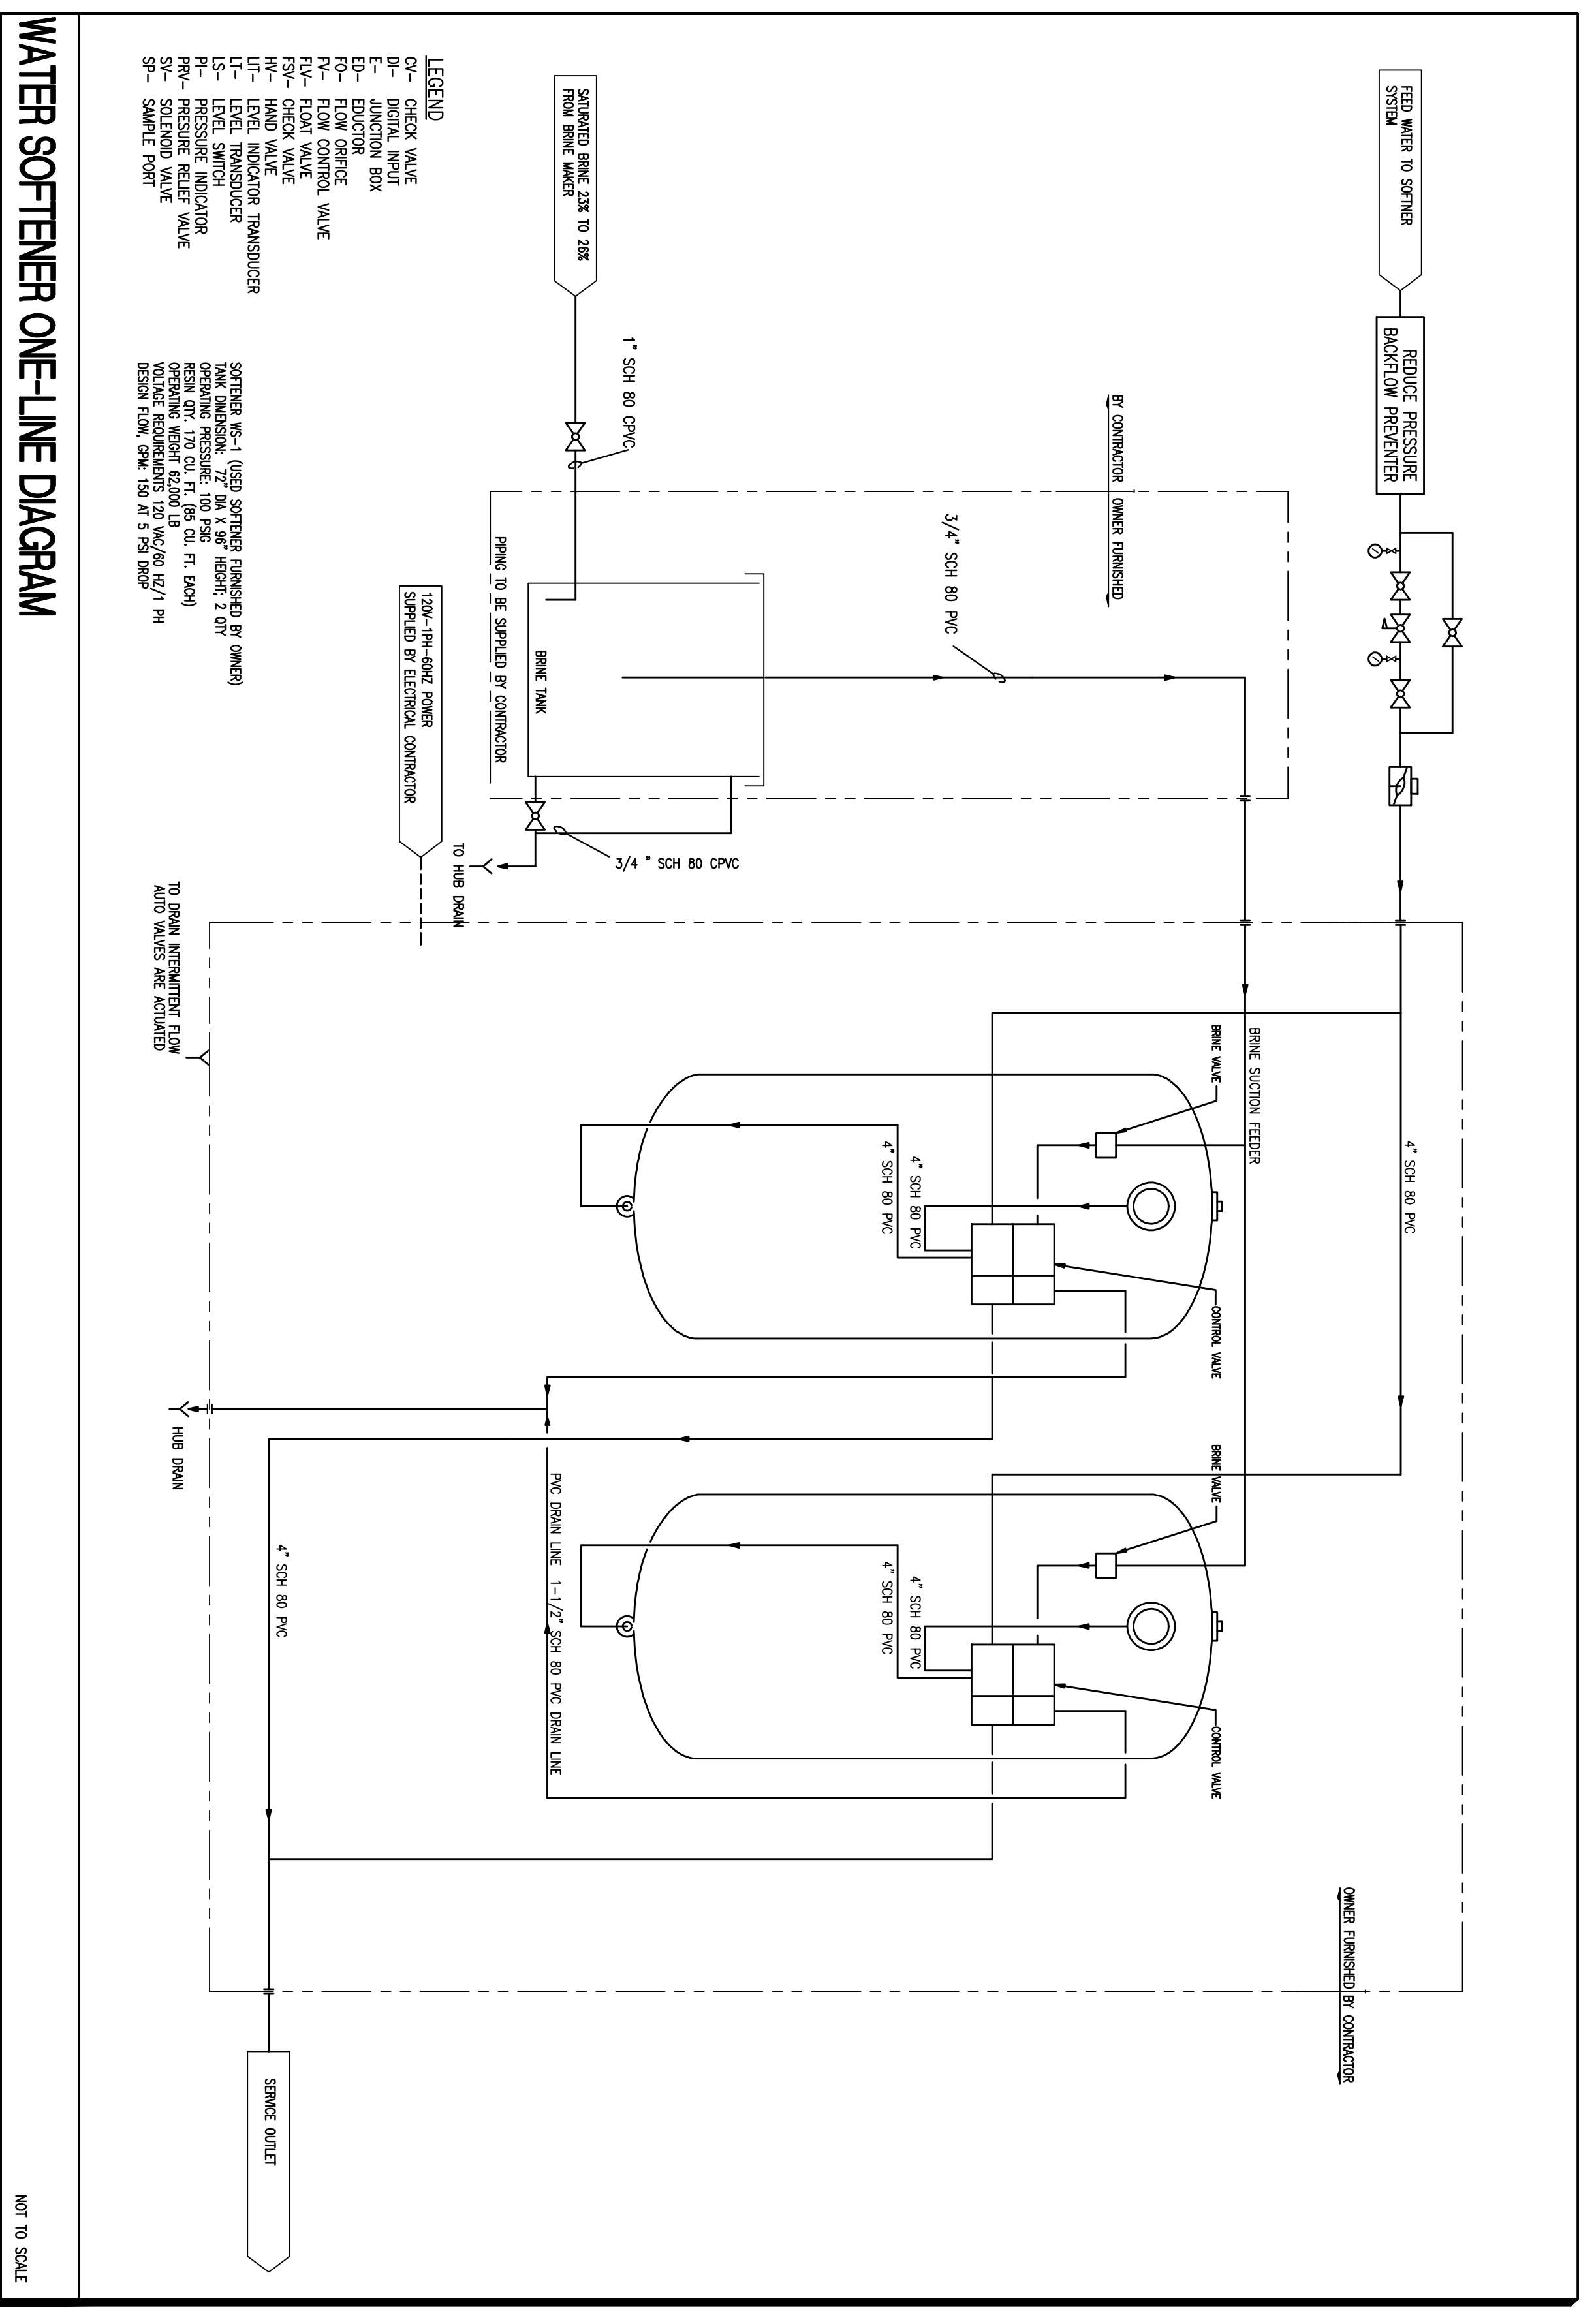

WATER SOFTENER ONE-LINE DIAGRAM

BRINE TANK ONE-LINE DIAGRAM