


DEAN S. KENYON, P.E.
 FL LIC. No. 44072

Signature	Date
DRAWING REVISIONS	
REVISION	COMMENTS

**UNIVERSITY OF SOUTH FLORIDA
 SOUTH EAST CHILLER PLANT
 BR-590 COMPONENT #6**

12225 USF MAPLE DRIVE
 TAMPA, FLORIDA 33620

DRAWING TITLE :	
PLUMBING RISER DIAGRAM	
FILE NAME:	081106_P-5.DWG
DATE:	08-31-2009
PLOT SIZE:	AS NOTED
CALCULATED BY:	ROR
DESIGNED BY:	TSN
CHECKED BY:	TSN
PROJECT NO.	081106
SHEET NO.	
Drawing Progress: 100% CONSTRUCTION DOCUMENTS	

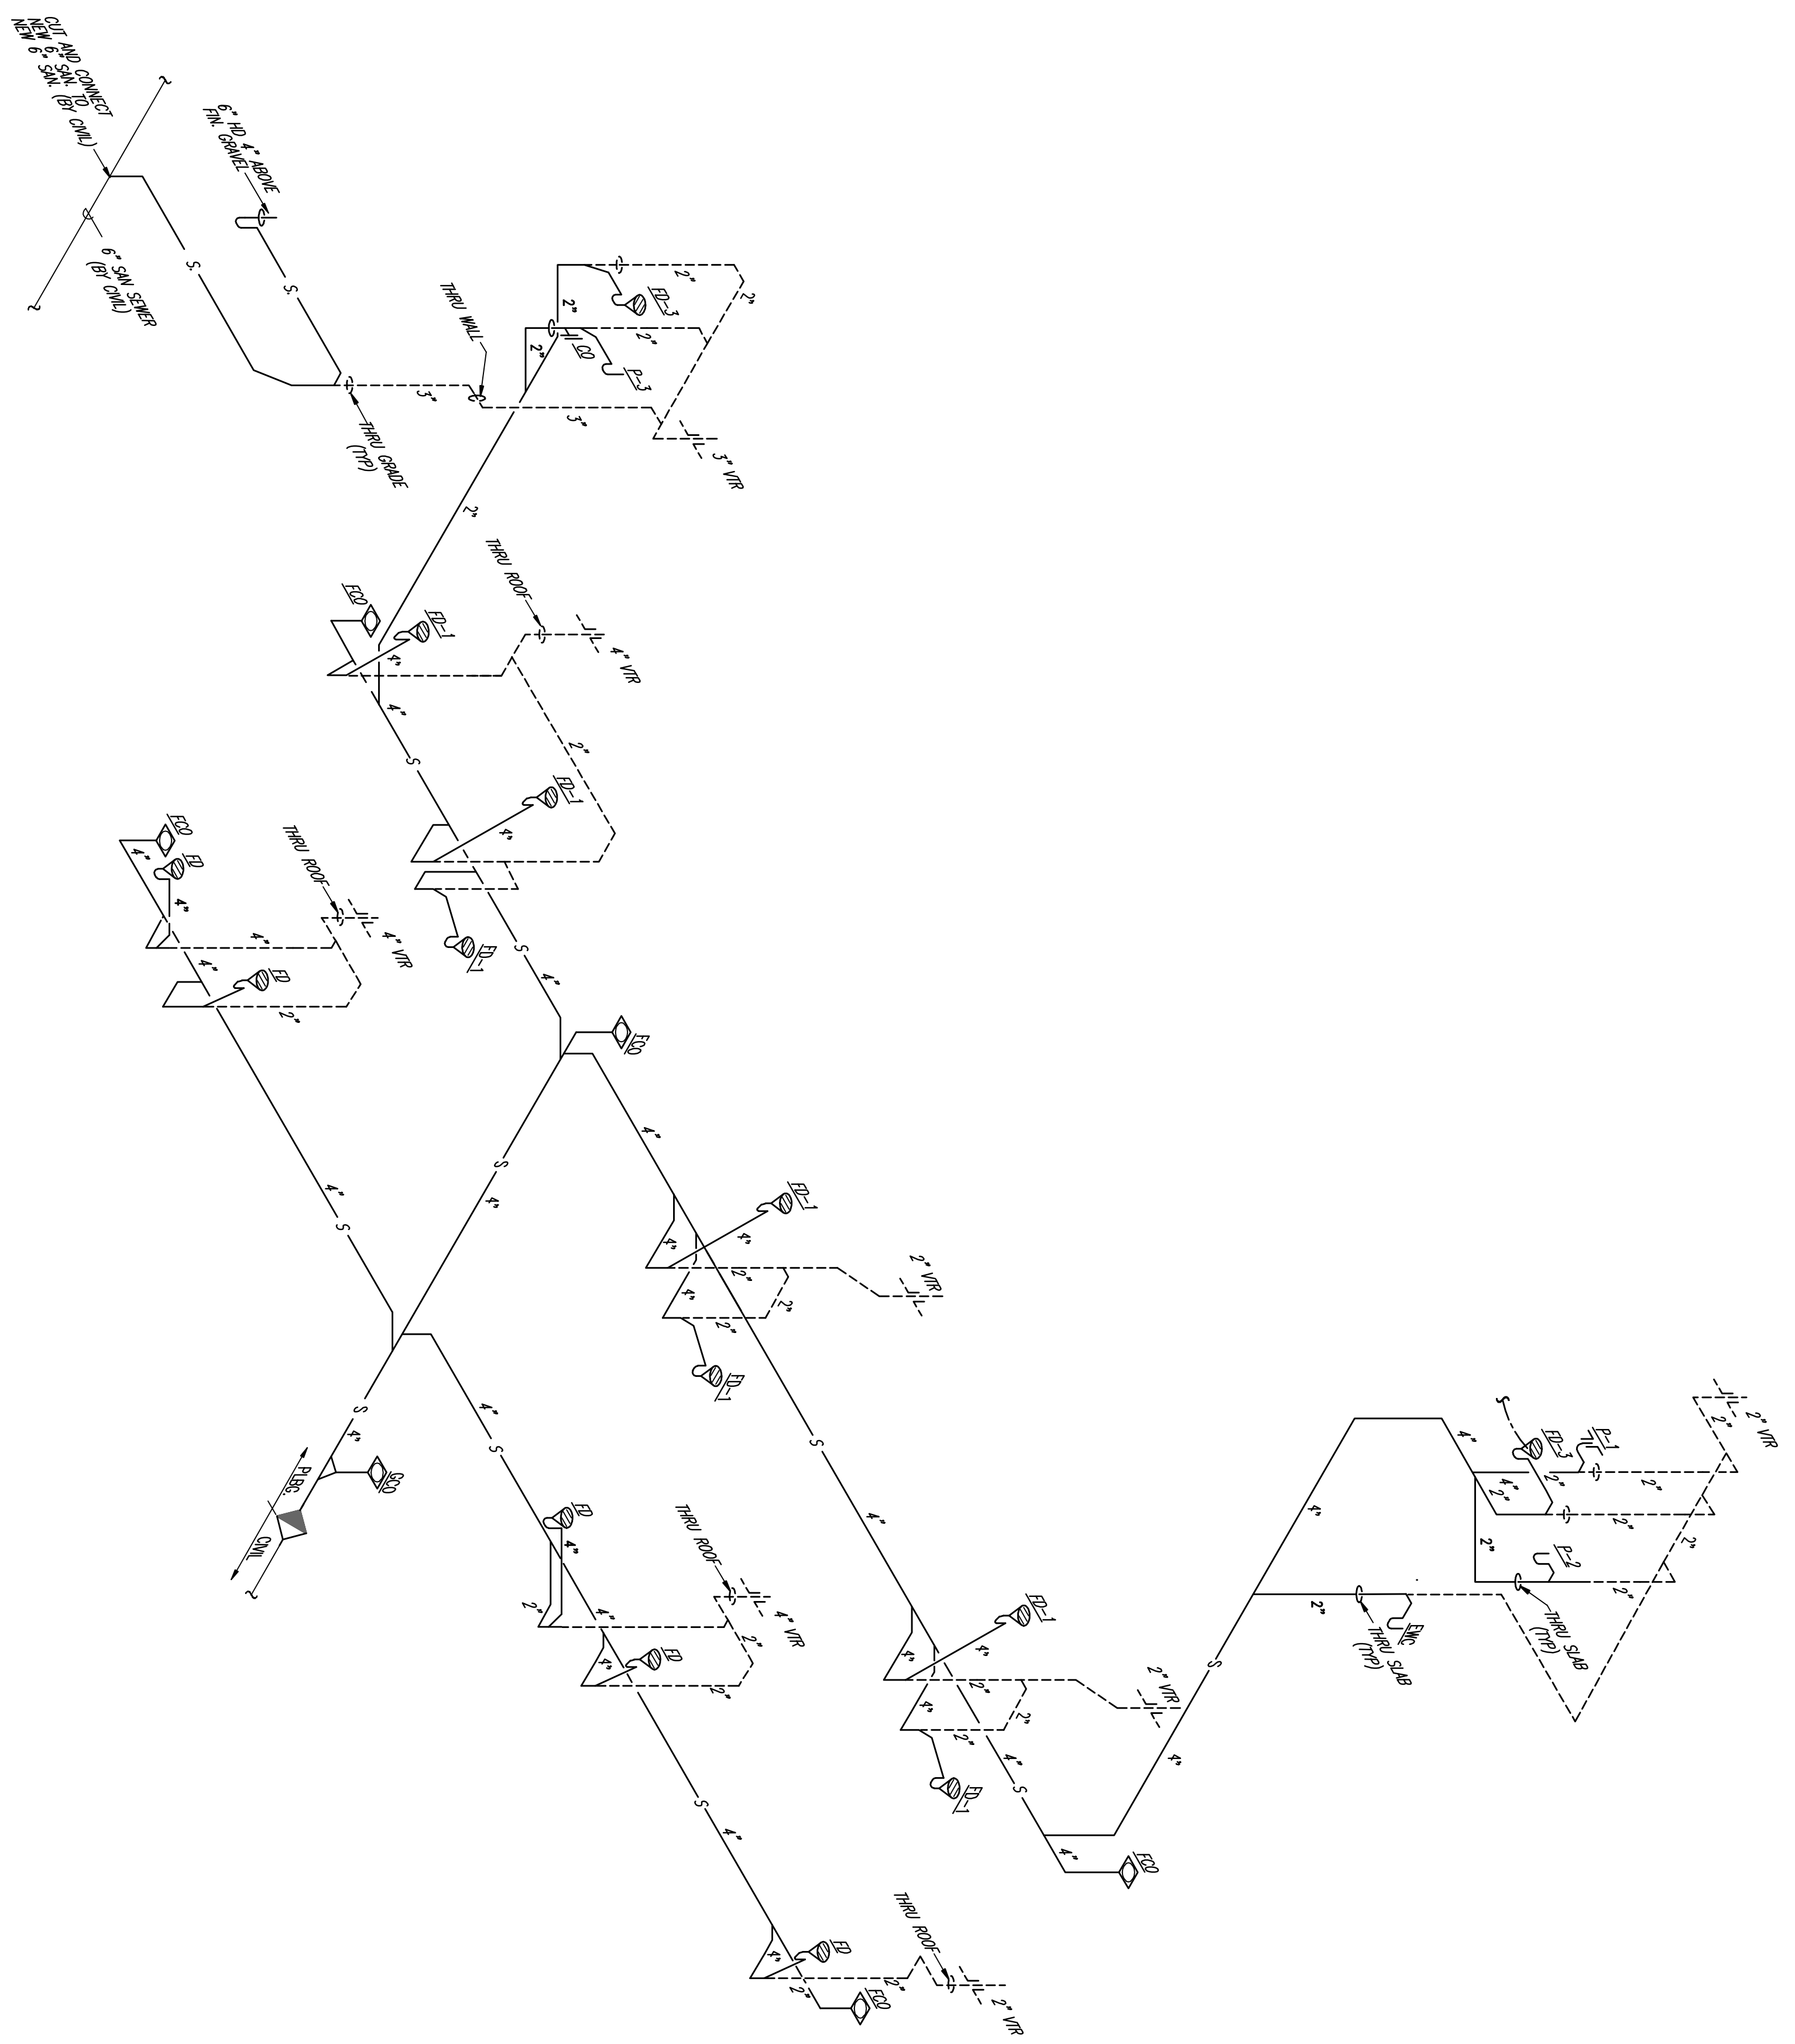

PLUMBING SANITARY/VENT RISER DIAGRAM

NOT TO SCALE