

Owner:
WESTMINSTER
COMMUNITIES
OF FLORIDA

80 WEST LUCERNE AVENUE
Orlando, Florida 32839
Phone: (407) 538-0077
Fax: (407) 538-0079



Project:
WESTMINSTER
TOWERS
ORLANDO
DINING ROOM AND
SERVING AREA
RENOVATION
70 WEST LUCERNE
ORLANDO, FL
32801

Scope Drawings:
These drawings indicate the
general scope of the project in
terms of construction. They
do not constitute a contract.
The drawings do not necessarily
indicate the location of all work
and the contractor shall be
responsible for the proper location
and completion of the work.


Drawing Title:
PLUMBING
FLOOR
PLANS

Revisions:

Issue Date: 05/14/10
Drawn By: EERMANIKK EERMAN
Checked By:
Certified By:
KENNETH L. EERMAN P.E.
FLA. REG. #30781

Drawing Number:
P-2

Project Number:
10023

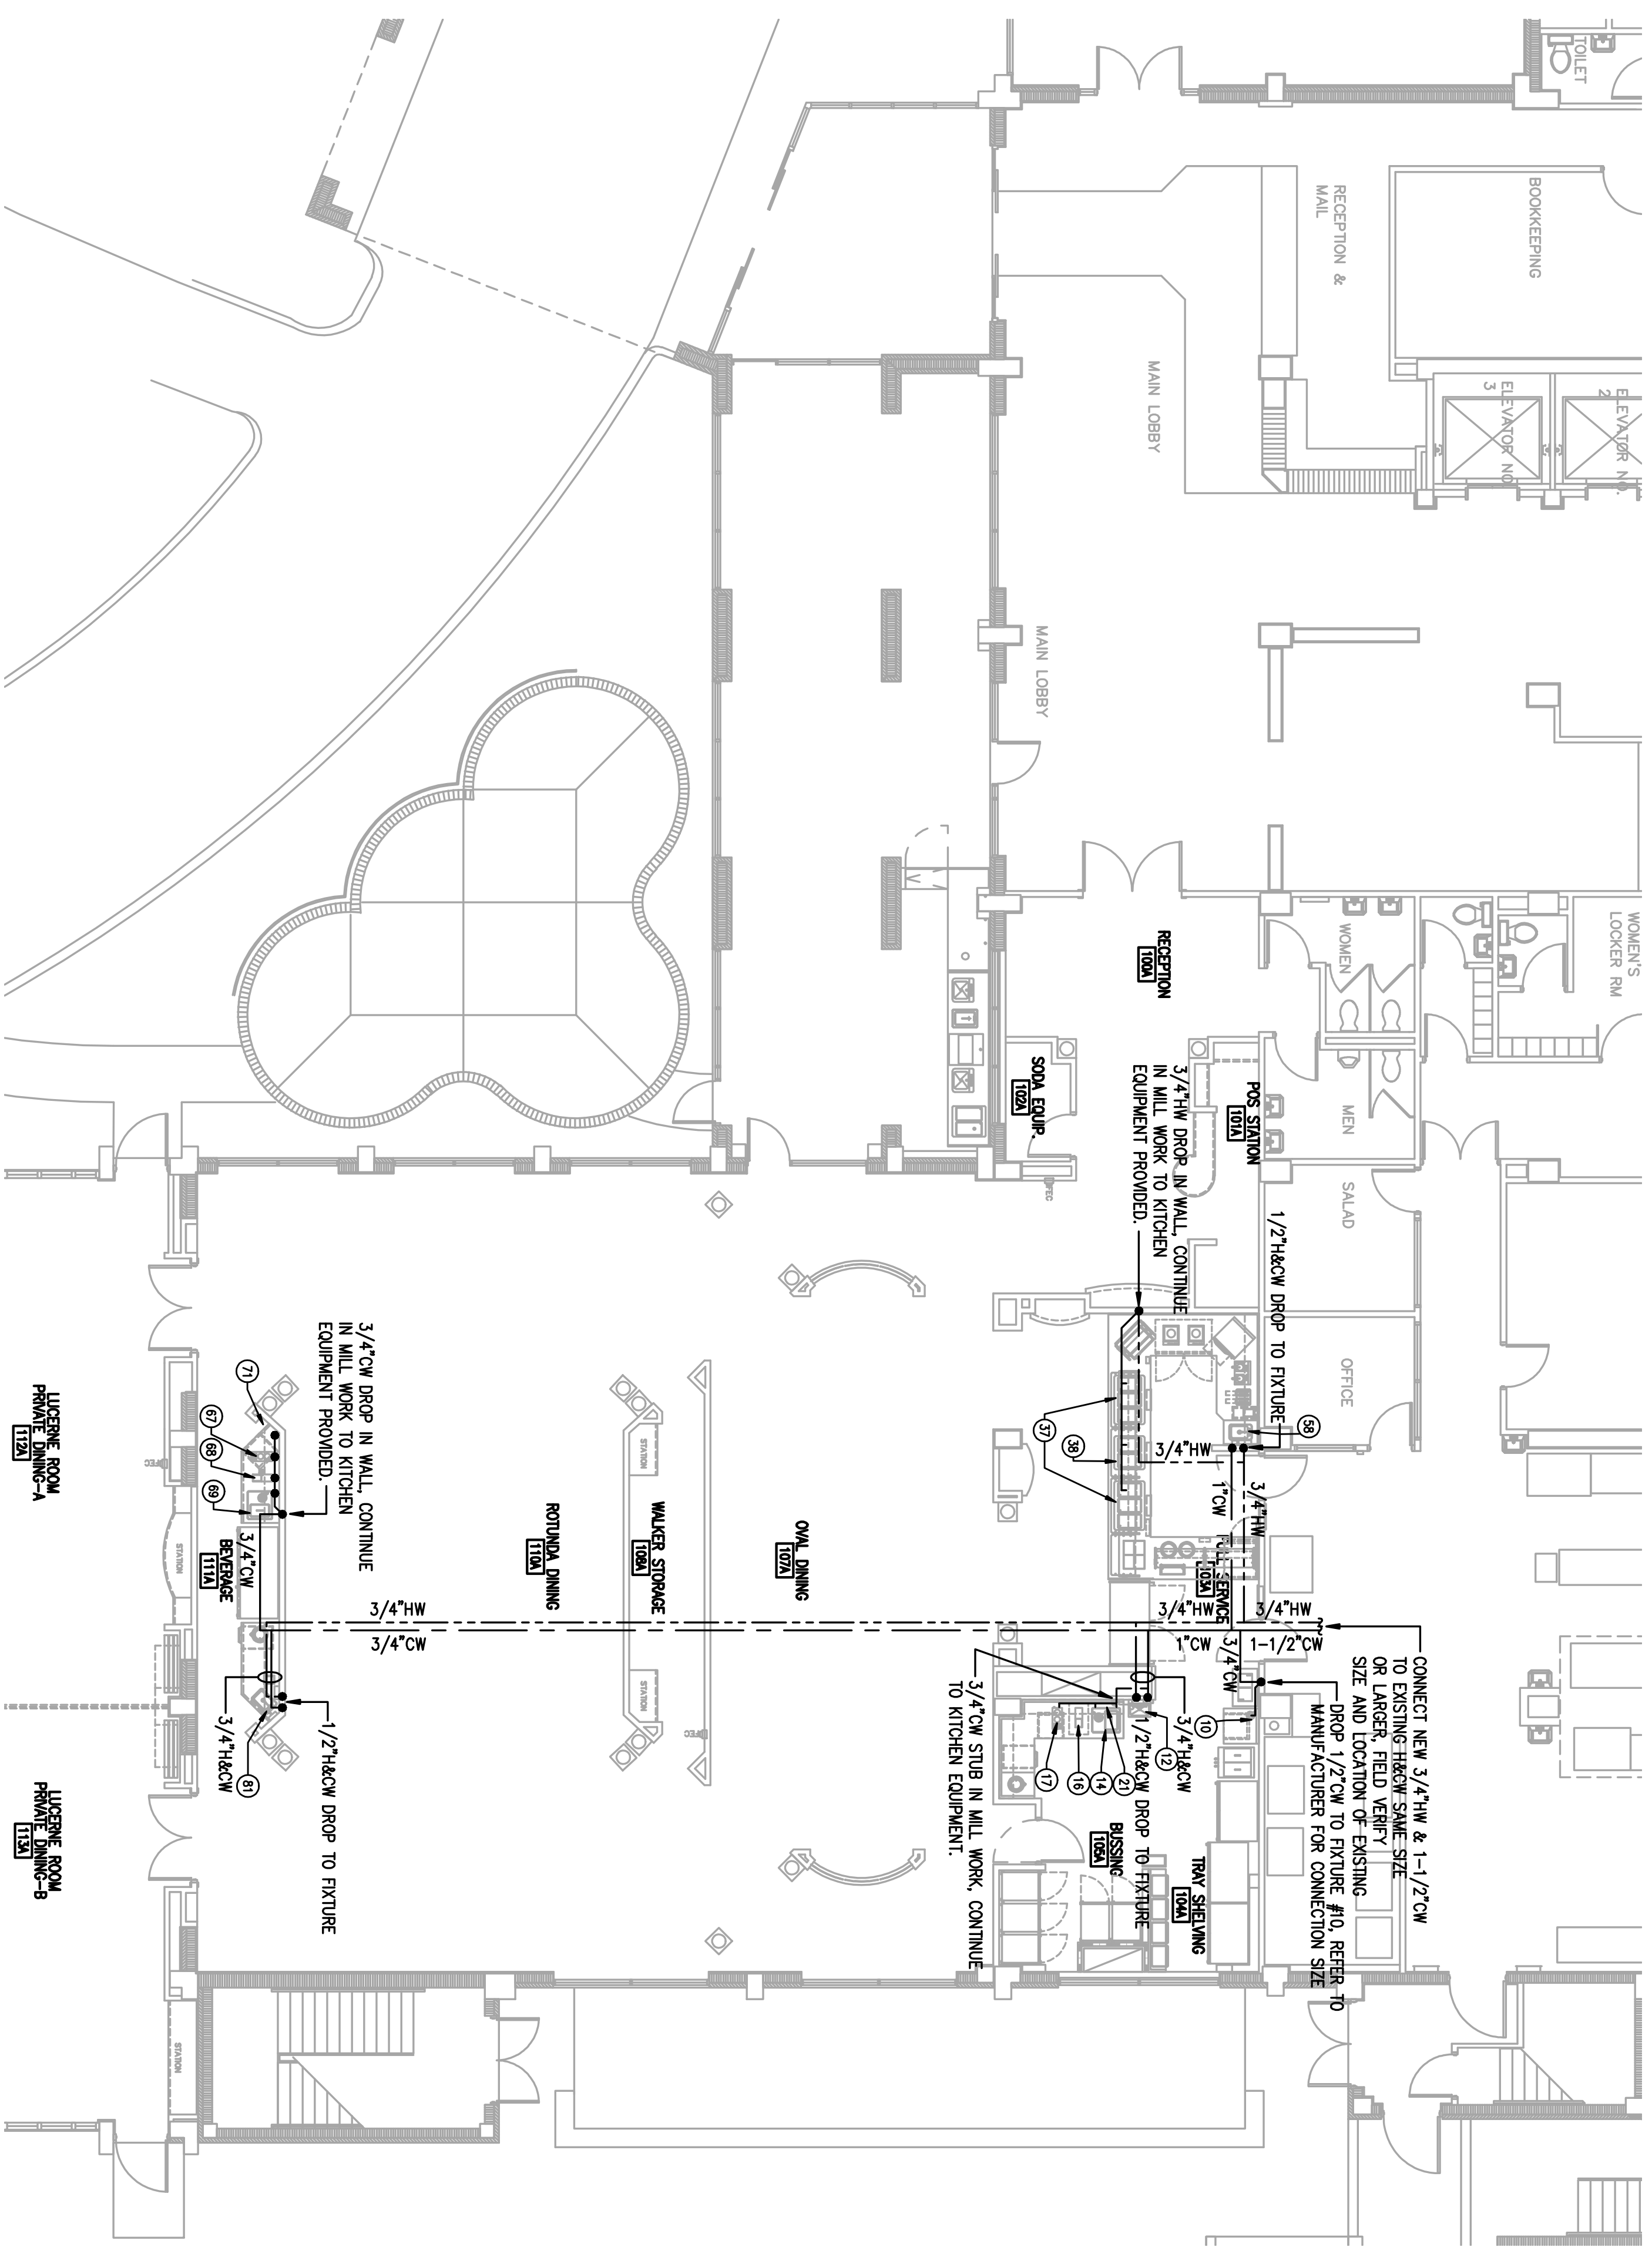

PLUMBING FLOOR PLAN
SCALE: 1/8" = 1'-0"

EERMANN ENGINEERING, INC.
CONSULTING ENGINEERS
Orlando, Florida 32804
TELEPHONE: (407) 298-6961 FAX: (407) 298-7420
E-MAIL: EERMANIKK@AOL.COM
Copyright 2010 EERMANN ENGINEERING INC.
FLORIDA REG. #0009900
EE JOB # 2772